

AIR CANADA WINDOW PARK REDEVELOPMENT

DRAWING INDEX

- L0.0 - COVER
- L0.1 - DEMOLITION PLAN

LANDSCAPE

- L1.0 - GENERAL ARRANGEMENT PLAN
- L1.1 - LAYOUT PLAN
- L1.2 - TREE LAYOUT PLAN
- L1.3 - GRADING PLANS
- L1.4 - PLANTING PLAN
- L1.5 - PLANTING PLAN
- L2.0 - DETAILS
- L2.1 - DETAILS
- L2.2 - DETAILS

STRUCTURAL

- S0.0 - NOTES, ABBREVIATIONS, SYMBOL LEGEND & DRAWING LIST
- S0.1 - NOTES
- S1.0 - SITE PLAN
- S2.0 - SECTIONS AND DETAILS
- S2.1 - SECTIONS AND DETAILS
- S2.2 - SECTIONS AND DETAILS

ELECTRICAL

- E0.0 - SYMBOL SCHEDULE, GENERAL NOTES AND DRAWING LIST
- E1.0 - EXISTING AND DEMOLITION ELECTRICAL SITE PLAN
- E2.0 - NEW ELECTRICAL SITE PLAN
- E2.1 - SITE DETAILS
- E3.0 - SCHEDULES AND DETAILS
- E4.0 - SINGLE LINE DIAGRAMS AND PANELBOARD SCHEDULES
- E5.0 - PANEL ELEVATION DETAILS
- E6.0 - SPECIFICATIONS

MECHANICAL

- M1.0 - SITE PLAN

CIVIL


- C1.0 - UNDERGROUND SITE SERVICING
- C1.1 - STORMWATER CALCULATIONS

PREPARED BY

SCATLIFF + MILLER + MURRAY
visionary urban design + landscapes



CONTEXT PLAN

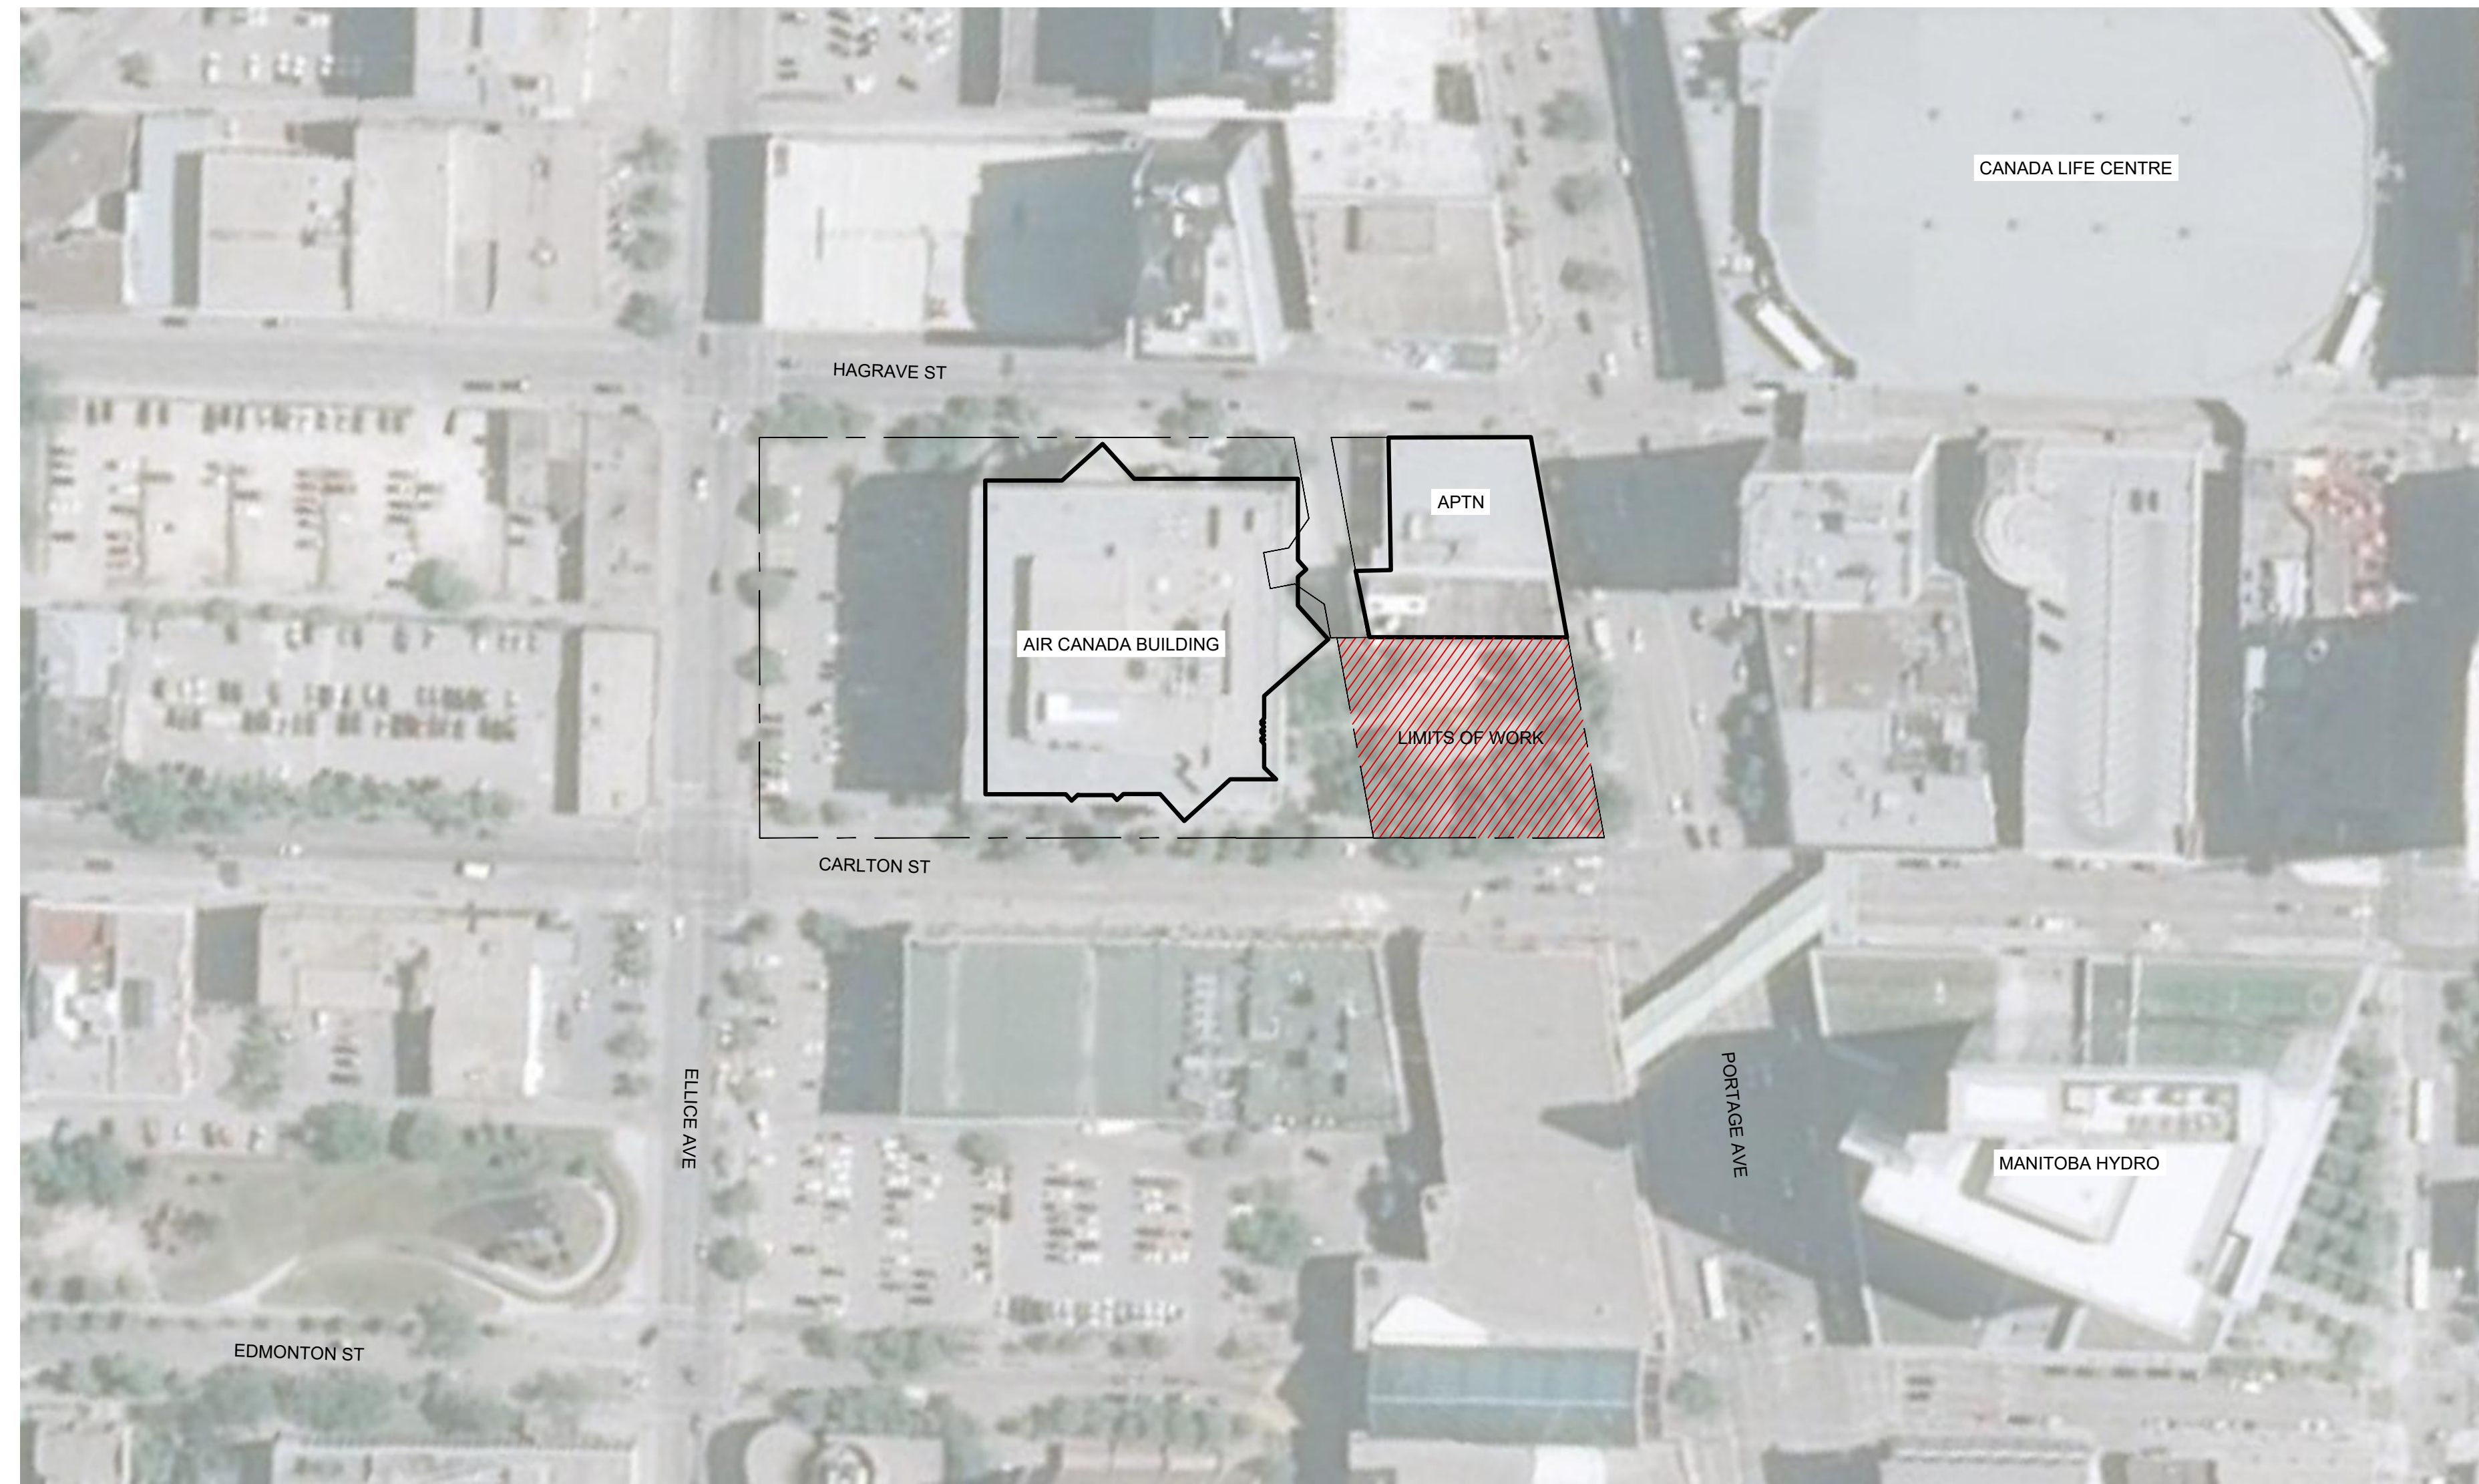

PERSPECTIVE RENDERING



NOTES:

1	24 / 02 / 12	ISSUED FOR TENDER	CO
---	--------------	-------------------	----

REV	YY / MM / DD	DESCRIPTION	BY
-----	--------------	-------------	----

A. SECTION LETTER OR DETAIL NUMBER.	PROFESSIONAL'S SEAL
B. DRAWING WHERE SECTION OR DETAIL IS DRAWN.	
OR	
DRAWING WHERE SECTION OR DETAIL IS INDICATED.	
--- SECTION OR DETAIL SHOWN ON SAME DRAWING.	
(A B) (A ---)	

SCATLIFF + MILLER + MURRAY
visionary urban design + landscapes

CONSULTANT FILE NAME AIR CANADA PARK - DD_L0.0

CLIENT **CITY OF WINNIPEG**
PLANNING, PROPERTY & DEVELOPMENT



CITY DRAWING NUMBER	SHEET	OF
	1	28

COVER PAGE

DESIGN	DRAWN	DATE - Y / M / D	SCALE
CO/YK	YK/SM	24 / 02 / 12	AS SHOWN
CHECKED	APPROVED	PROJECT No.	DRAWING No.
CO	CO	23-0107-002	L0.0