
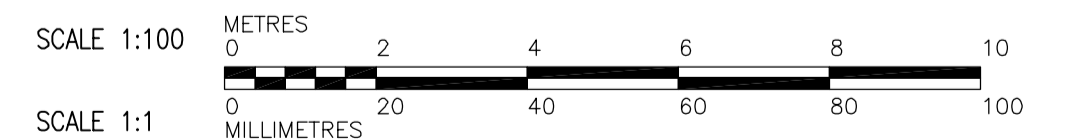


THIRD FLOOR PLAN AT EL 245.000  
1:100

**NOTES:**  
1. DESIGN LIVE LOAD IS 14.4 kPa

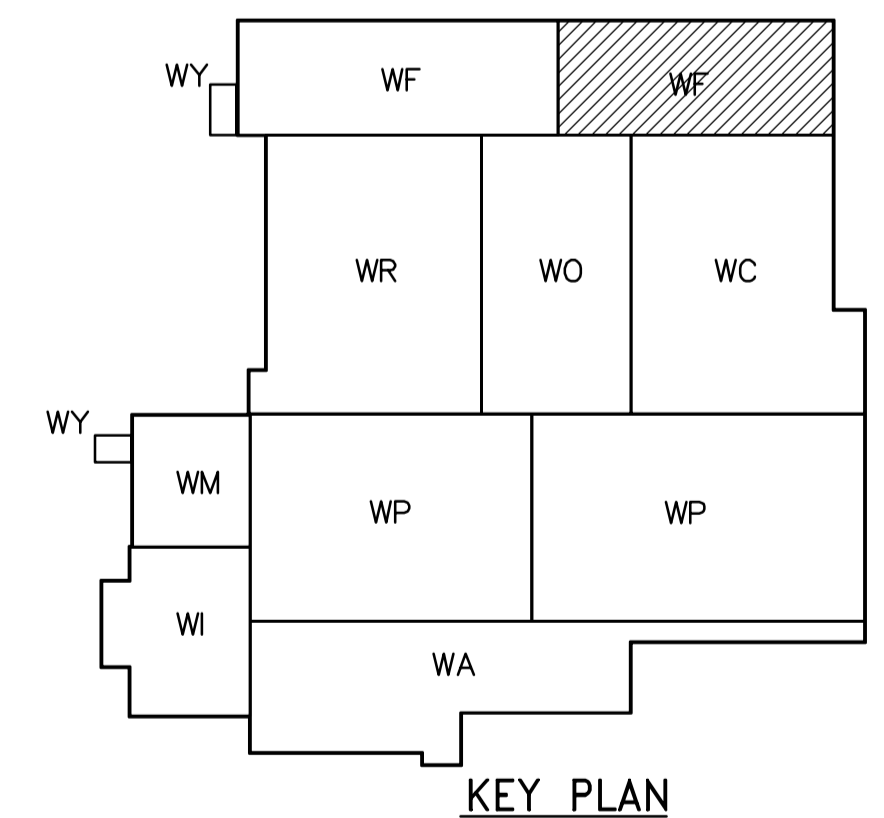

 <b>APEGN</b> Certificate of Authorization CH2M HILL Canada Ltd. No. 1441 Expiry: April 30, 2006	B.M. ELEV.	 Frederickson Cooper ARCHITECTS	 A Tyco International Ltd. Company	ENGINEER'S SEAL	 <b>THE CITY OF WINNIPEG</b> WATER AND WASTE DEPARTMENT ENGINEERING DIVISION WATER TREATMENT PLANT FILTRATION FOUNDATIONS AND CONCRETE STRUCTURES STRUCTURAL FILTRATION AREA 2 THIRD FLOOR REINFORCING PLAN	CITY FILE NUMBER		
				DESIGNED BY KA		CHECKED BY AP	ORIGINAL SIGNED BY D. KRUGER	SHEET OF
				DRAWN BY PM		APPROVED BY DJT	2006/02/06	CITY DRAWING NUMBER
				SCALE: 1:100		RELEASED FOR CONSTRUCTION BY: R. SOROKOWSKI	CONSULTANT DRAWING NO. WF-S0136	<b>1-060F-A-8036-001-0D</b>
NO. REVISIONS	DATE	BY	DATE	2005/08/10	DATE	2006/02/08		