







M SECTION - OZONE COOLING WATER RETURN
WP-M9105 1:50

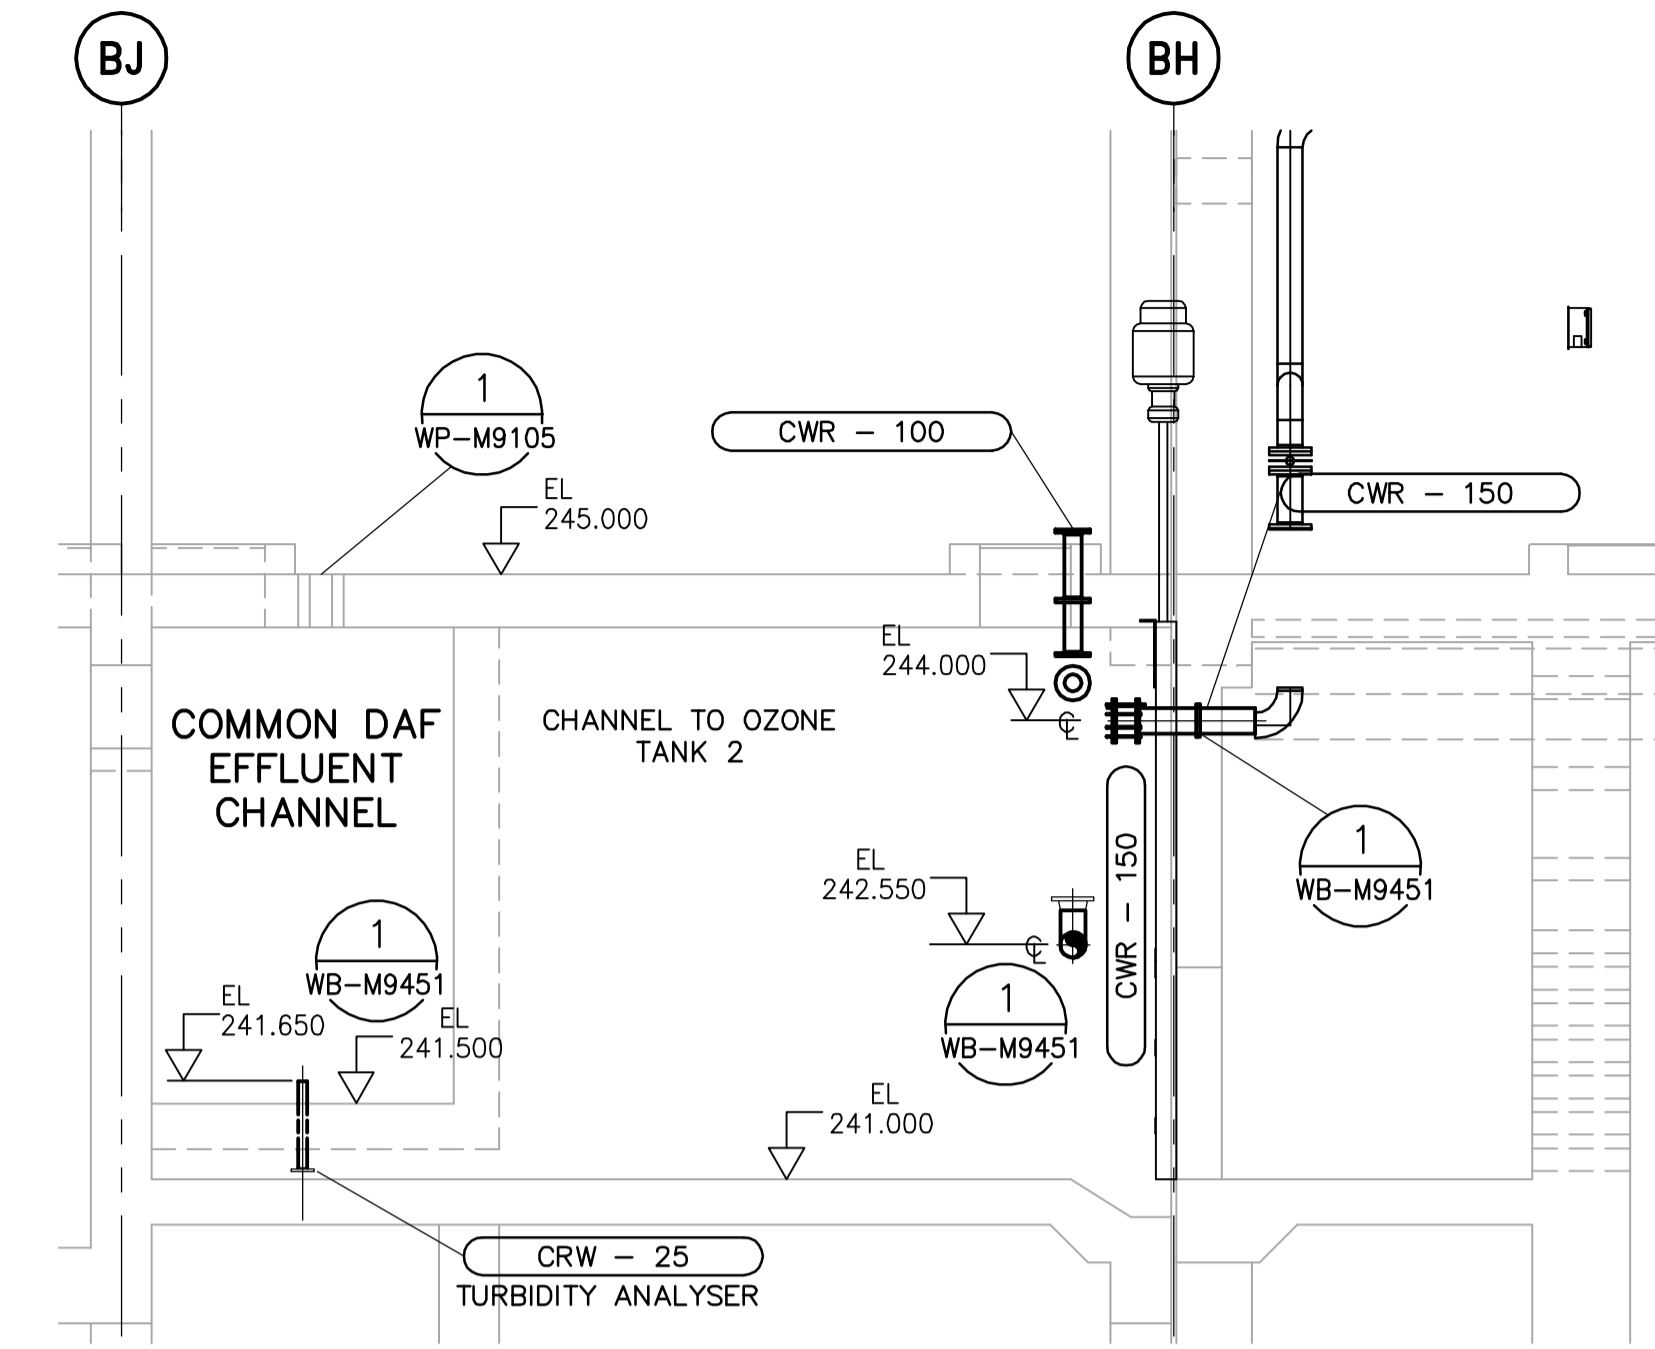

N SECTION - OZONE COOLING WATER RETURN
WP-M9105 1:50

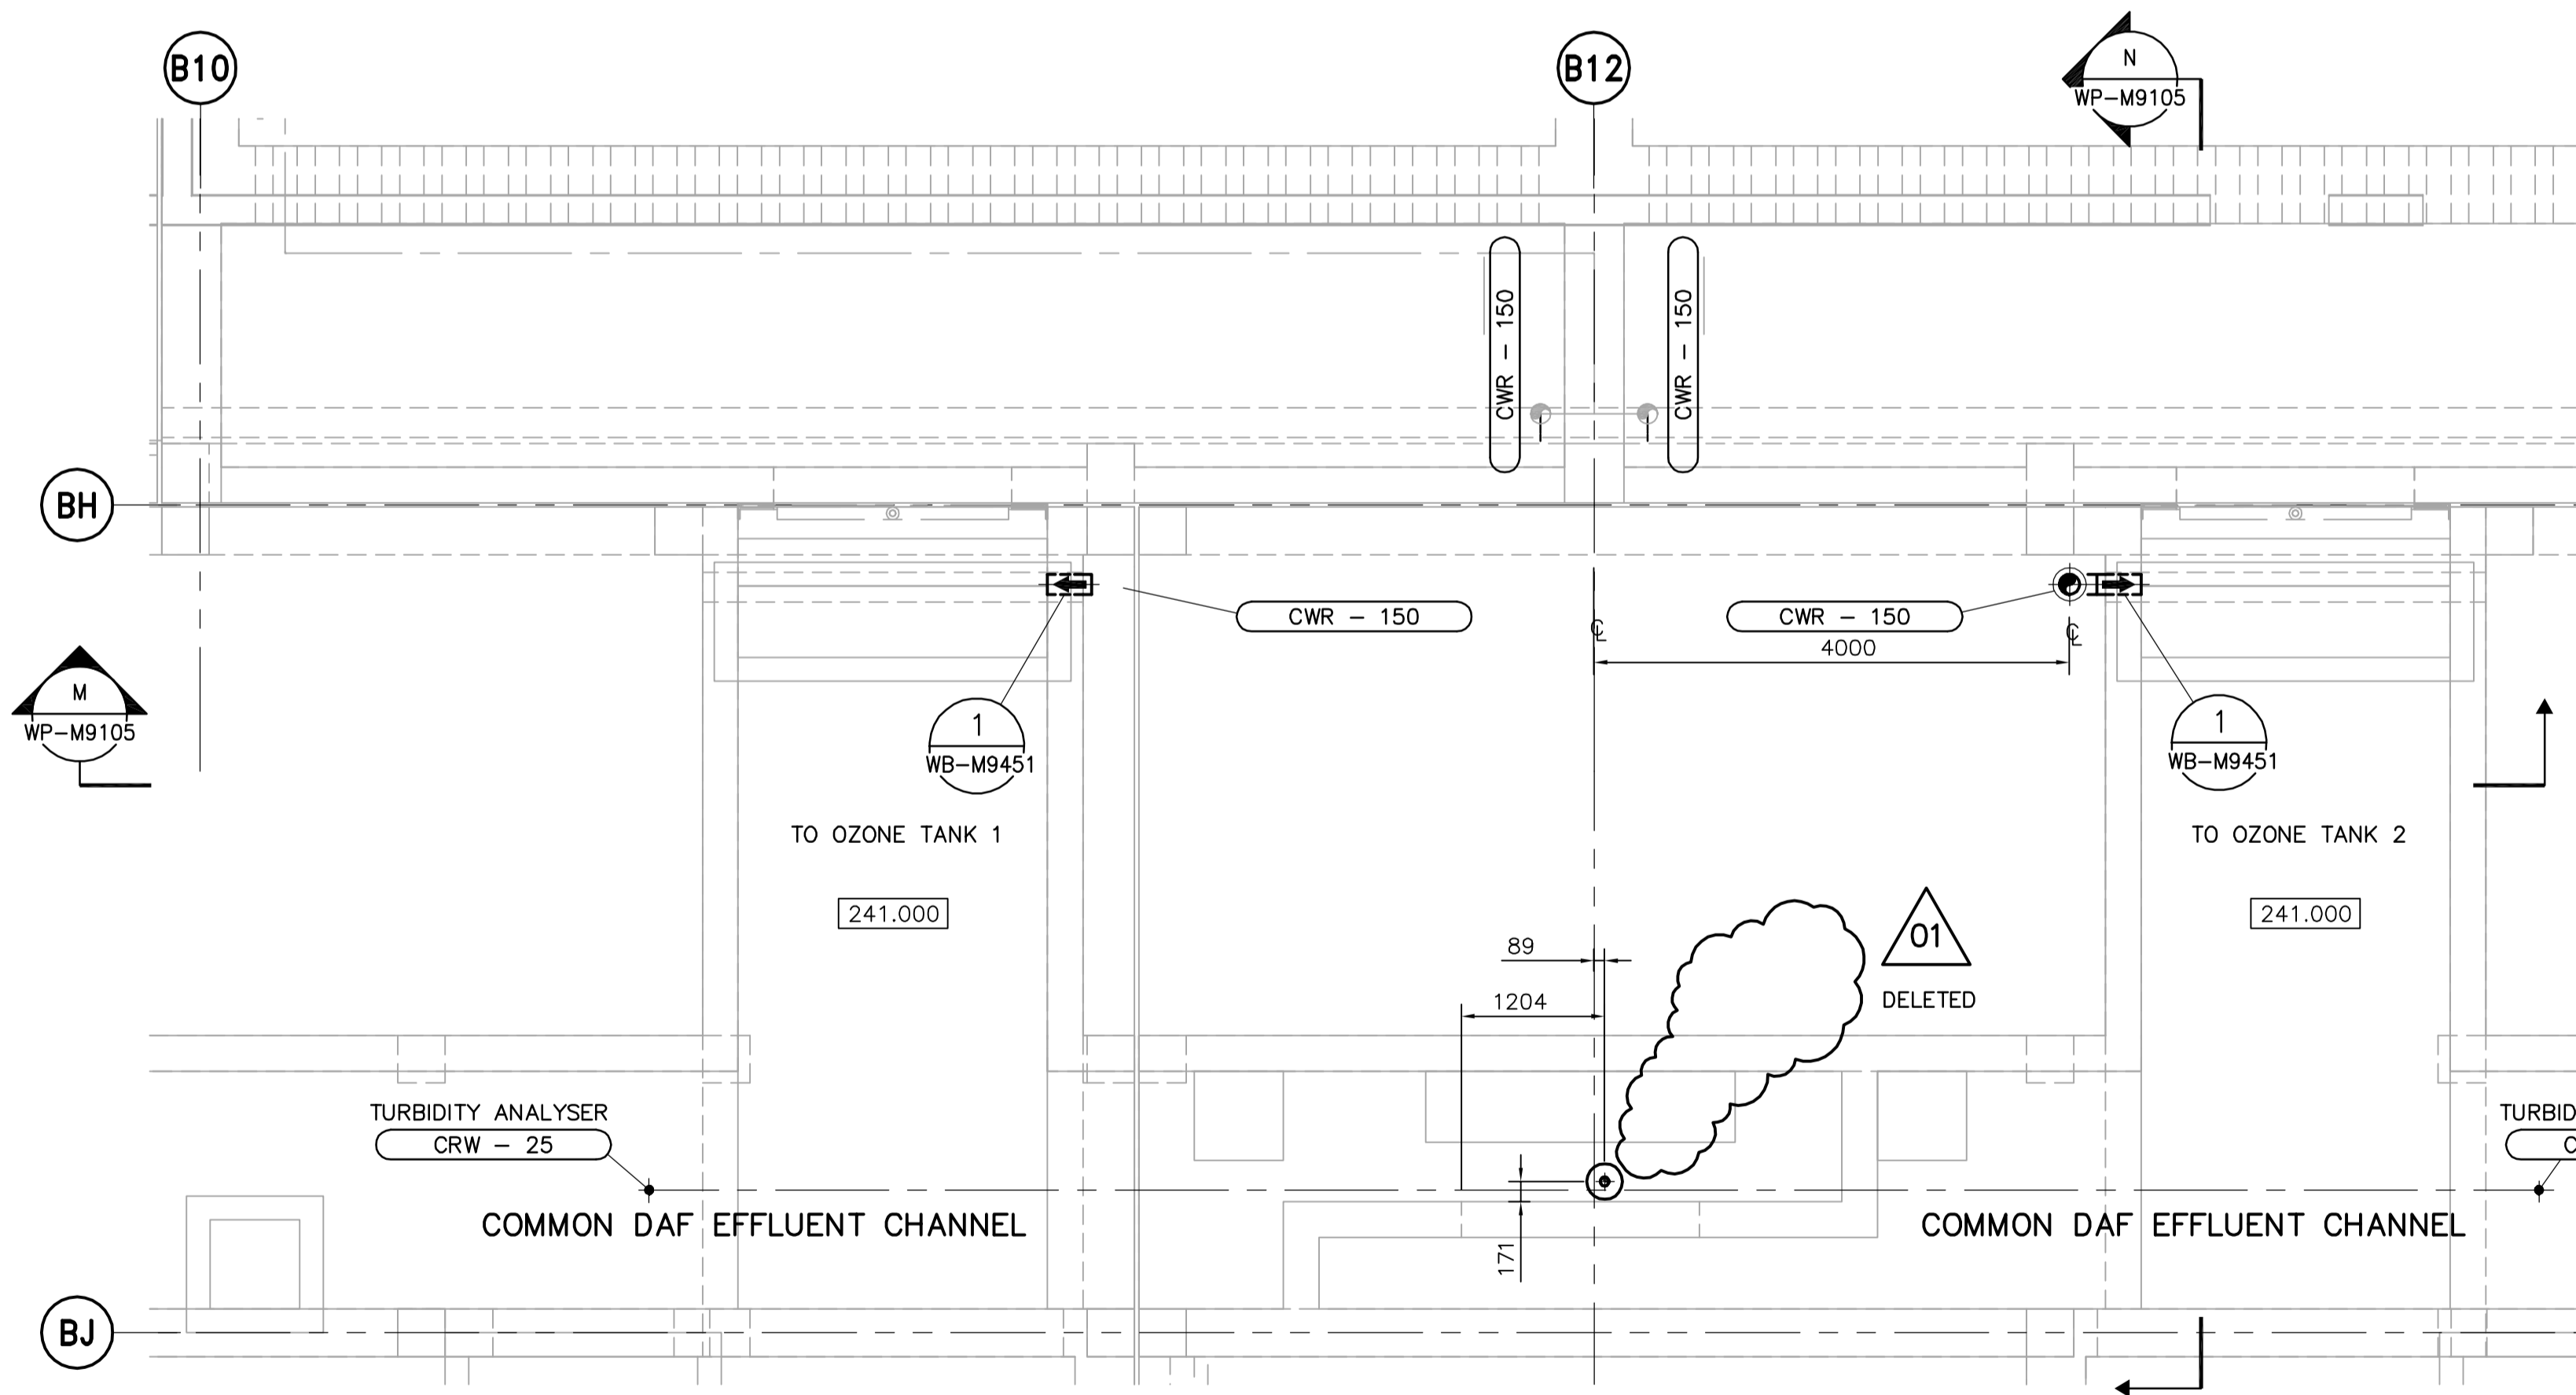

21 THIRD FLOOR PLAN - OZONE COOLING WATER RETURN
WP-M9105 1:50

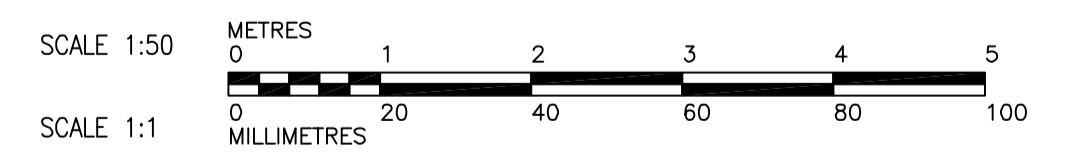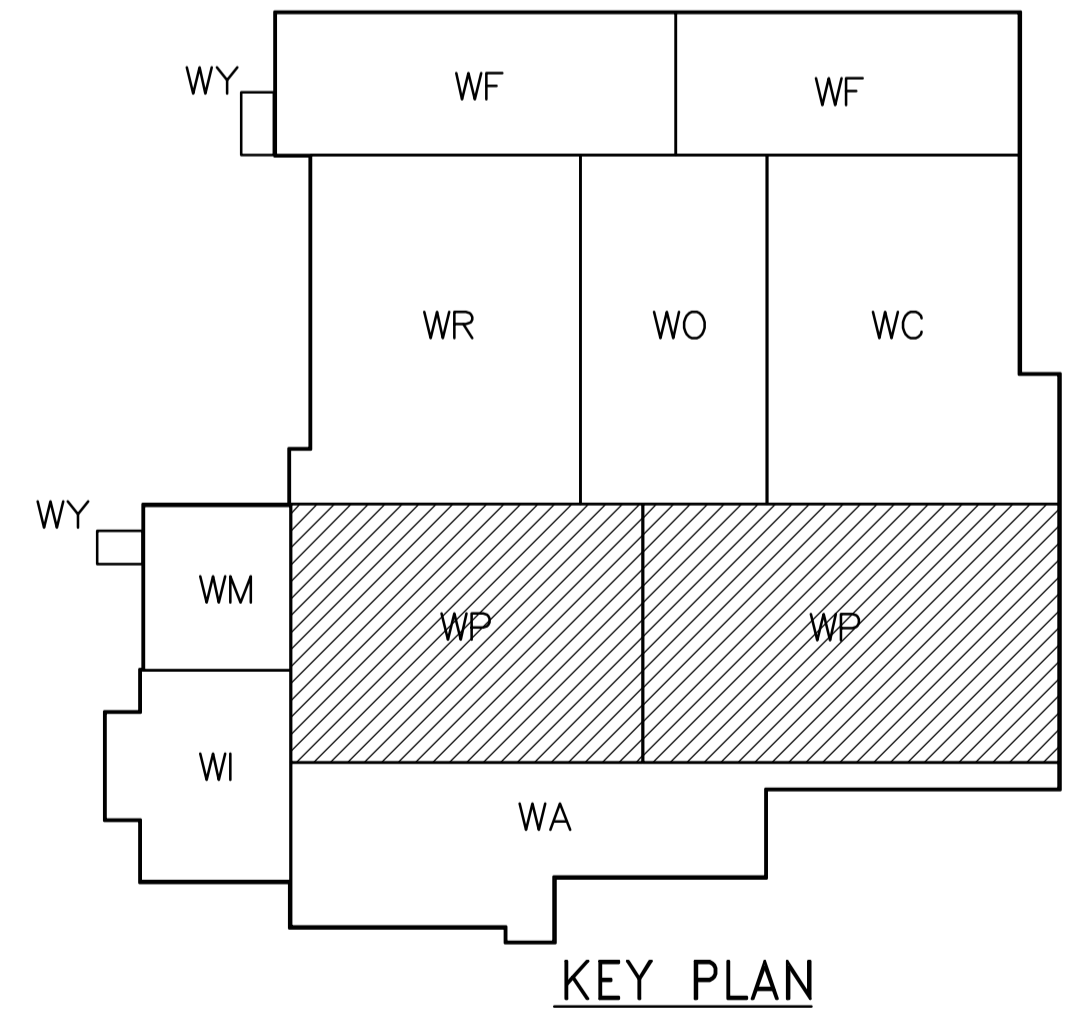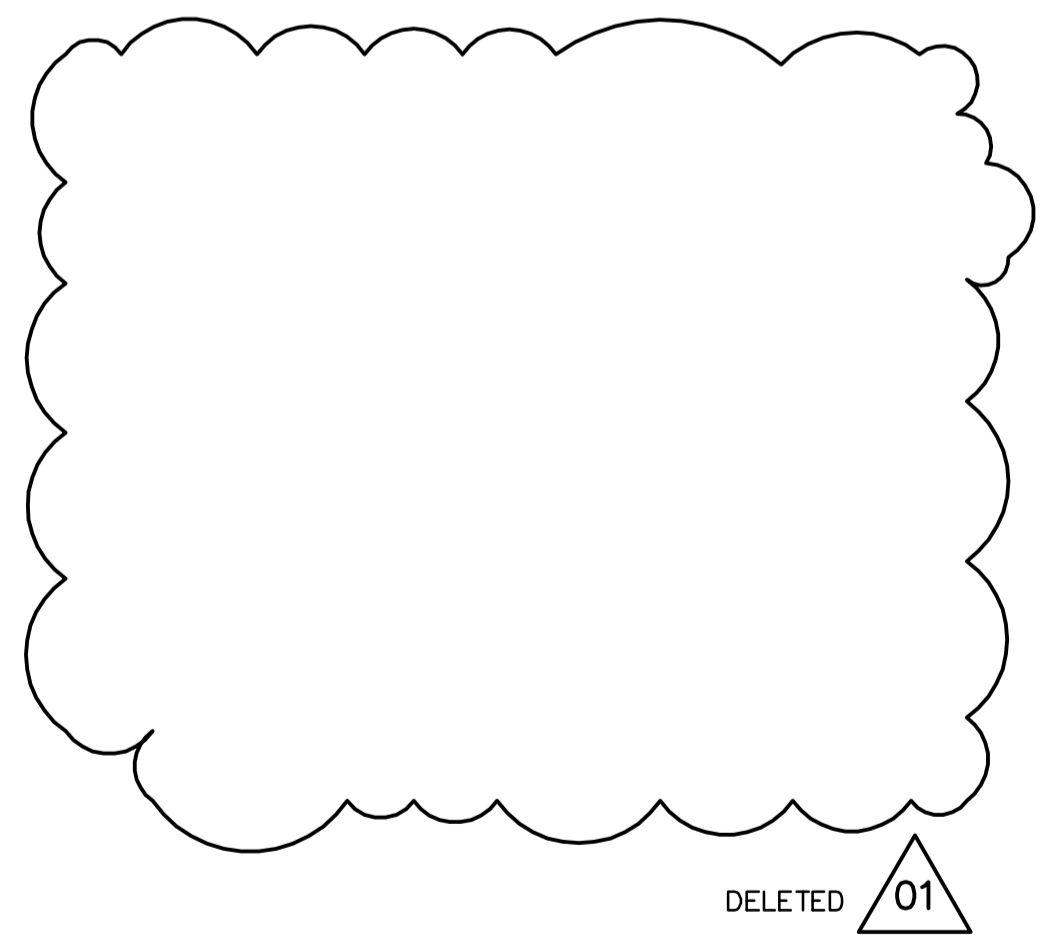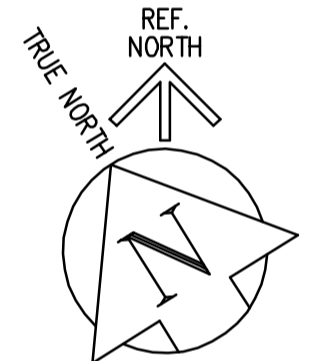

<p>Certificate of Authorization Earth Tech Canada Inc. No. 730 Expiry: April 30, 2006</p>			ENGINEER'S SEAL ORIGINAL SIGNED BY S.R. BILEVICIUS 2006/02/07		<p>THE CITY OF WINNIPEG WATER AND WASTE DEPARTMENT ENGINEERING DIVISION</p>	
	DESIGNED BY: KAS DRAWN BY: PL SCALE: AS SHOWN		CHECKED BY: SRB APPROVED BY: DJT RELEASED FOR CONSTRUCTION BY: R. SOROKOWSKI			CITY FILE NUMBER SHEET OF CITY DRAWING NUMBER 1-0601P-A-M9105-001-01D
	B.M. ELEV. 01 583-2005 ADDENDUM 3 06/03/10 JBC 00 ISSUED FOR TENDER 06/02/03 PL		CONSULTANT DRAWING NO. WP-M9105			
	NO. REVISIONS DATE BY		DATE 2005/10/24 DATE 2006/02/07			WATER TREATMENT PLANT FLOCCULATION AND DAF FOUNDATIONS AND CONCRETE STRUCTURES PIPE EMBEDS THIRD FLOOR PLAN AND SECTIONS OZONE COOLING WATER RETURN