



- NOTES:**
- SEE DWGS WP-S0111 TO WP-S0132 FOR SLAB REINFORCING AND WALL ADDITIONAL REBARS, UNO.
 - SEE DWG WP-S0515 FOR BEAM AND COLUMN SCHEDULES.

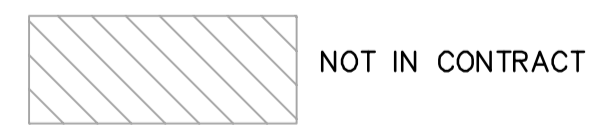

E SECTION
WP-F0105 1:50

WP-S0121, WP-S0131
WP-S0141, WP-S0146

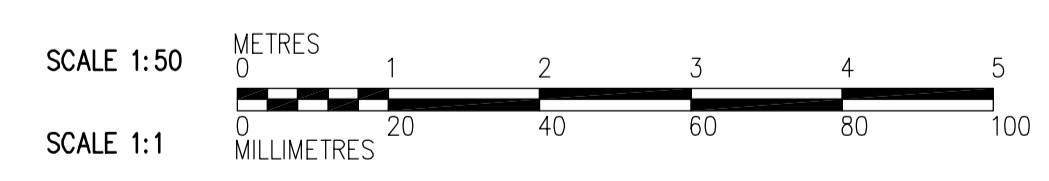

 APEGN Certificate of Authorization CH2M HILL Canada Ltd. No. 1441 Expiry: April 30, 2006	B.M. ELEV.	 Frederickson Cooper ARCHITECTS	 A Terra International Ltd. Company	ENGINEER'S SEAL	 THE CITY OF WINNIPEG WATER AND WASTE DEPARTMENT ENGINEERING DIVISION WATER TREATMENT PLANT FLOCCULATION AND DAF FOUNDATIONS AND CONCRETE STRUCTURES STRUCTURAL FLOC/DAF AREA 1 SECTION	CITY FILE NUMBER
	DESIGNED BY: RZ			CHECKED BY: AP		ORIGINAL SIGNED BY: D. KRUGER
	DRAWN BY: RL	APPROVED BY: DJT	2006/02/06	CITY DRAWING NUMBER		
	SCALE: 1:50	RELEASED FOR CONSTRUCTION BY: R. SOROKOWSKI	CONSULTANT DRAWING NO. WP-S0207	1-060P-A-0207-001-0D		
NO. REVISIONS	DATE BY	DATE	DATE			