
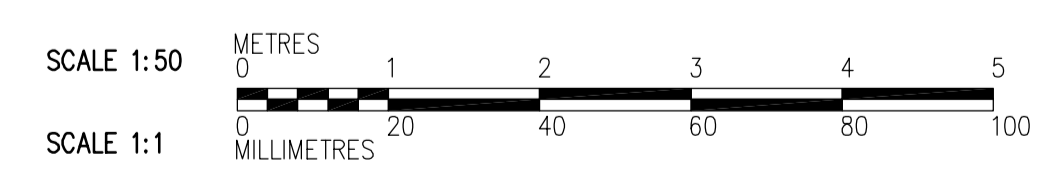


H SECTION
 WP-F0105 1:50
 WP-S0121, WP-S0131
 WP-S0141, WP-S0146

- NOTES:**
- SEE DWGS WP-S0111 TO WP-S0132 FOR SLAB REINFORCING AND WALL ADDITIONAL REBARS, UNO.
 - SEE DWG WP-S0515 FOR BEAM AND COLUMN SCHEDULES.

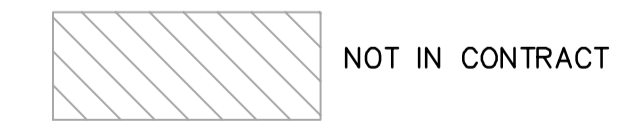

 Certificate of Authorization CH2M HILL Canada Ltd. No. 1441 Expiry: April 30, 2006	B.M. ELEV.	 Frederickson Cooper ARCHITECTS	 A Terra International Ltd. Company	ENGINEER'S SEAL	 THE CITY OF WINNIPEG WATER AND WASTE DEPARTMENT ENGINEERING DIVISION WATER TREATMENT PLANT FLOCCULATION AND DAF FOUNDATIONS AND CONCRETE STRUCTURES STRUCTURAL FLOC/DAF AREA 1 SECTION	CITY FILE NUMBER
	DESIGNED BY: RZ DRAWN BY: RL			CHECKED BY: AP APPROVED BY: DJT		ORIGINAL SIGNED BY: D. KRUGER 2006/02/06
	SCALE: 1:50	RELEASED FOR CONSTRUCTION BY: R. SOROKOWSKI	CONSULTANT DRAWING NO. WP-S0213	CITY DRAWING NUMBER 1-060P-A-8023-001-0D		
	NO. REVISIONS: 01 DATE: 06/03/10 BY: RZ	DATE: 2005/07/27 DATE: 2006/02/08				