



- NOTES:**
- DESIGN LIVE LOAD IS 14.4 kPa.
 - FOR BEAM AND COLUMN SCHEDULE SEE DWG WI-S0515.

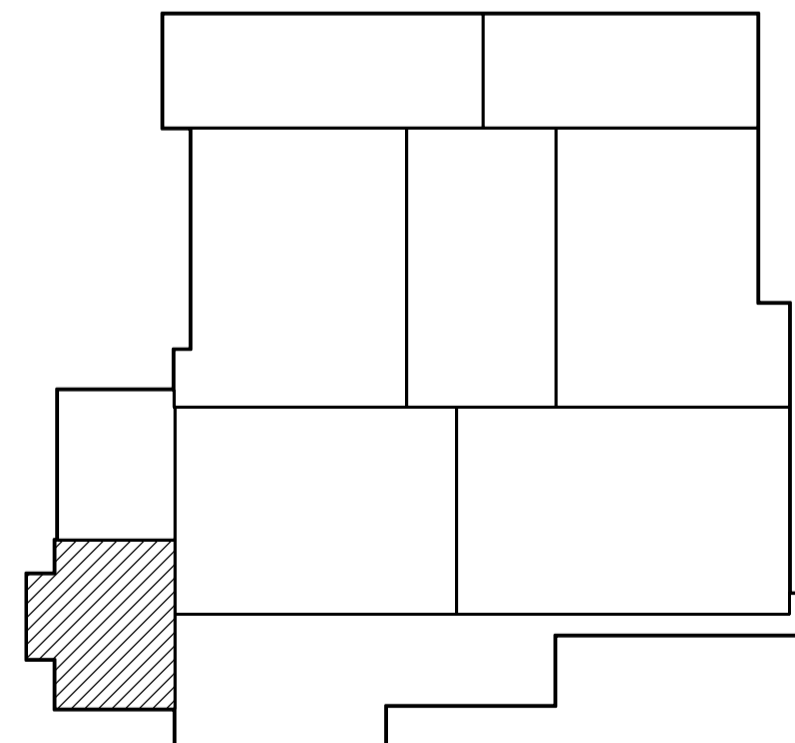

THIRD FLOOR PLAN
1:100

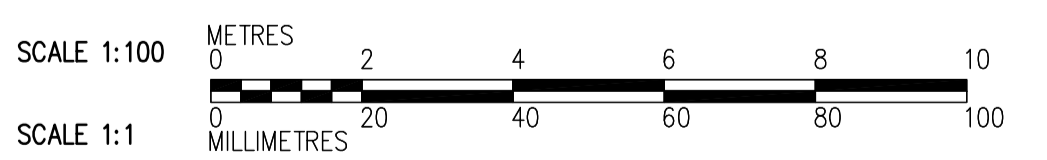

<p>Certificate of Authorization CH2M Hill Canada Limited (ON) No. 1441 Expiry: April 30, 2006</p>	<p>Frederickson Cooper ARCHITECTS</p>	<p>A Tyco International Ltd. Company</p>	<p>ENGINEER'S SEAL</p>	<p>THE CITY OF WINNIPEG WATER AND WASTE DEPARTMENT ENGINEERING DIVISION</p>	
	<p>DESIGNED BY: EL</p> <p>DRAWN BY: RL</p> <p>SCALE: 1:100</p>	<p>CHECKED BY: AP</p> <p>APPROVED BY:</p> <p>RELEASED FOR CONSTRUCTION BY:</p>	<p>CONSULTANT DRAWING NO. WI-S0131</p>		<p>WATER TREATMENT PLANT</p> <p>FOUNDATIONS AND CONCRETE STRUCTURES 1</p>
	<p>NO. REVISIONS</p> <p>DATE</p> <p>BY</p>	<p>DATE: 2005/07/08</p> <p>DATE</p>	<p>DATE</p>		<p>CITY FILE NUMBER</p> <p>SHEET OF</p> <p>CITY DRAWING NUMBER 1-0601-A-80131-001-01D</p>
	<p>B.M. ELEV.</p>	<p>NO.</p> <p>DATE</p> <p>BY</p>	<p>DATE</p>		<p>STRUCTURAL RAW WATER PUMP STATION AREA THIRD FLOOR PLAN</p>