



NOTE:
 1. FOR BEAM SCHEDULE SEE DWG WI-S0515.
 2. PROVIDE DOWELS FOR PARAPET AROUND PERIMETER OF ROOF SEE .
 NOT IN CONTRACT

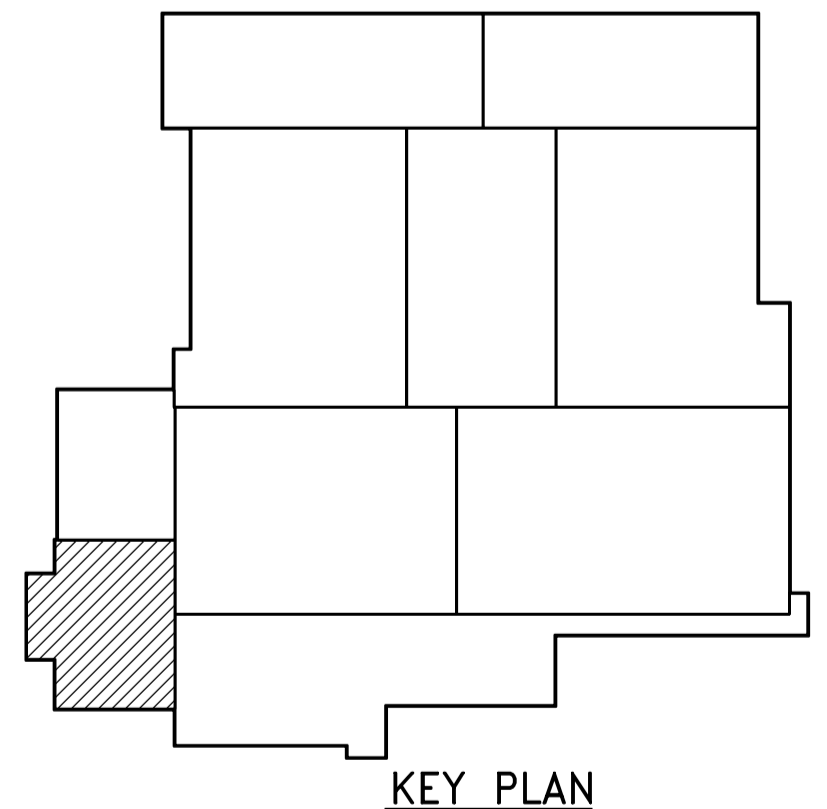

ROOF FRAMING PLAN
1:100

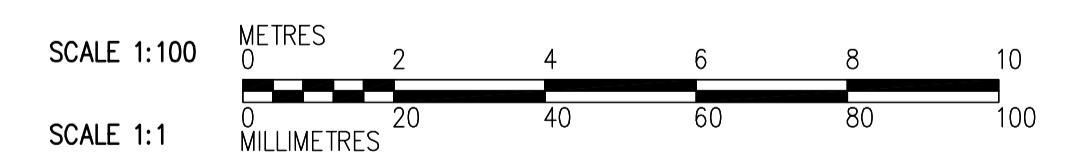

 Certificate of Authorization CH2M Hill Canada Limited (ON) No. 1441 Expiry: April 30, 2006	 Frederickson Cooper ARCHITECTS	 A Tyco International Ltd. Company	ENGINEER'S SEAL CONSULTANT DRAWING NO. WI-S0141	THE CITY OF WINNIPEG WATER AND WASTE DEPARTMENT ENGINEERING DIVISION WATER TREATMENT PLANT FOUNDATIONS AND CONCRETE STRUCTURES 1 STRUCTURAL RAW WATER PUMP STATION AREA ROOF FRAMING PLAN	CITY FILE NUMBER SHEET OF CITY DRAWING NUMBER 1-0601-A-8041-001-01D
	DESIGNED BY: EL CHECKED BY: AP DRAWN BY: RL APPROVED BY: SCALE: 1:100 RELEASED FOR CONSTRUCTION BY: DATE: 2005/07/08				
	B.M. ELEV. NO. REVISIONS DATE BY				