


SHEET: 66303D-09 (17/2005)

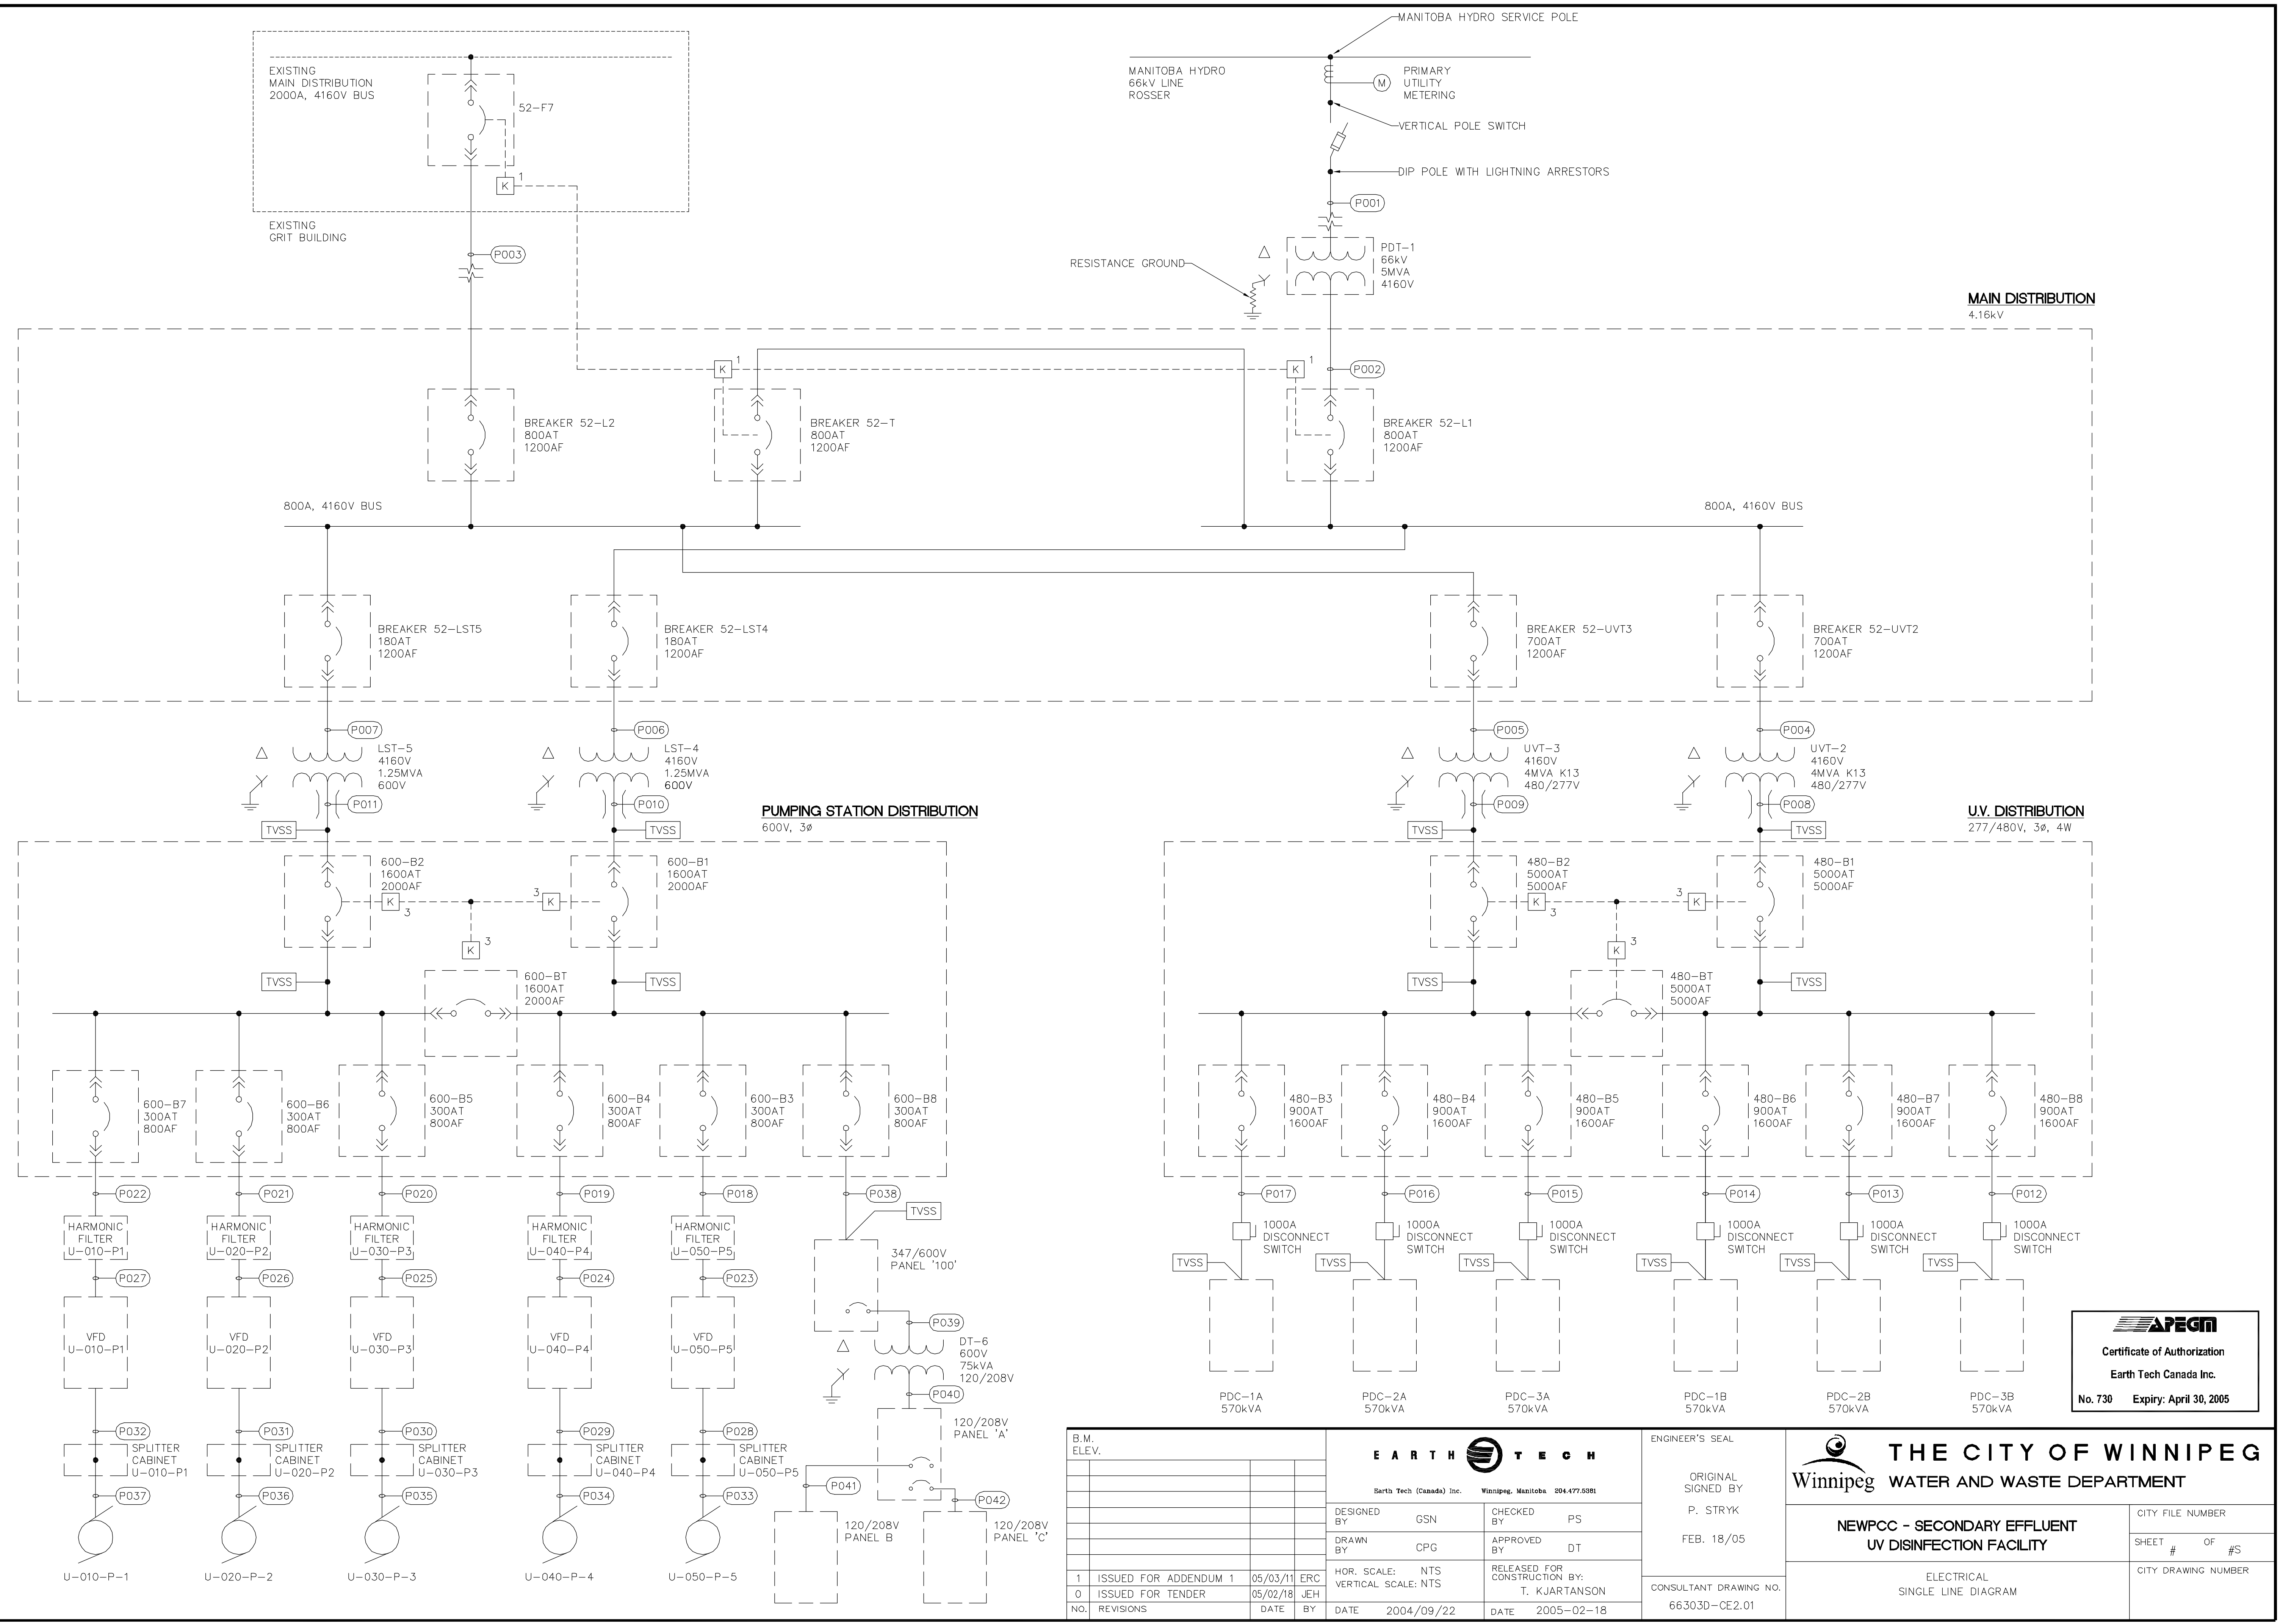

APEGM
 Certificate of Authorization
 Earth Tech Canada Inc.
 No. 730 Expiry: April 30, 2005

B. M. ELEV.		EARTH TECH Earth Tech (Canada) Inc. Winnipeg, Manitoba 204-477-5081		ENGINEER'S SEAL ORIGINAL SIGNED BY P. STRYK FEB. 18/05		THE CITY OF WINNIPEG Winnipeg WATER AND WASTE DEPARTMENT	
DESIGNED BY: GSN		CHECKED BY: PS		CONSULTANT DRAWING NO. 66303D-CE2.01		CITY FILE NUMBER	
DRAWN BY: CPG		APPROVED BY: DT				SHEET # OF #S	
HOR. SCALE: NTS		RELEASED FOR CONSTRUCTION BY: T. KJAR TANSON		ELECTRICAL SINGLE LINE DIAGRAM		CITY DRAWING NUMBER	
1 ISSUED FOR ADDENDUM 1 05/03/11 ERC		2004/09/22		2005-02-18			
0 ISSUED FOR TENDER 05/02/18 JEH							
NO. REVISIONS		DATE		DATE			