



**PARTIAL MAIN FLOOR PLAN**  
SCALE: 1:50

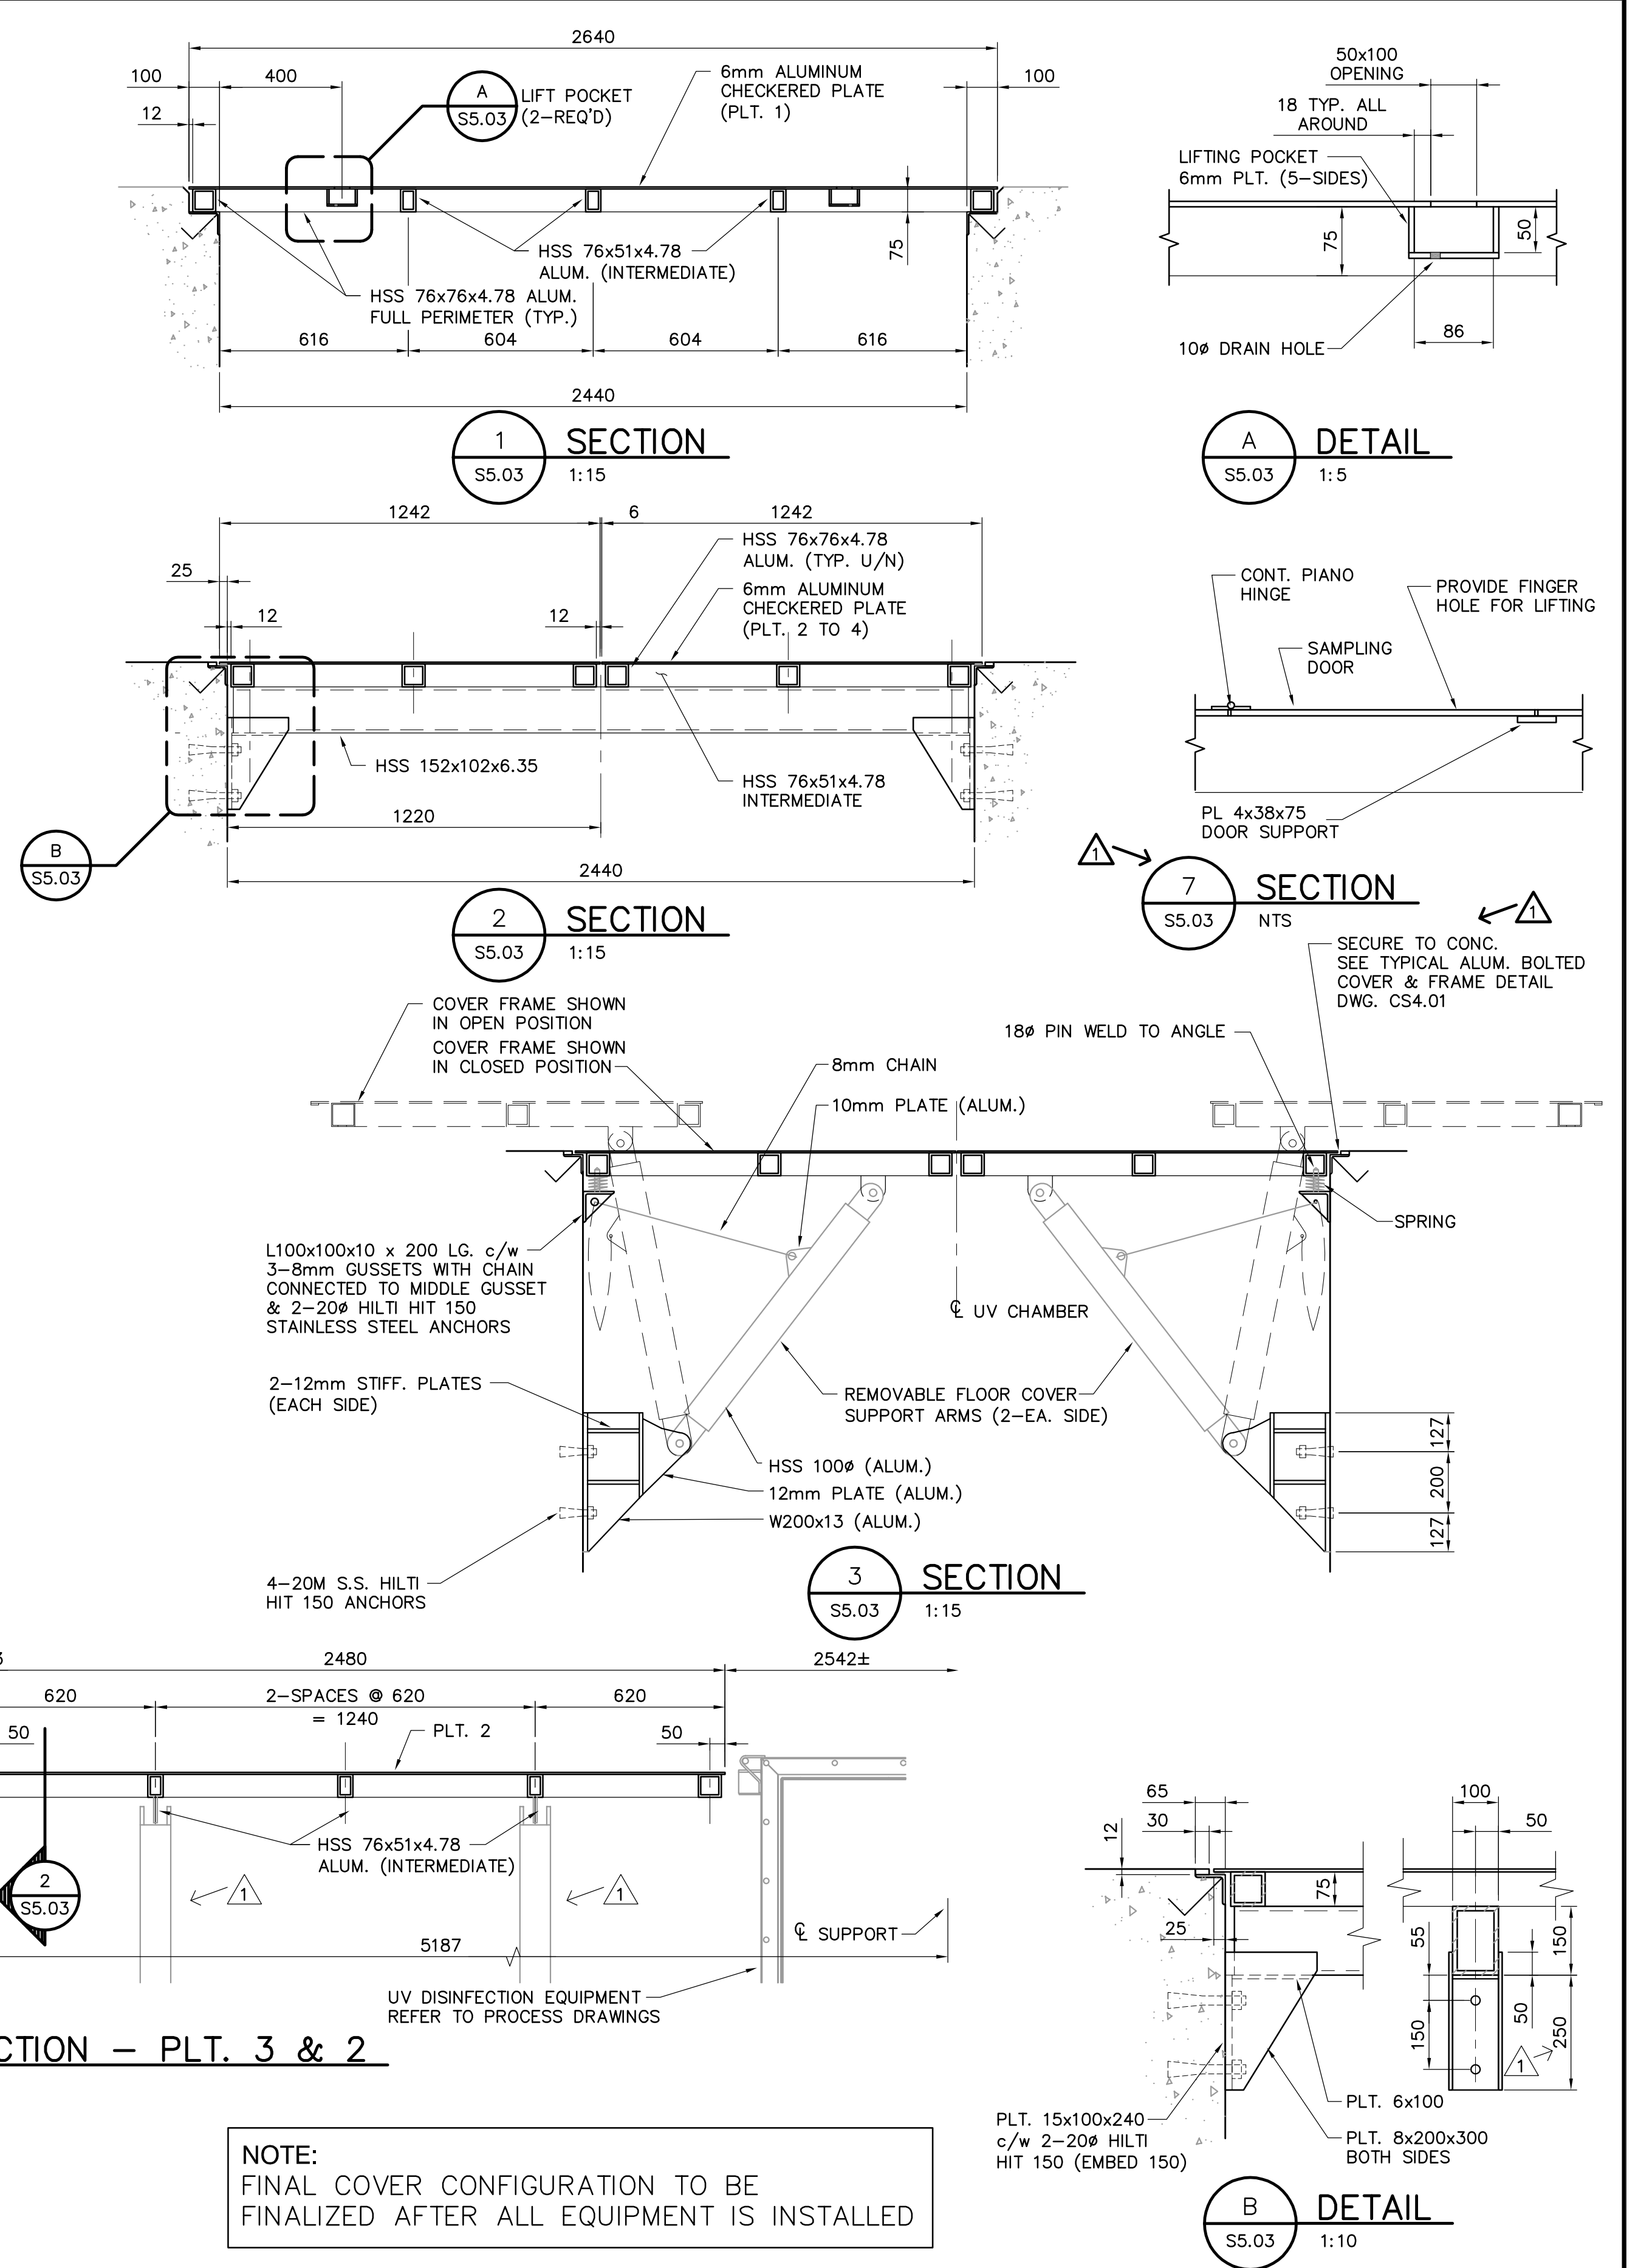

**NOTE:**  
FINAL COVER CONFIGURATION TO BE  
FINALIZED AFTER ALL EQUIPMENT IS INSTALLED

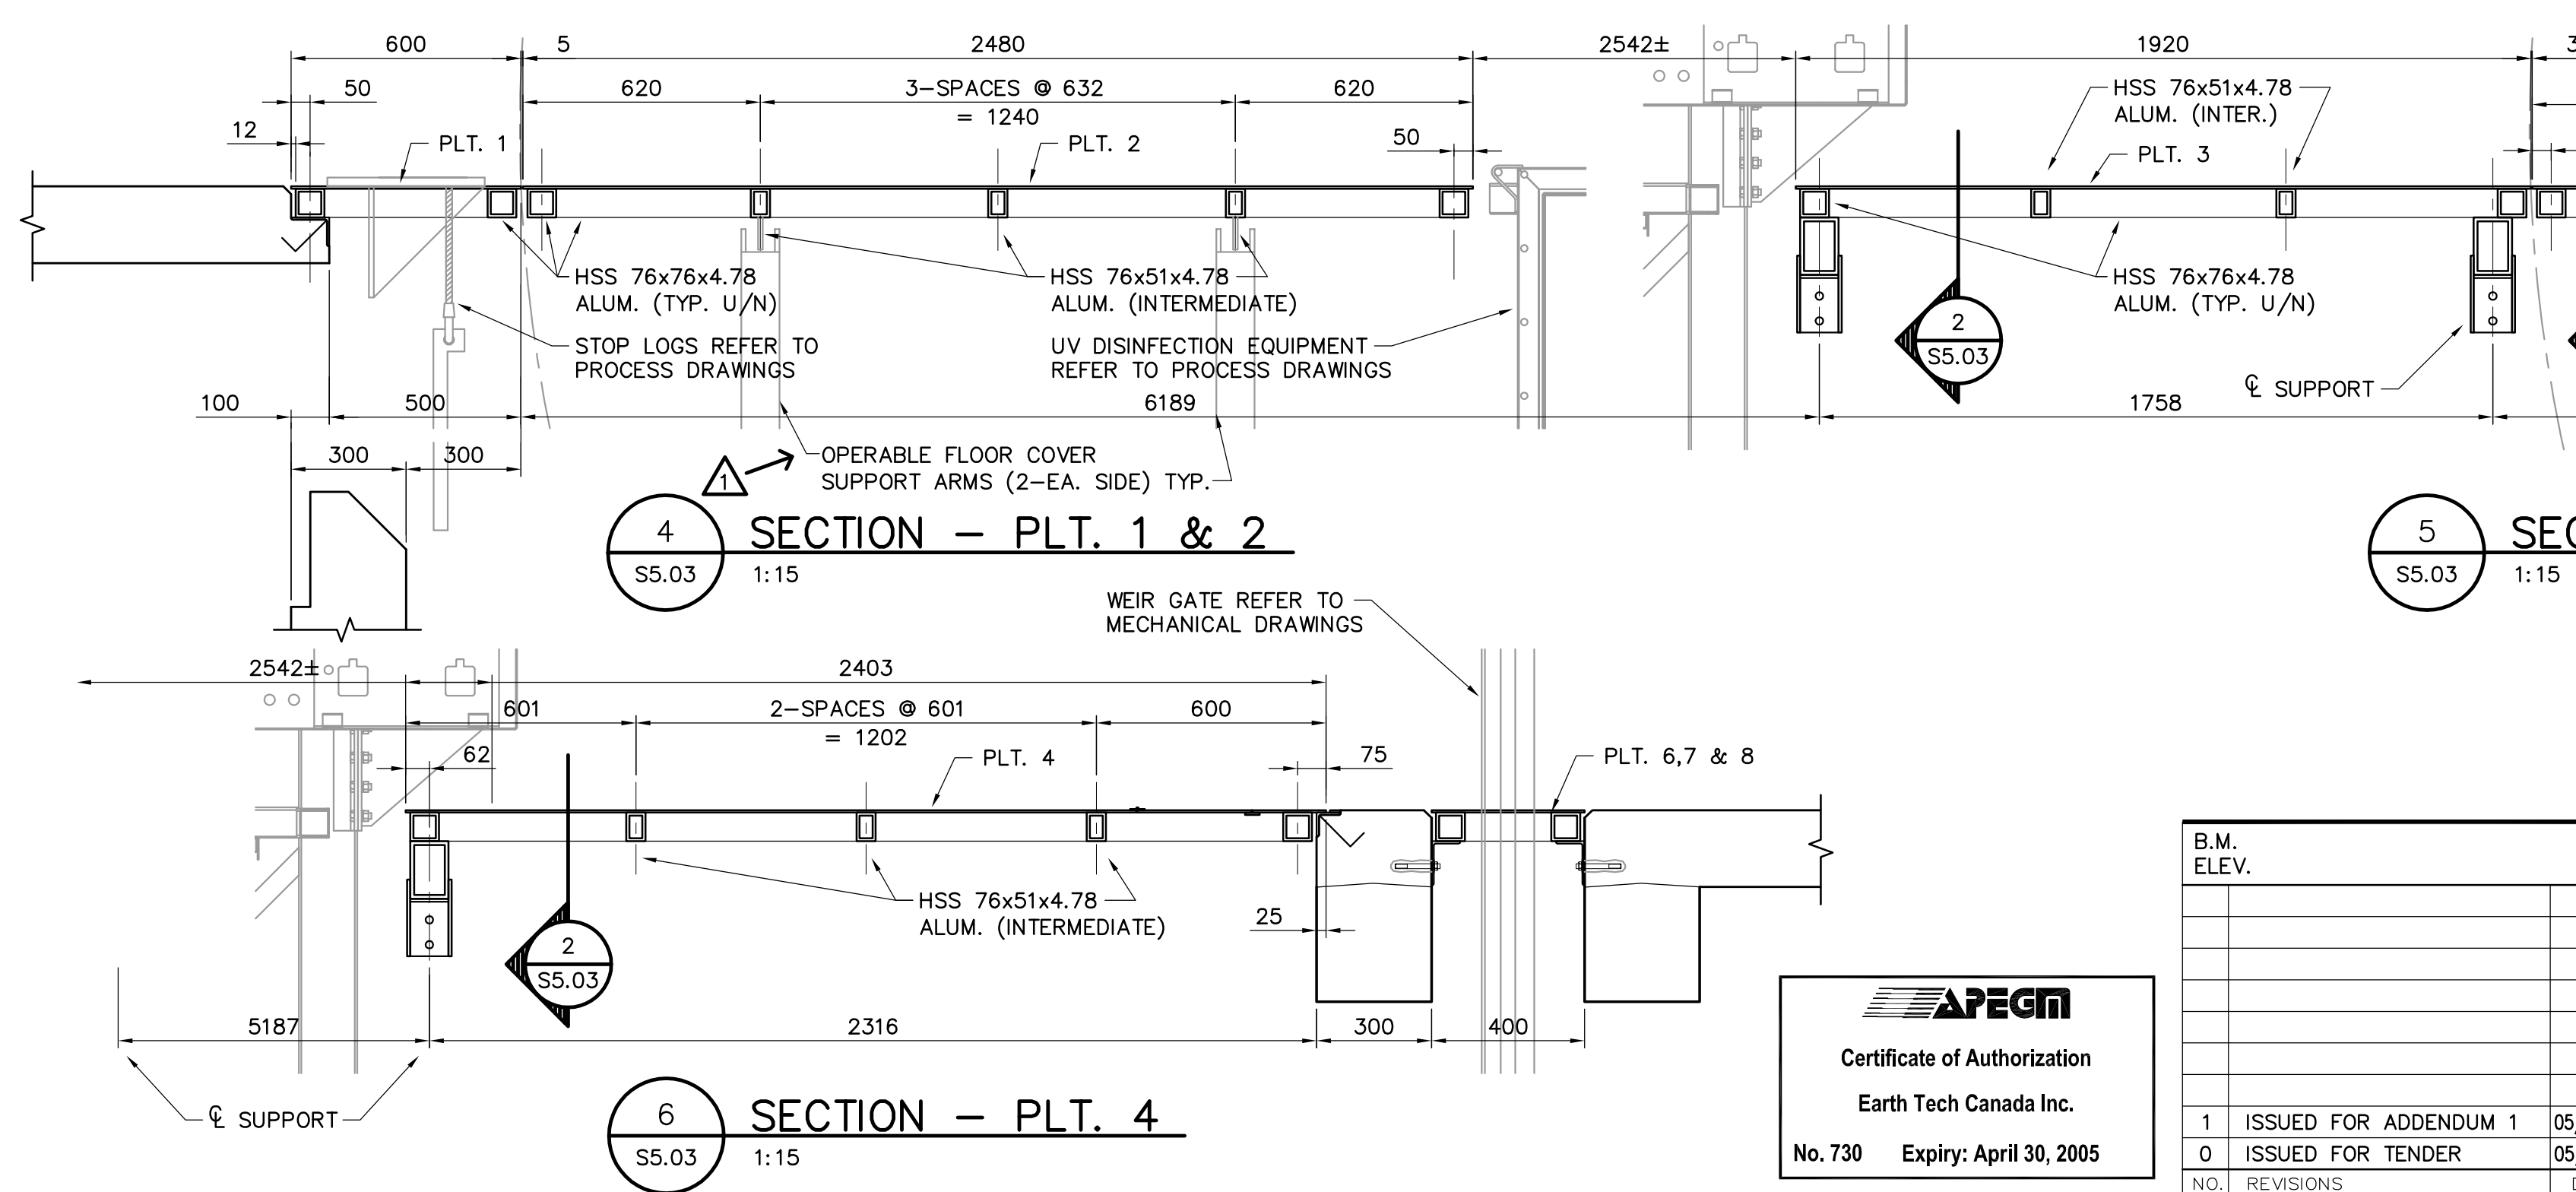

B.M. ELEV.	<b>EARTH TECH</b> Earth Tech (Canada) Inc. Winnipeg, Manitoba 204-477-5381		ENGINEER'S SEAL ORIGINAL SIGNED BY R.B. ERIC FEB. 18/05	<b>THE CITY OF WINNIPEG</b> Winnipeg WATER AND WASTE DEPARTMENT	
DESIGNED BY RE, MK	CHECKED BY GGP	DRAWN BY CMS	APPROVED BY DT	NEWPCC - SECONDARY EFFLUENT UV DISINFECTION FACILITY	
HOR. SCALE: AS NOTED	RELEASED FOR CONSTRUCTION BY: T. KJARTANSON	CONSULTANT DRAWING NO. 663030-CS.03		CITY FILE NUMBER SHEET 18 OF 19	
0 ISSUED FOR TENDER 05/02/18 JEH	DATE 2005/01/31	DATE 2005-02-18	STRUCTURAL UV CHAMBER ACCESS COVERS PLAN, SECTIONS AND DETAILS		CITY DRAWING NUMBER