




4 SOUTH ELEVATION
WJ-B0403 1:30

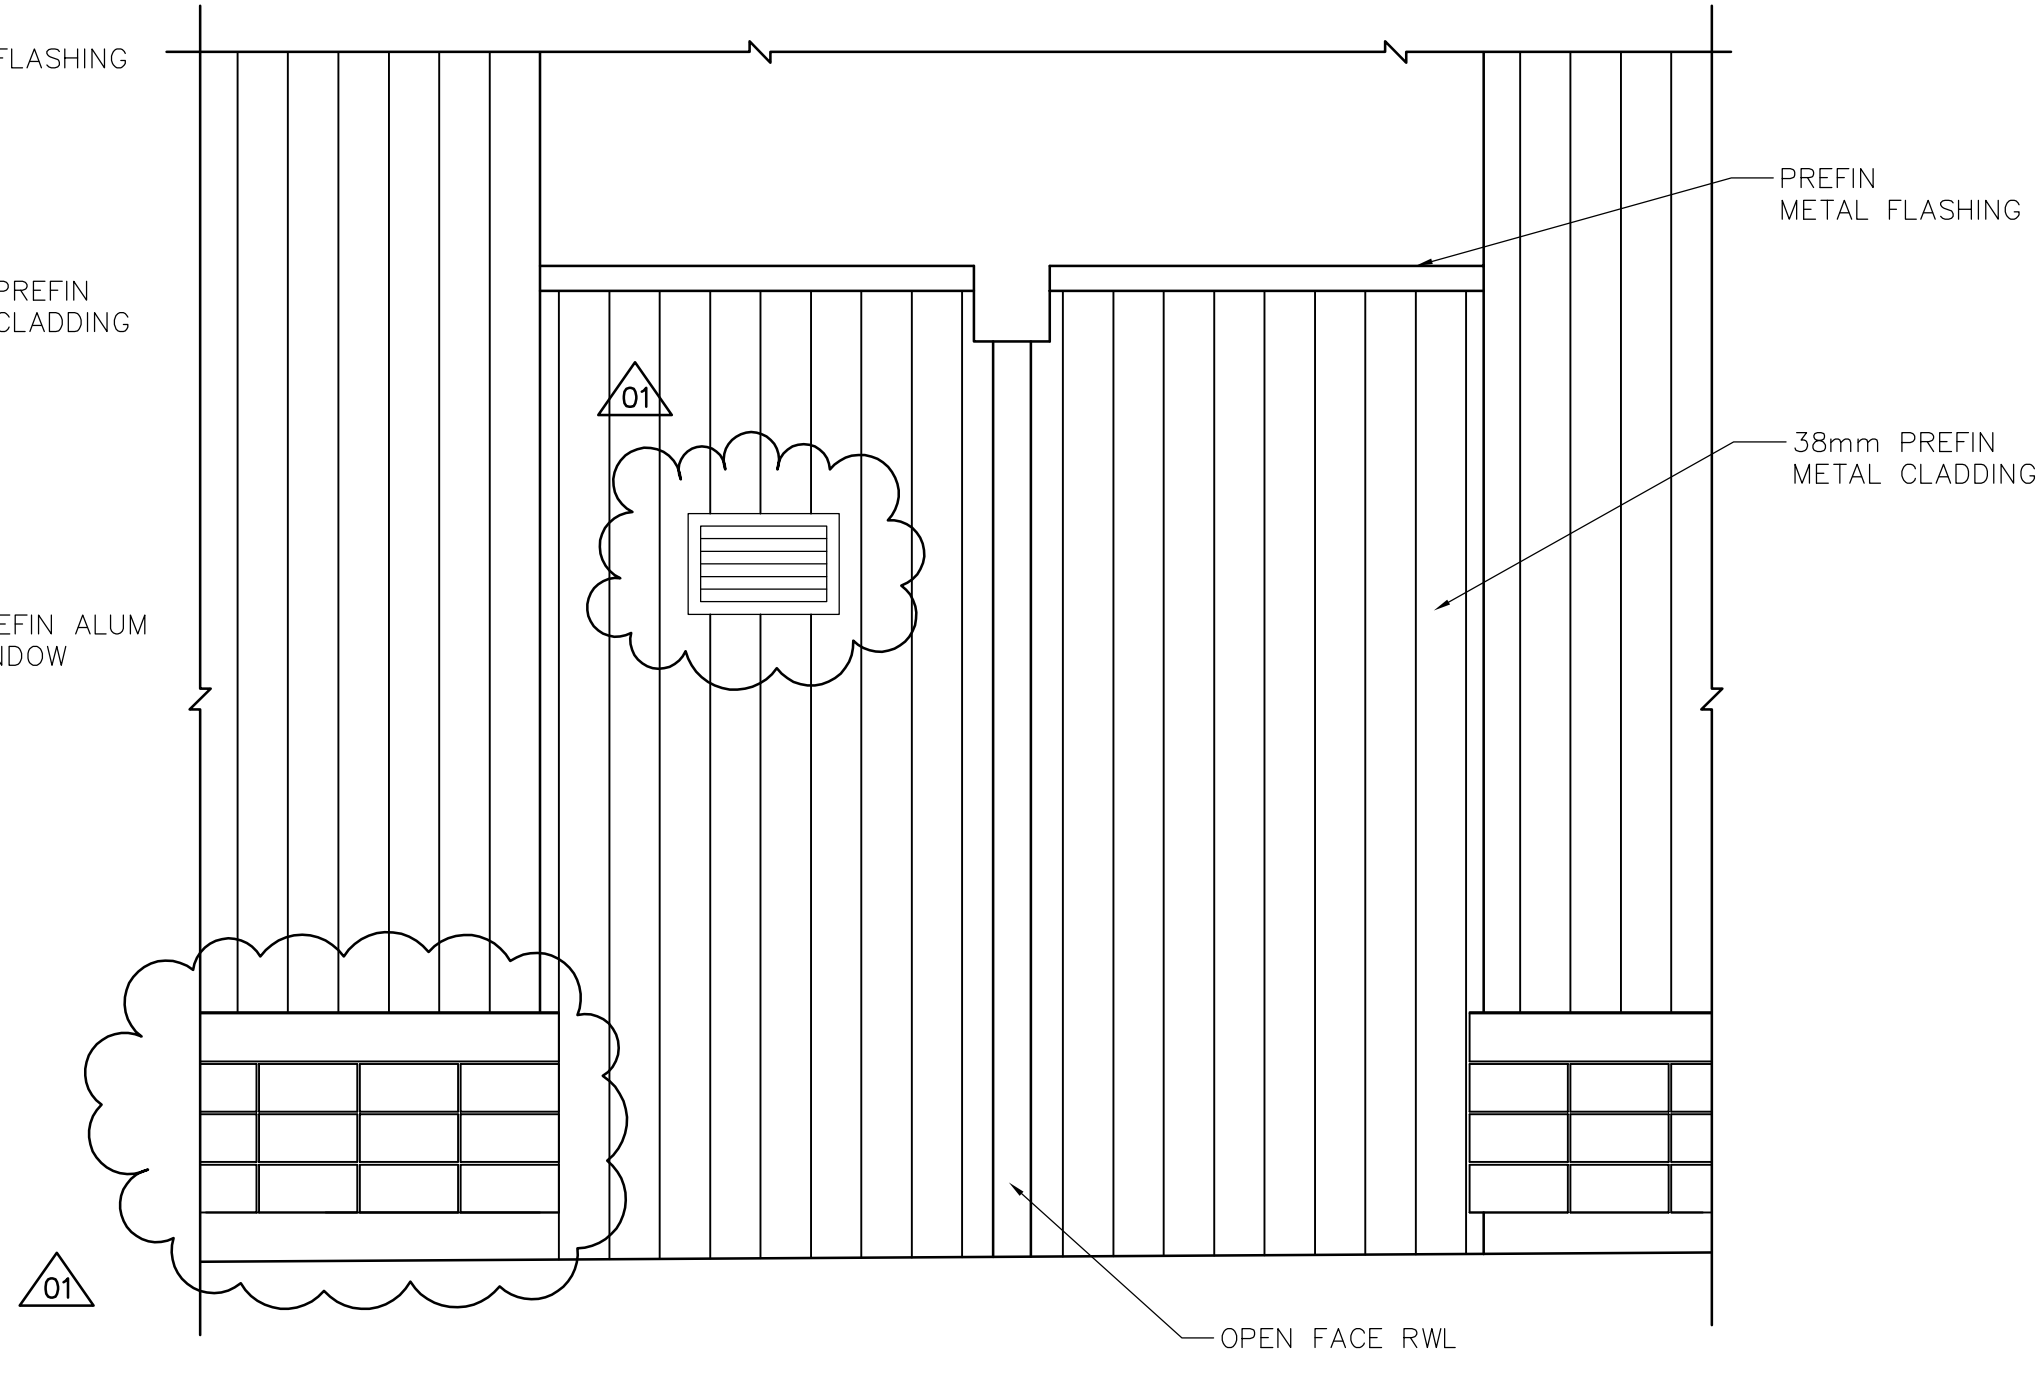


5 NORTH ELEVATION
WJ-B0403 1:30

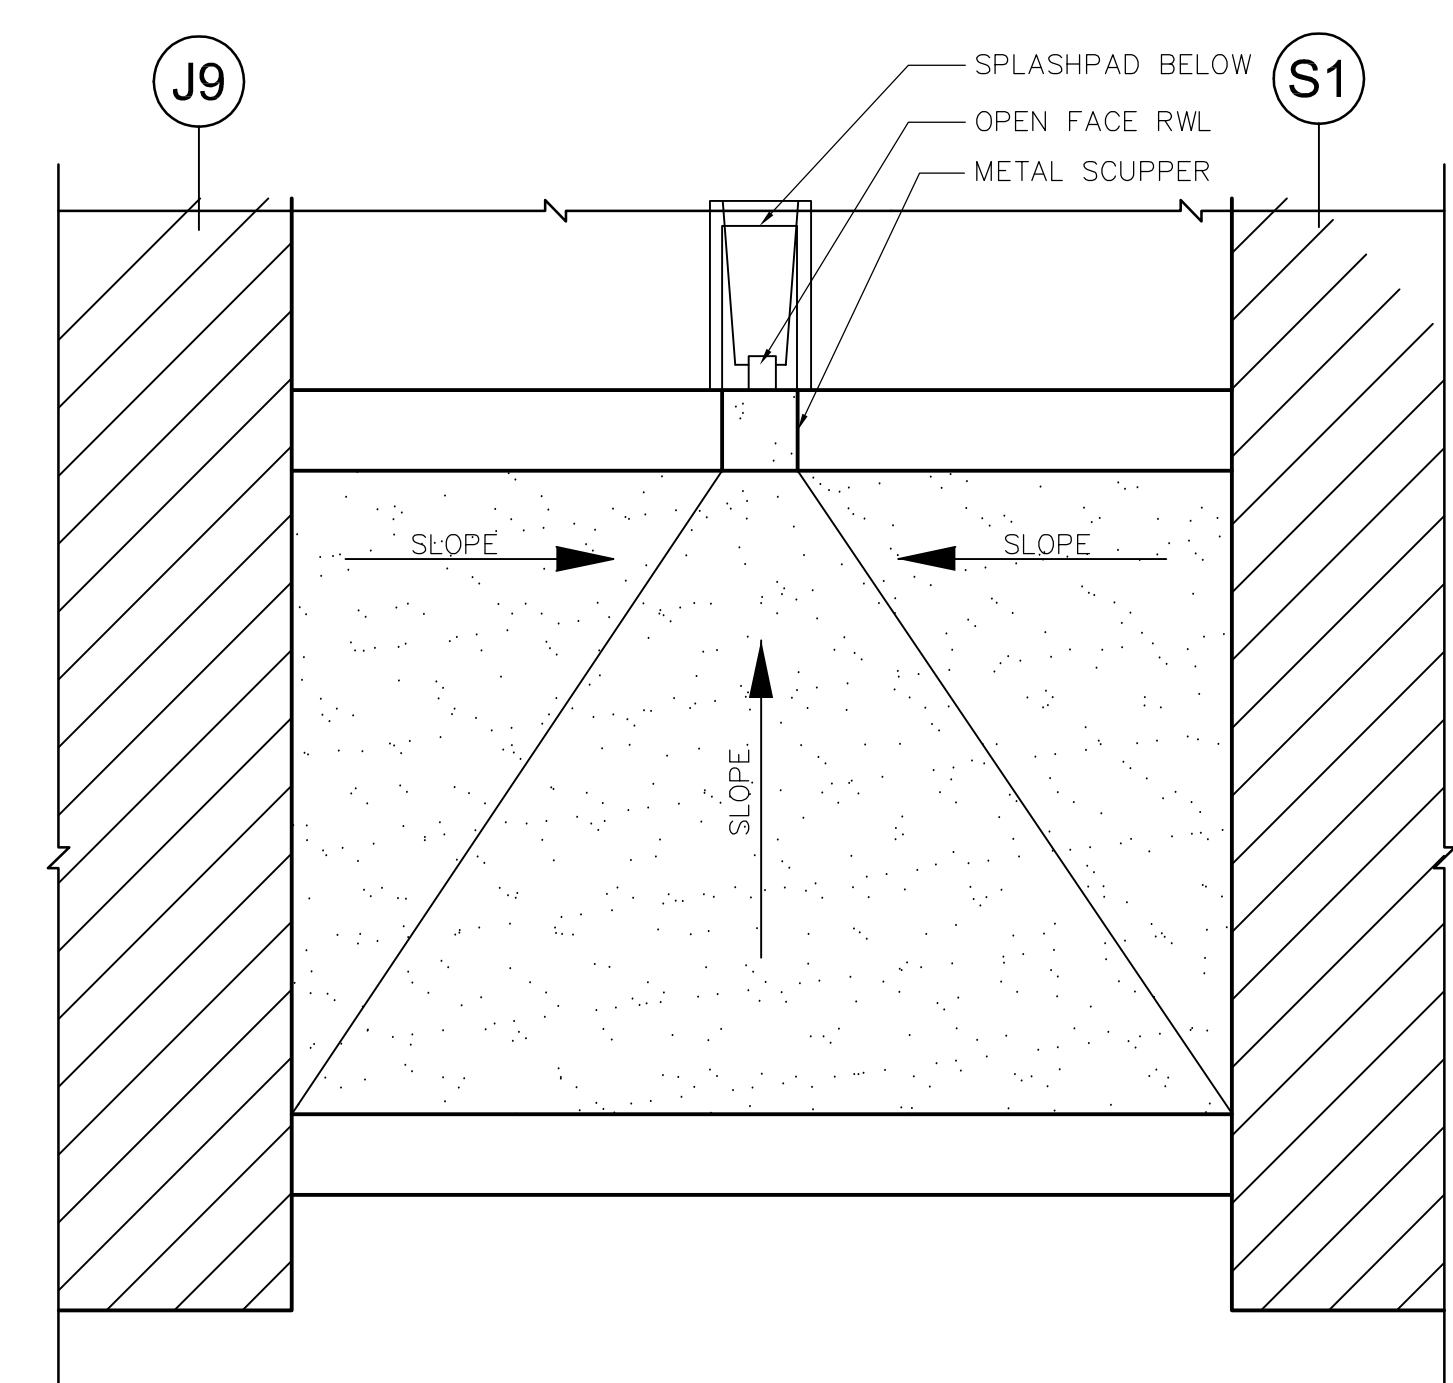


6 ROOF PLAN
WJ-B0403 1:30

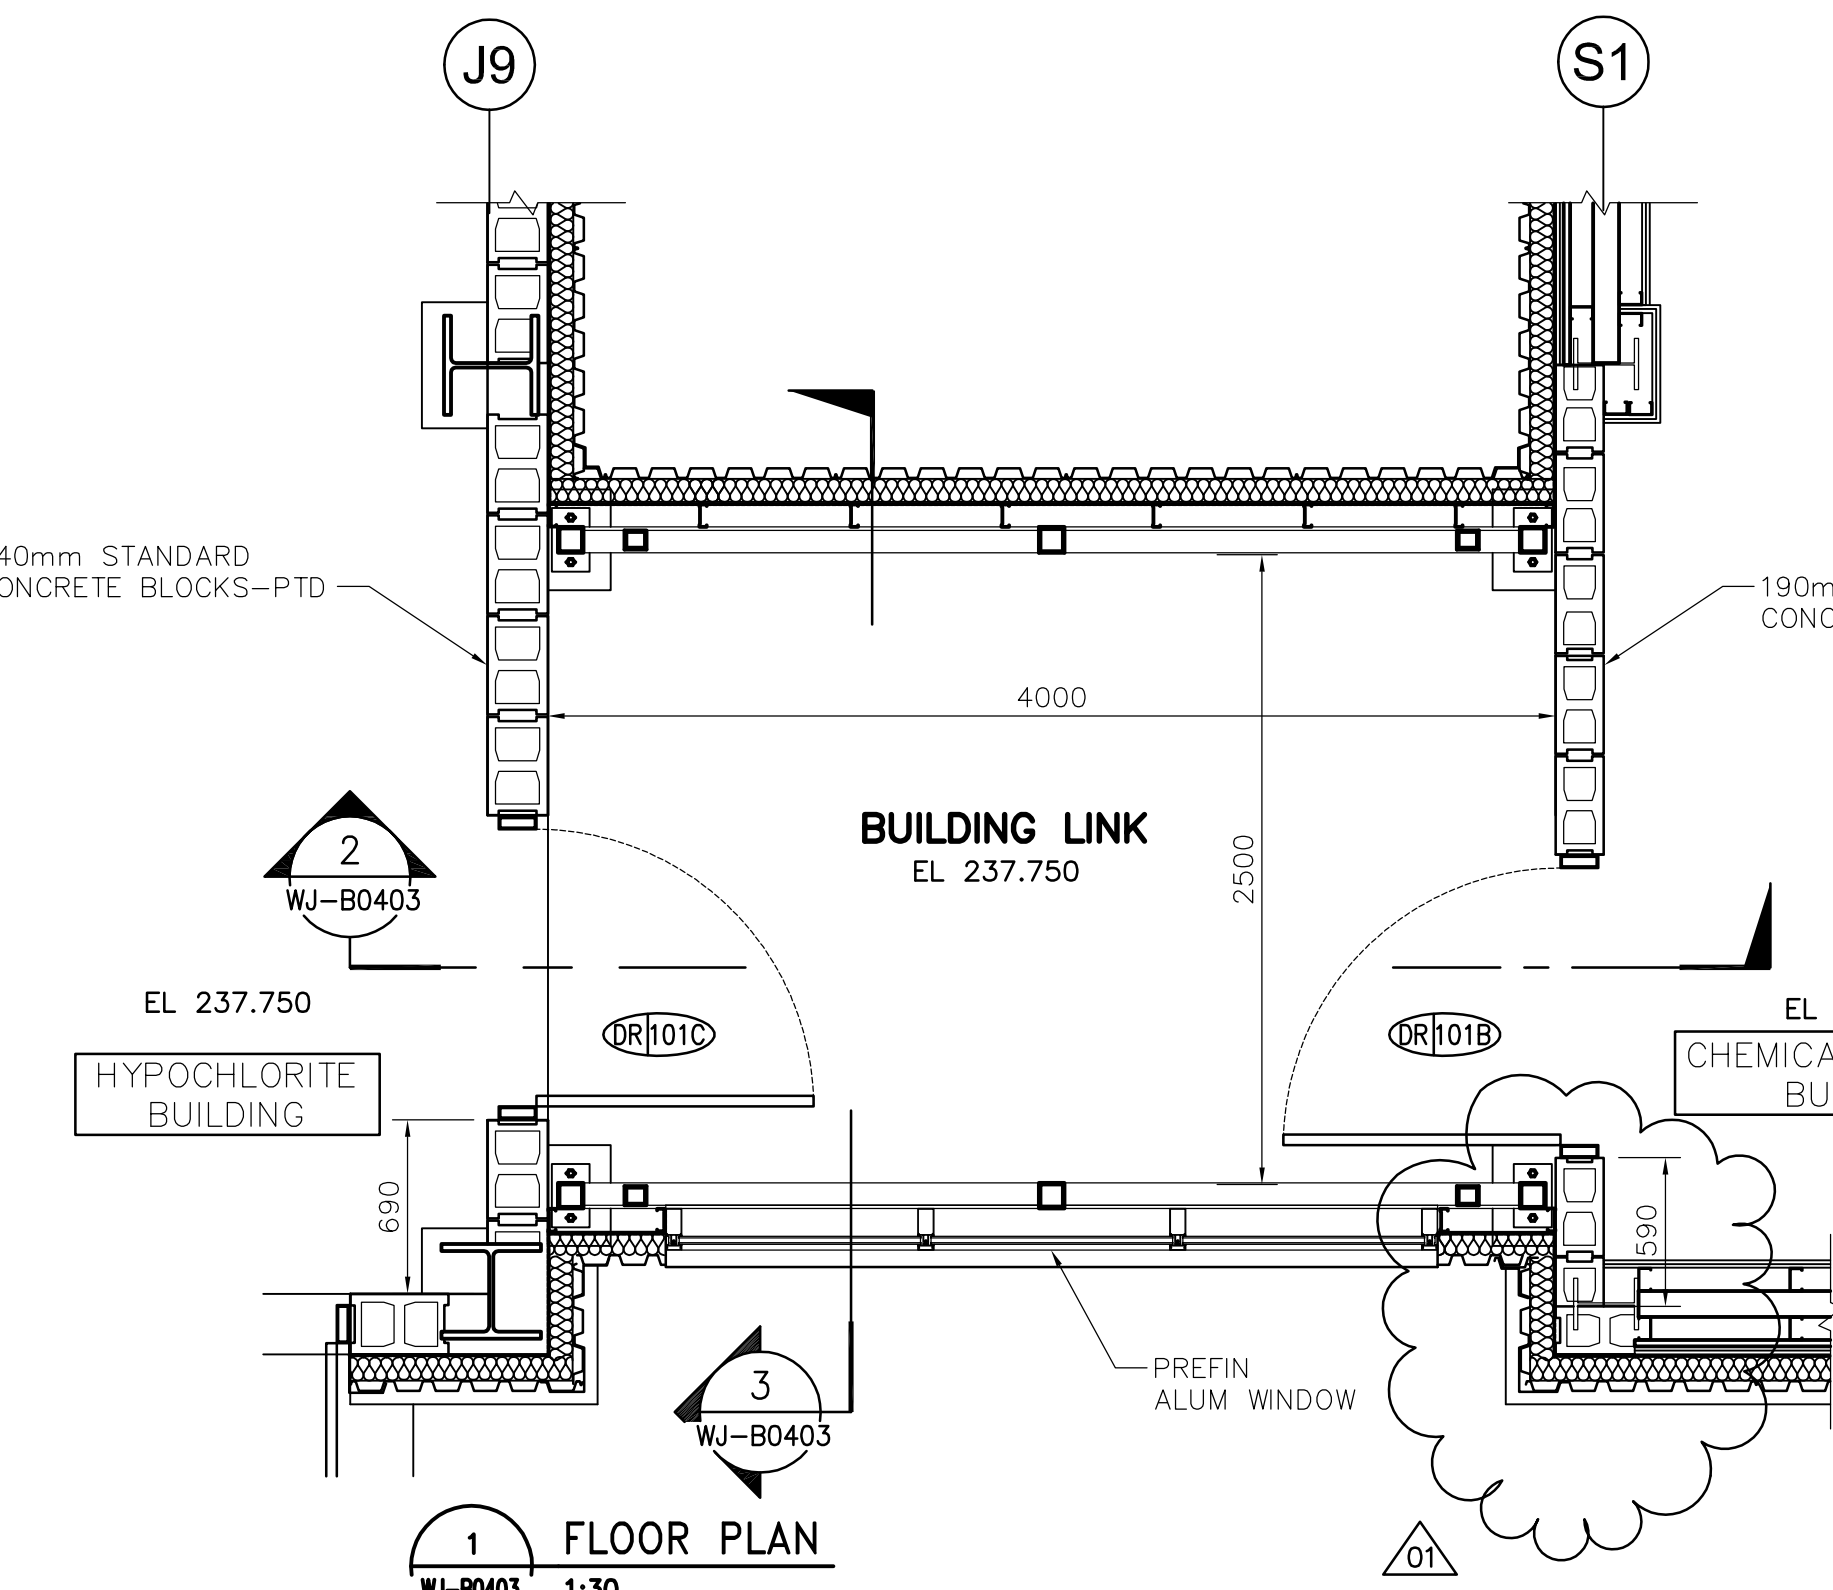

1 FLOOR PLAN
WJ-B0403 1:30

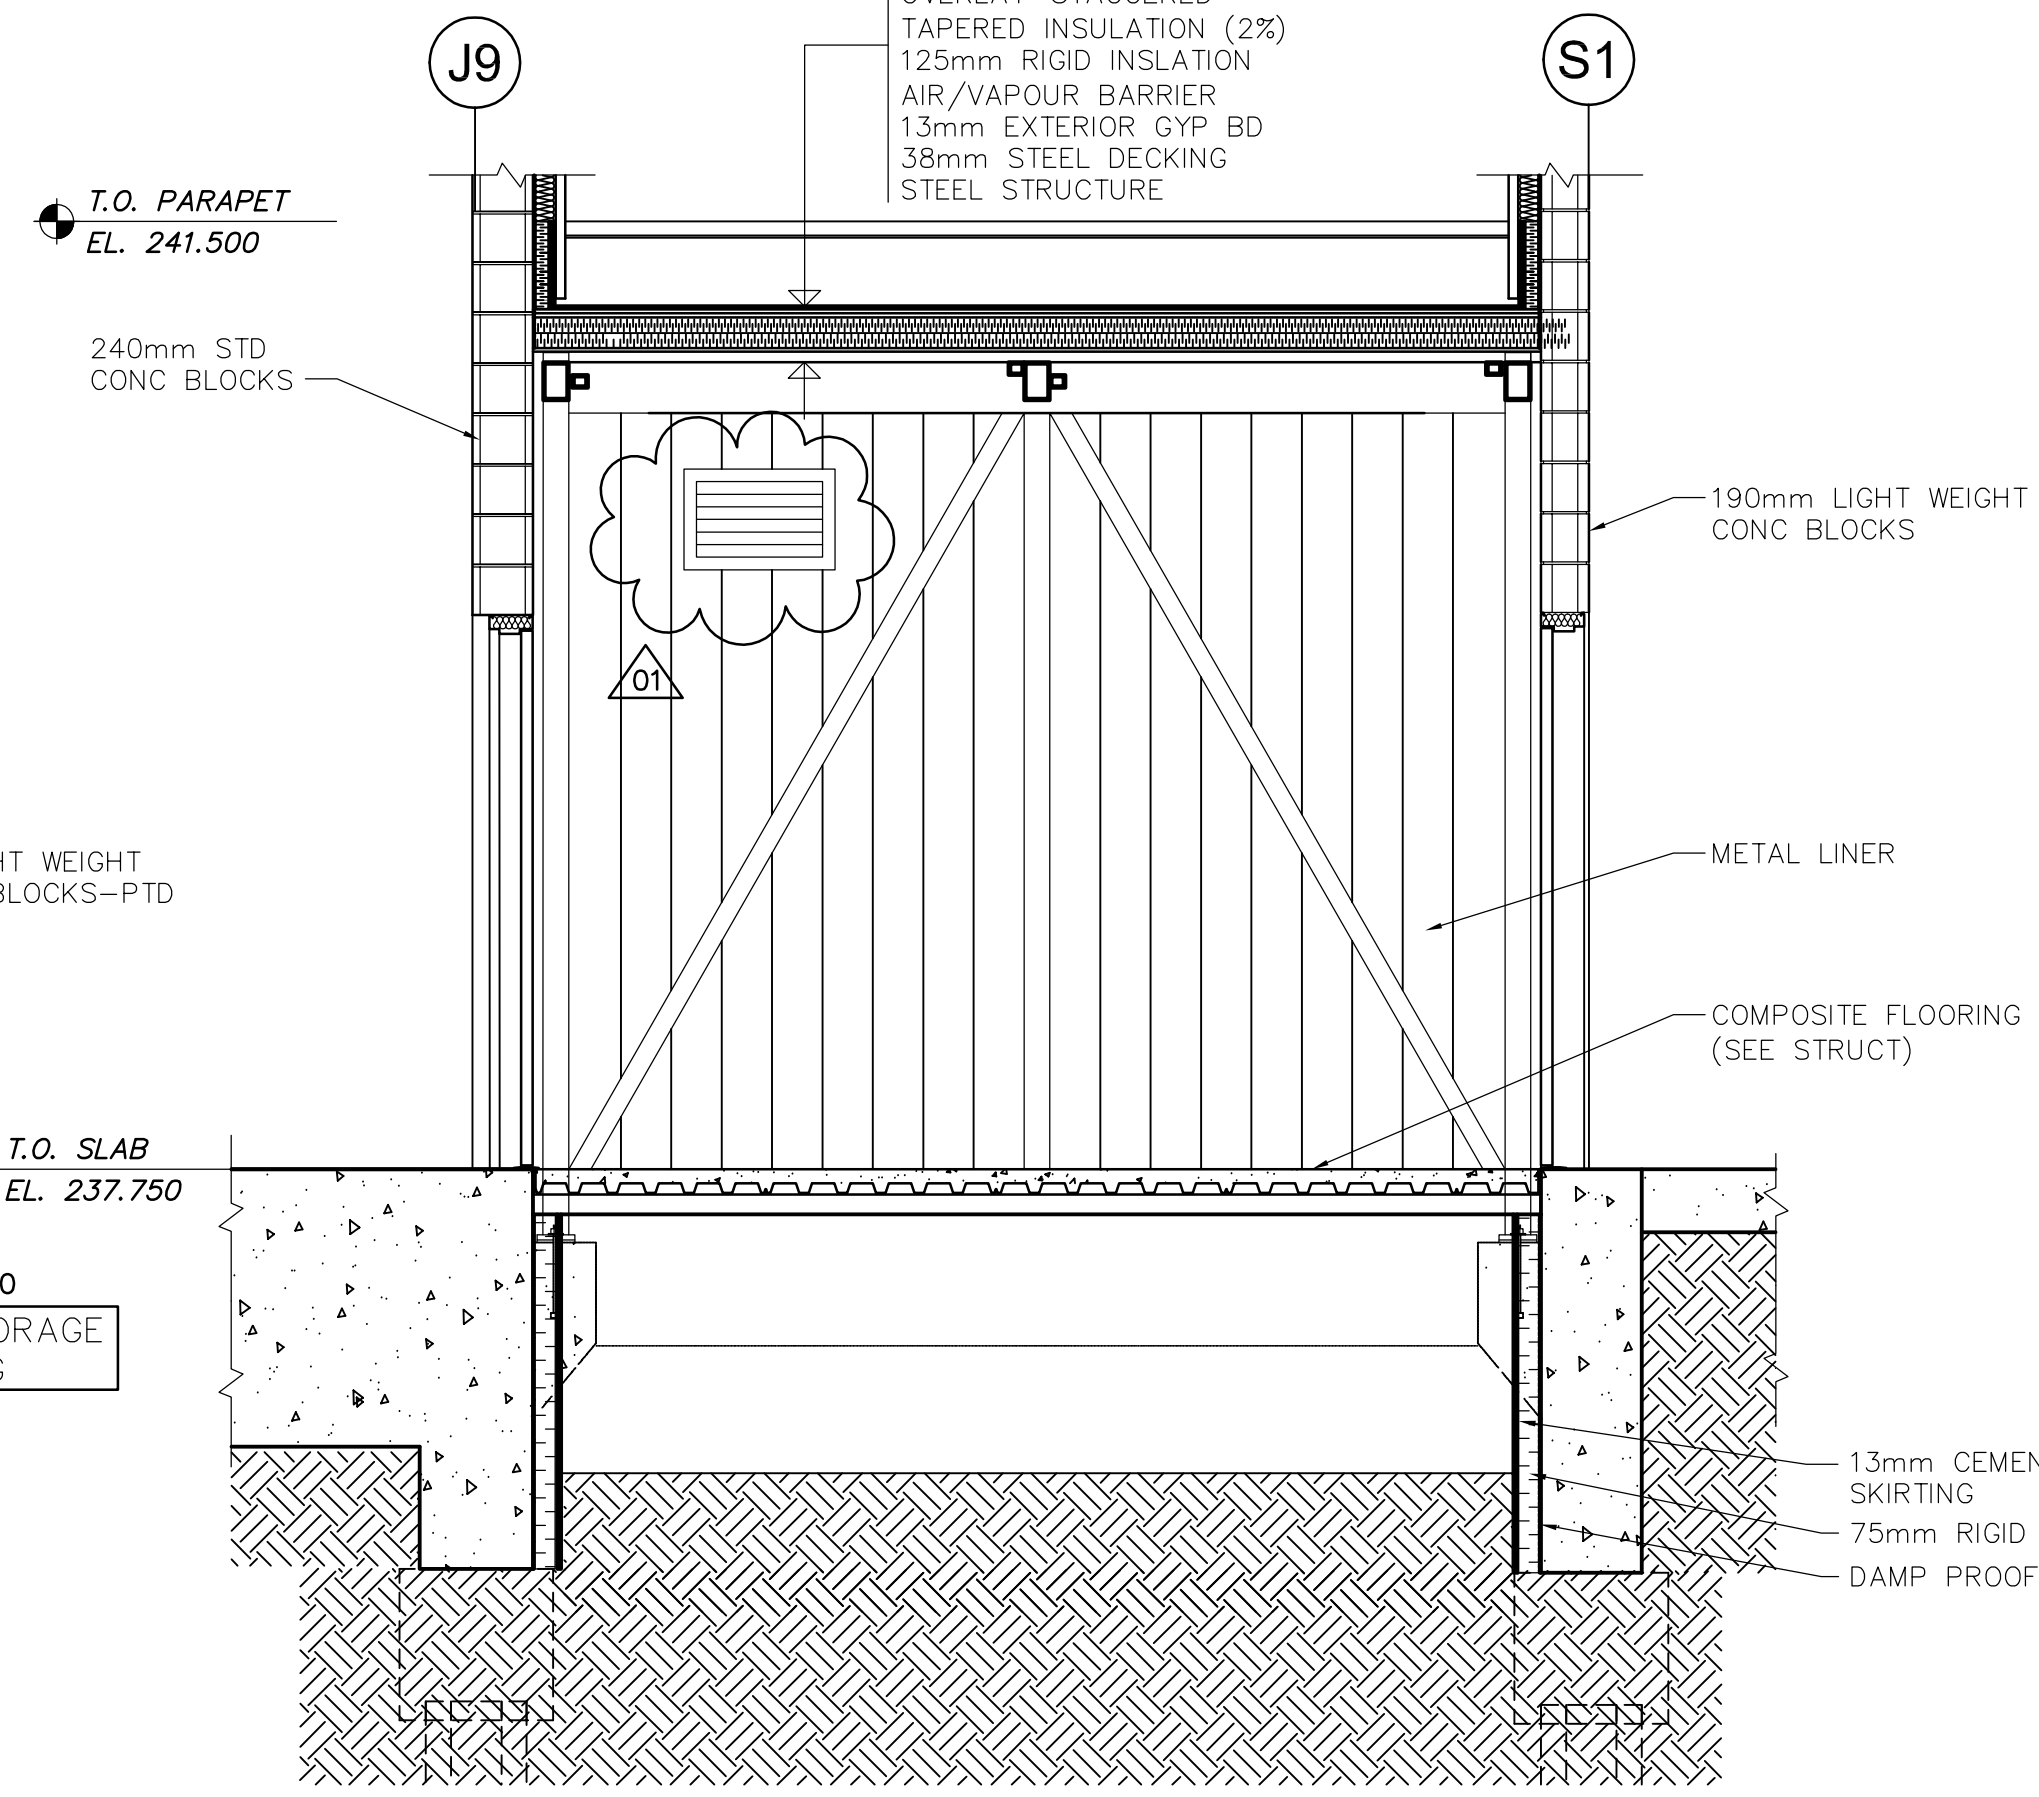

2 SECTION A
WJ-B0403 1:30

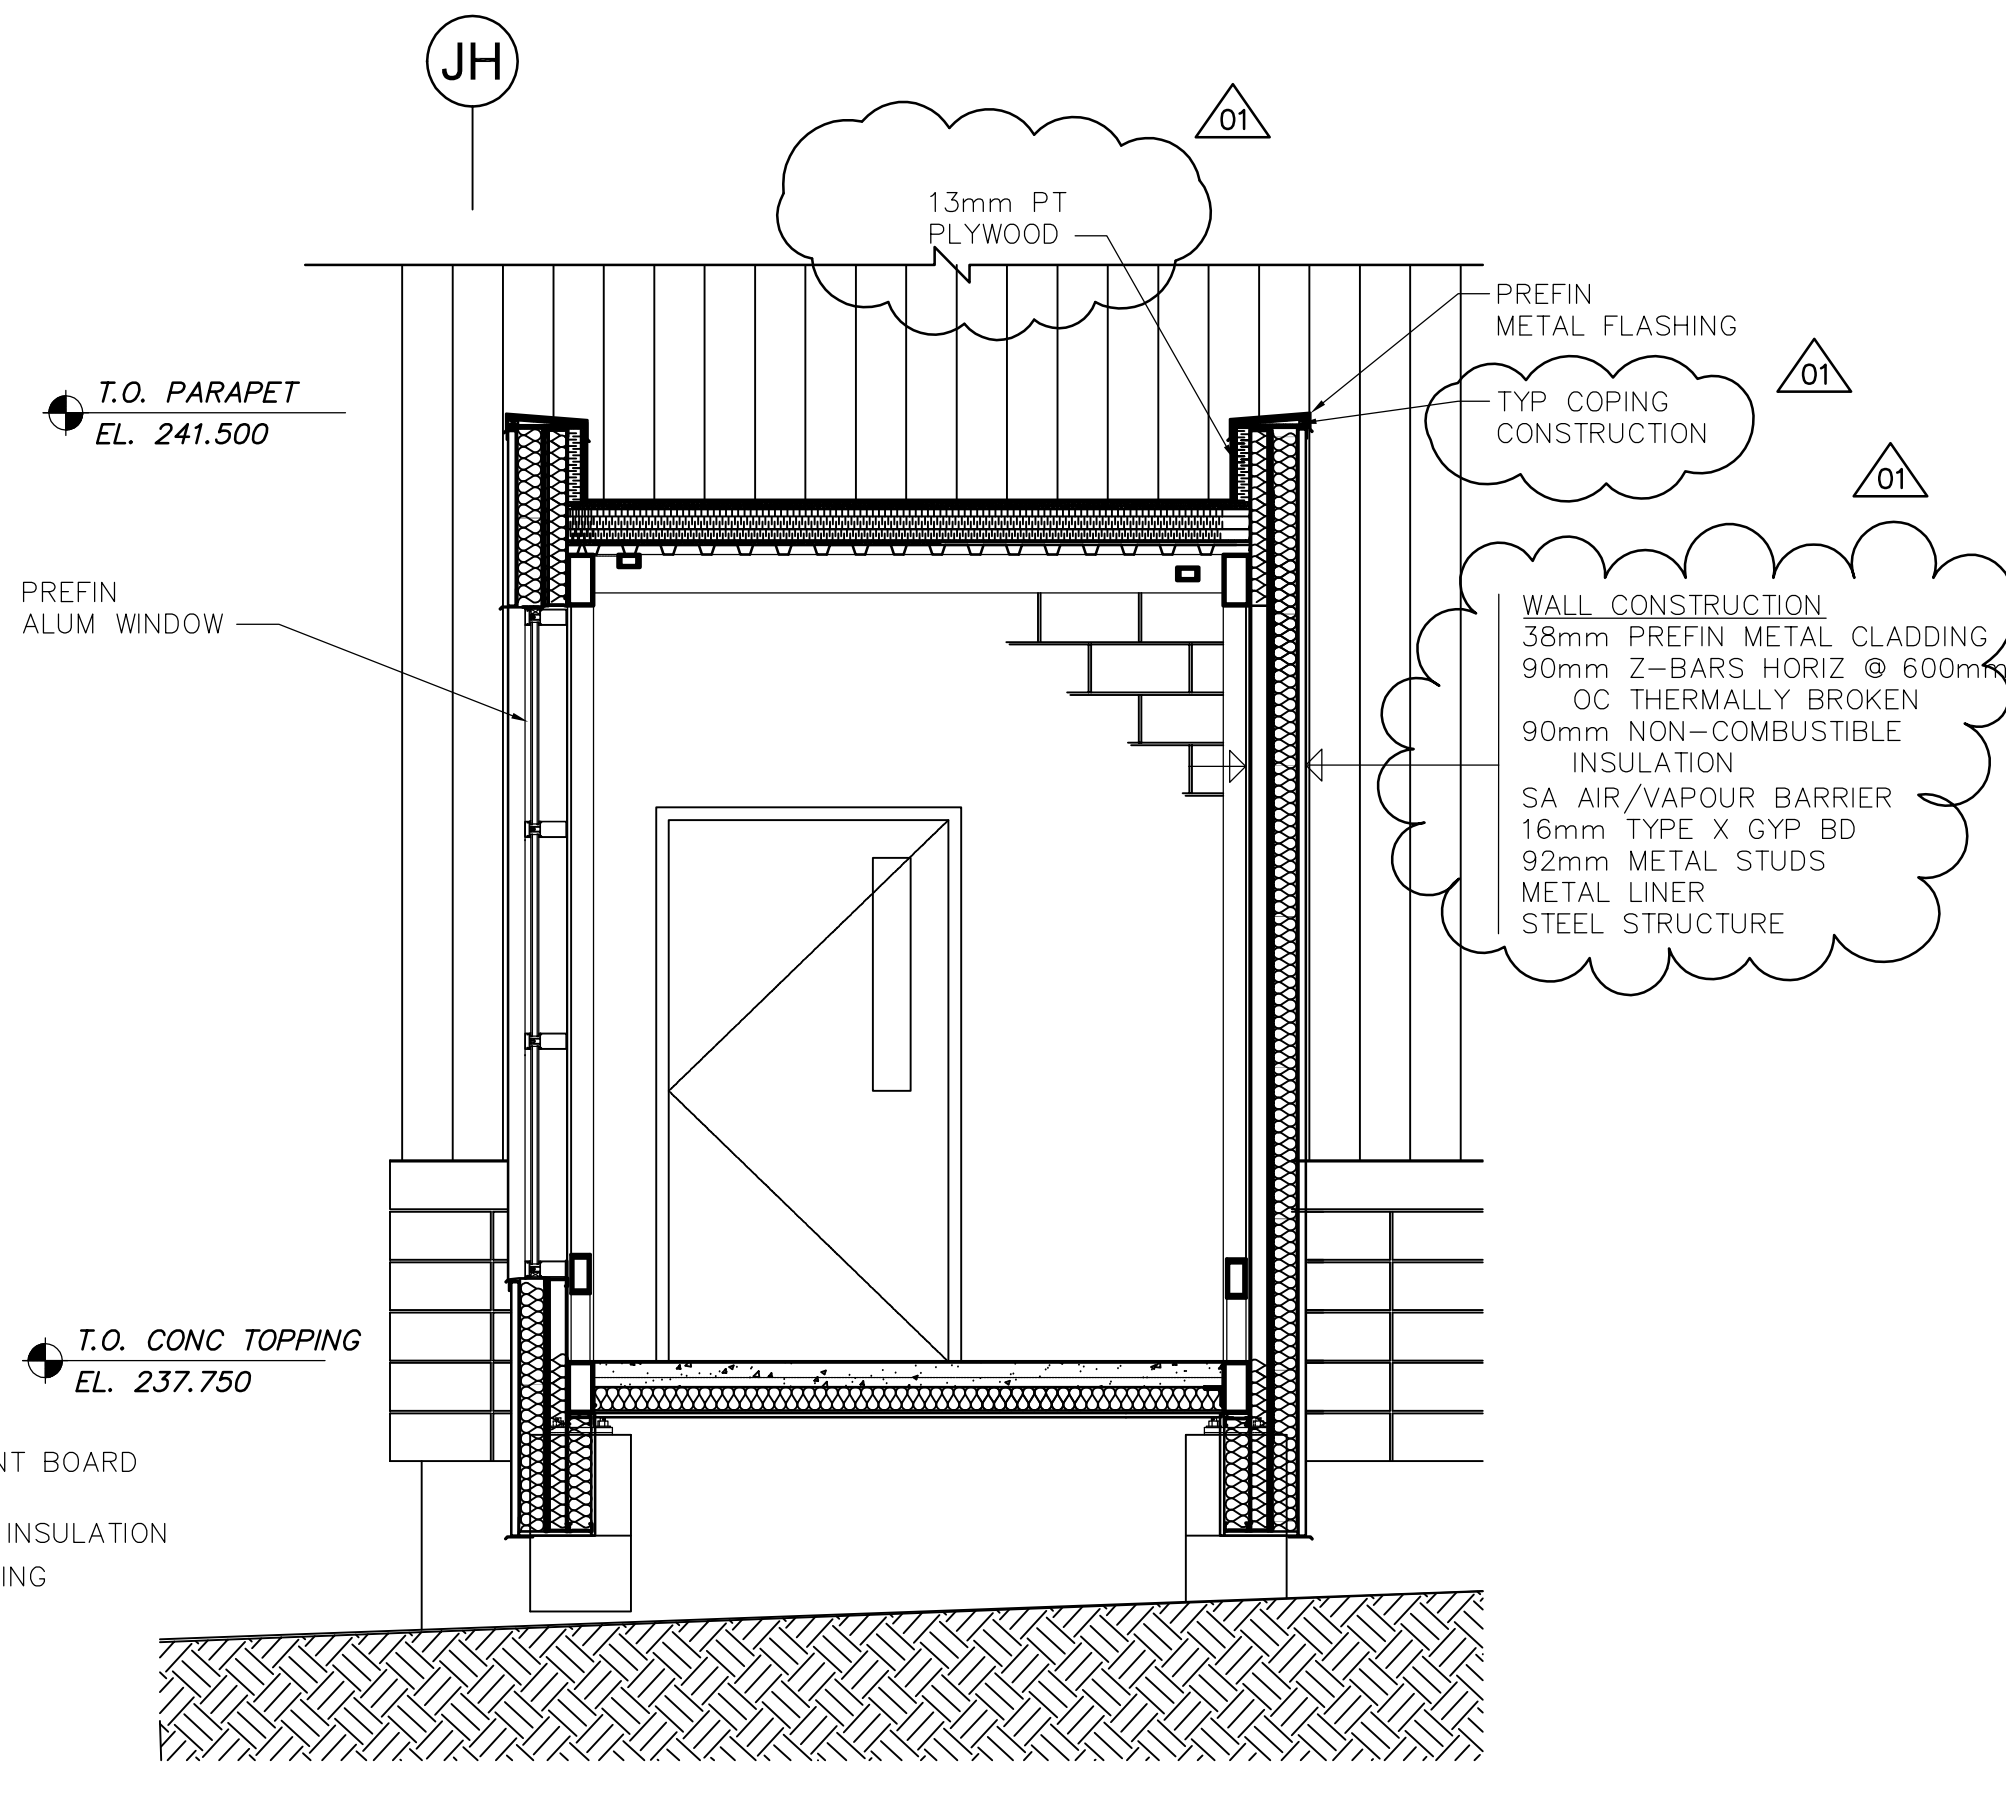

3 SECTION B
WJ-B0403 1:30

ROOF CONSTRUCTION
 2-PLY MOD-BIT ROOFING
 2 LAYERS INSULATION
 OVERLAY-STAGGERED
 TAPERED INSULATION (2%)
 125mm RIGID INSULATION
 AIR/VAPOUR BARRIER
 13mm EXTERIOR GYP BD
 38mm STEEL DECKING
 STEEL STRUCTURE

WALL CONSTRUCTION
 38mm PREFIN METAL CLADDING
 90mm Z-BARS HORIZ @ 600mm
 OC THERMALLY BROKEN
 90mm NON-COMBUSTIBLE
 INSULATION
 SA AIR/VAPOUR BARRIER
 16mm TYPE X GYP BD
 92mm METAL STUDS
 METAL LINER
 STEEL STRUCTURE



NO.	REVISIONS	DATE	BY
01	792-2006 ADDENDUM 2	07/03/20	AL
00	ISSUED FOR TENDER	07/01/31	AL

DESIGNED BY	CHECKED BY
NC	LK
DRAWN BY	APPROVED BY
AL	AHL
SCALE:	RELEASED FOR CONSTRUCTION BY:
AS SHOWN	R. SOROKOWSKI

ENGINEER'S SEAL
ORIGINAL SIGNED BY NEIL COOPER 2007/01/31
CONSULTANT DRAWING NO. WJ-B0403

THE CITY OF WINNIPEG
 WATER AND WASTE DEPARTMENT
 ENGINEERING DIVISION

WATER TREATMENT PLANT
 SODIUM HYPOCHLORITE GENERATION BUILDING
 SODIUM HYPOCHLORITE AND CHEMICAL STORAGE BUILDING

ARCHITECTURAL
 BUILDING LINK DETAILED PLAN & SECTIONS

CITY FILE NUMBER
 SHEET OF
 CITY DRAWING NUMBER
 1-0601J-A-B0403-001-01D