



PARTIAL PILE LAYOUT PLAN  
1:75

NOTE:  
FOR ELECT CONC PAD DETAIL SEE DWGS.

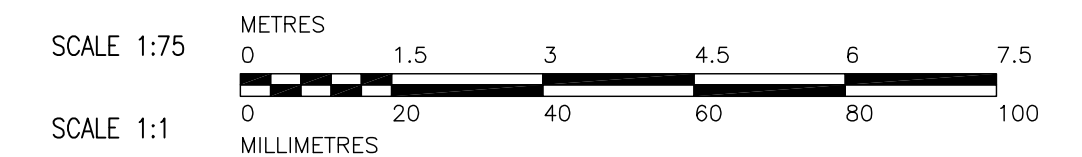

MATCHLINE  
WS-F0100

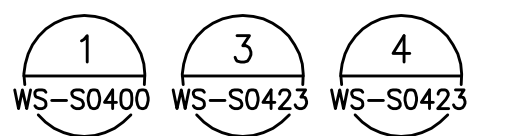

B.M. ELEV.		 Frederickson Cooper ARCHITECTS		 A Tyco International Ltd. Company		ENGINEER'S SEAL		 <b>THE CITY OF WINNIPEG</b> WATER AND WASTE DEPARTMENT ENGINEERING DIVISION	
		DESIGNED BY: CG	CHECKED BY: AP	ORIGINAL SIGNED BY: A. POCHANART		2007/01/31		WATER TREATMENT PLANT BULK CHEMICAL BUILDING	
		DRAWN BY: WDB	APPROVED BY: AHL	CONSULTANT DRAWING NO. WS-F0101		2007/01/31		SODIUM HYPOCHLORITE AND CHEMICAL STORAGE BUILDING	
		SCALE: AS NOTED	RELEASED FOR CONSTRUCTION BY: R. SOROKOWSKI	STRUCTURAL FOUNDATION PLAN - PARTIAL PILE LAYOUT		CITY FILE NUMBER		SHEET OF	
NO. REVISIONS		DATE	BY	DATE	DATE	CITY DRAWING NUMBER		1-06018-B-F0101-001-01D	