


MCC #12A ← → MCC #12B

MCC #12 - FRONT ELEVATION
NOT TO SCALE

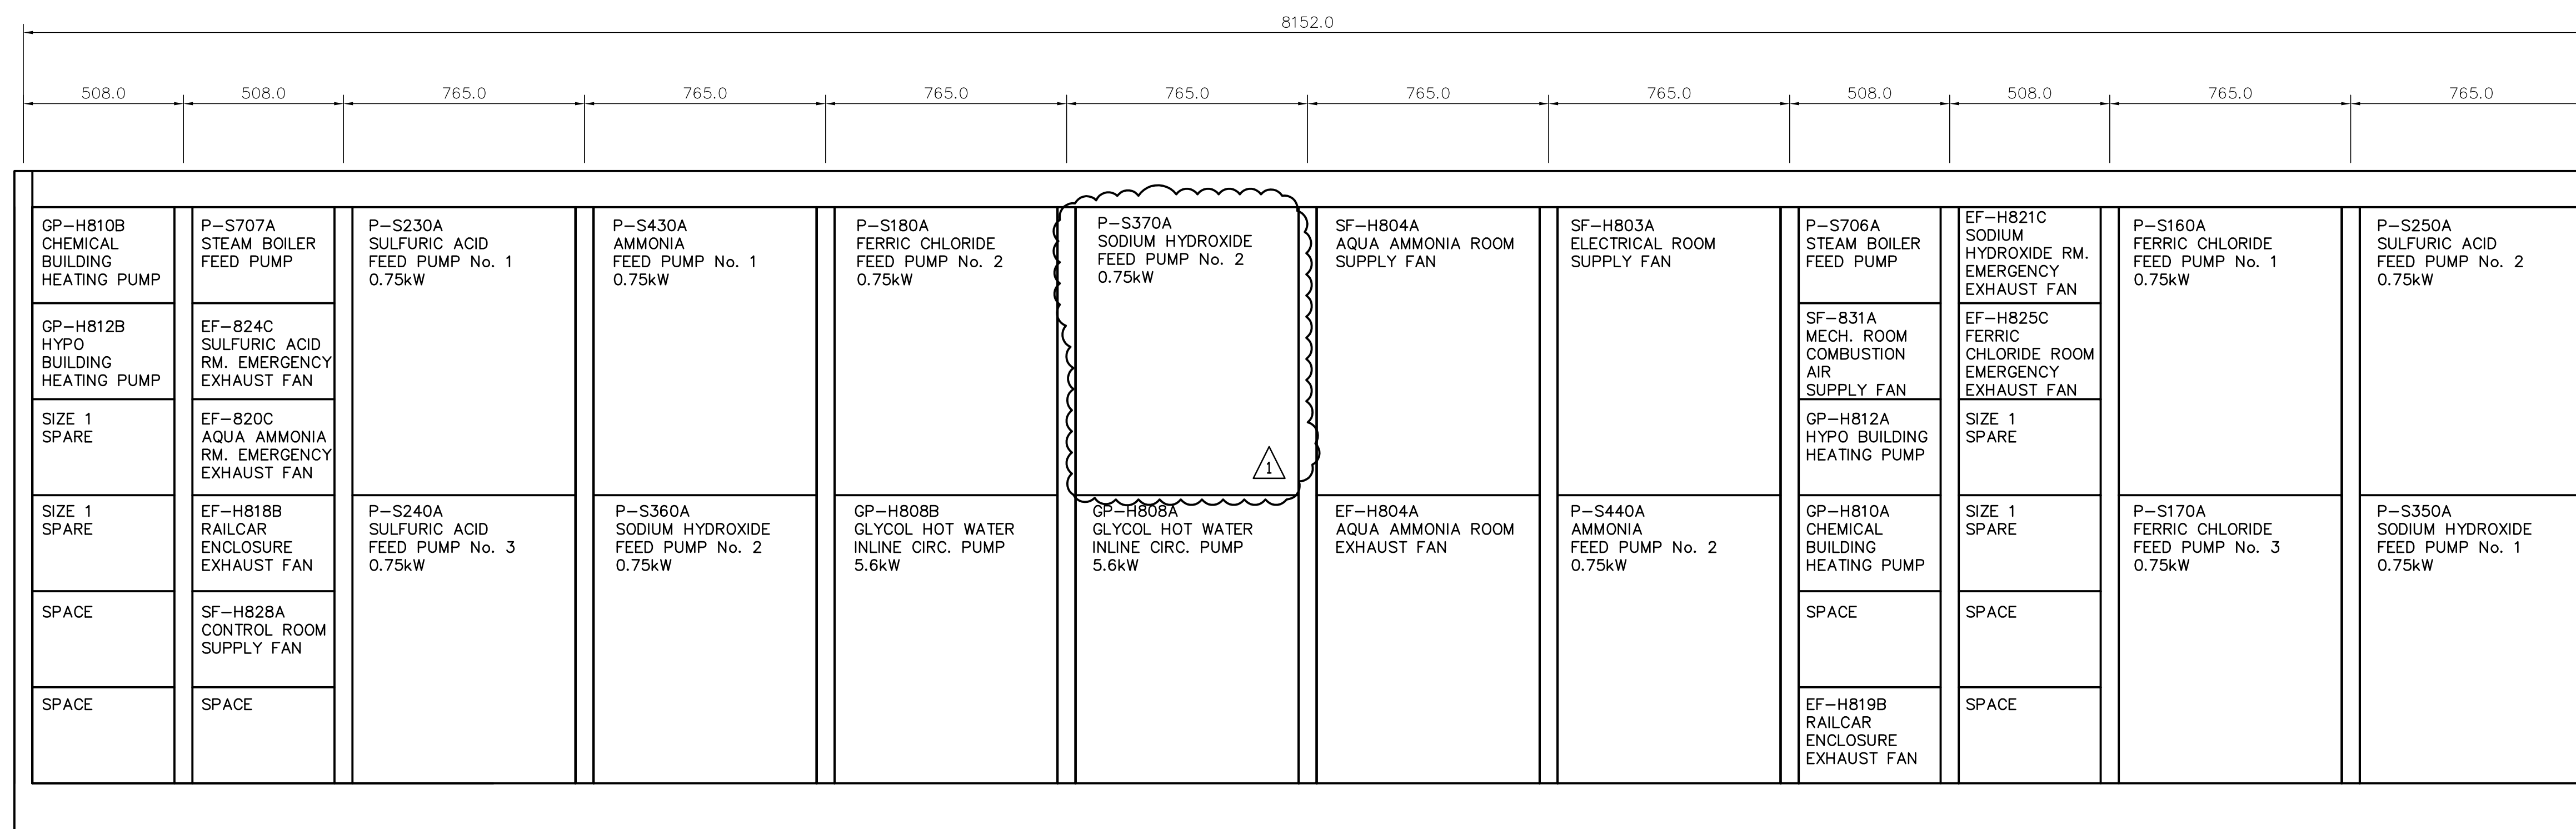

MCC #12B ← → MCC #12A

MCC #12 - BACK ELEVATION
NOT TO SCALE

<p>Certificate of Authorization Earth Tech Canada Inc. No. 730 Expiry: April 30, 2007</p>	B.M. ELEV.	<p>Frederickson Cooper ARCHITECTS</p>	<p>A The International Ltd. Company</p>	ENGINEER'S SEAL	<p>THE CITY OF WINNIPEG WATER AND WASTE DEPARTMENT ENGINEERING DIVISION</p>	
	DESIGNED BY: BLM			CHECKED BY: PS		ORIGINAL SIGNED BY: P. STRYK
	DRAWN BY: ERC			APPROVED BY: AHL		2007/01/31
	SCALE: NTS			RELEASED FOR CONSTRUCTION BY: R. SOROKOWSKI		CONSULTANT DRAWING NO. WS-E0505
01 792-2006 ADDENDUM 4 07/04/05 ERC	07/01/31 ERC	DATE 2007/11/29	DATE 2007/01/31		WATER TREATMENT PLANT BULK CHEMICAL STORAGE SODIUM HYPOCHLORITE AND CHEMICAL STORAGE BUILDING	
00 ISSUED FOR TENDER					CITY FILE NUMBER	
NO. REVISIONS					SHEET OF	
					CITY DRAWING NUMBER	
					1-0601S-F-E0505-001-010	