



SKYWAY BRIDGE FACILITY, POWER AND LIGHTING PLAN
1:30

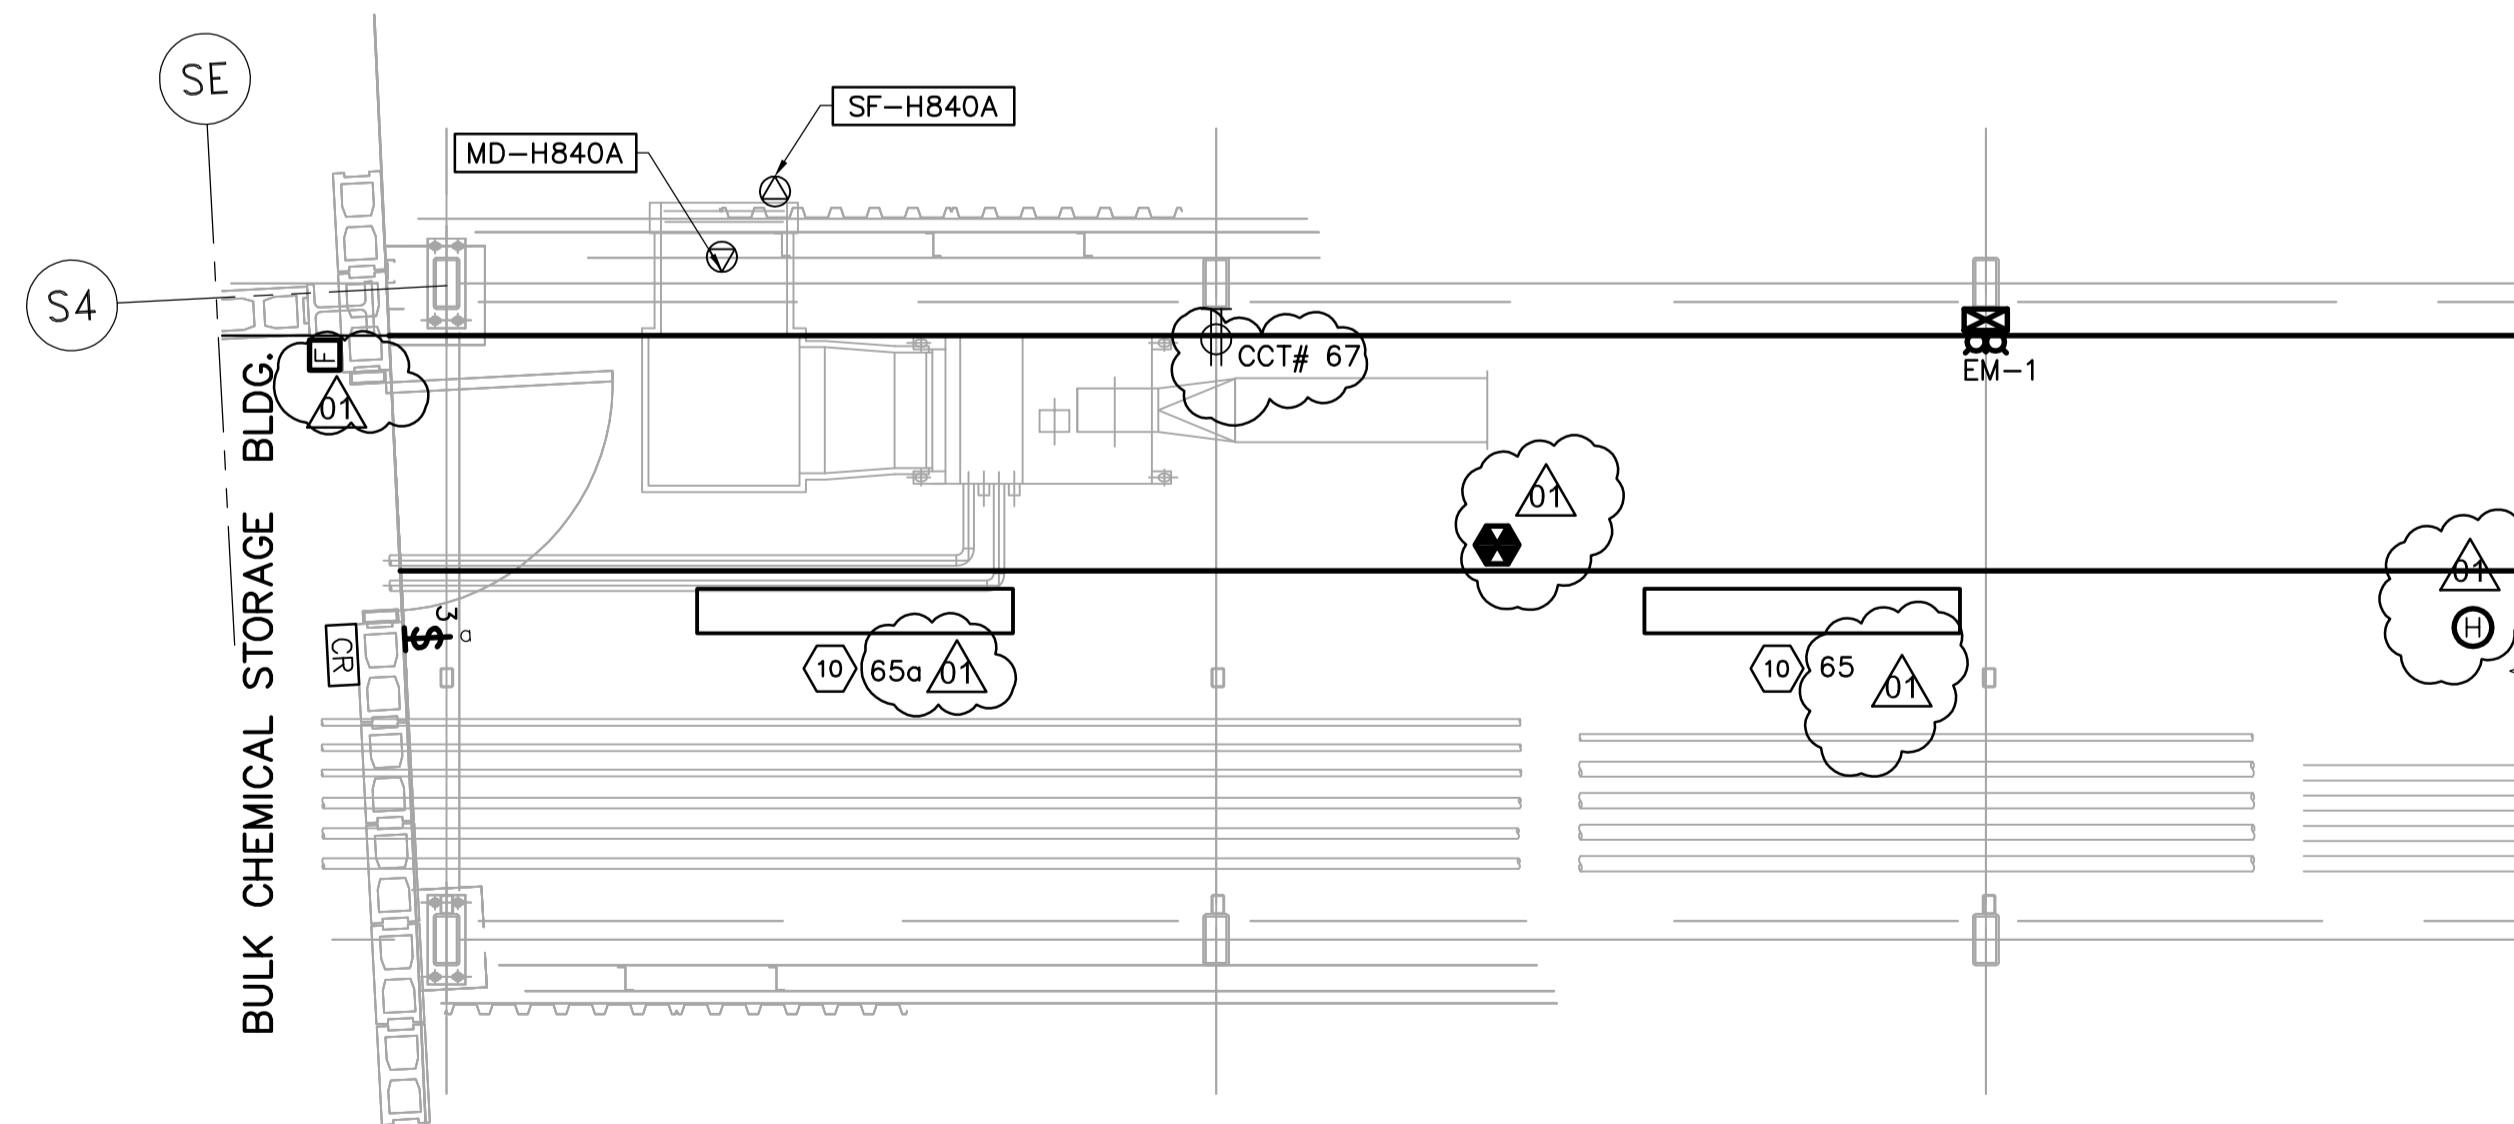

CABLE TRAY TAGGING
SEE DETAIL

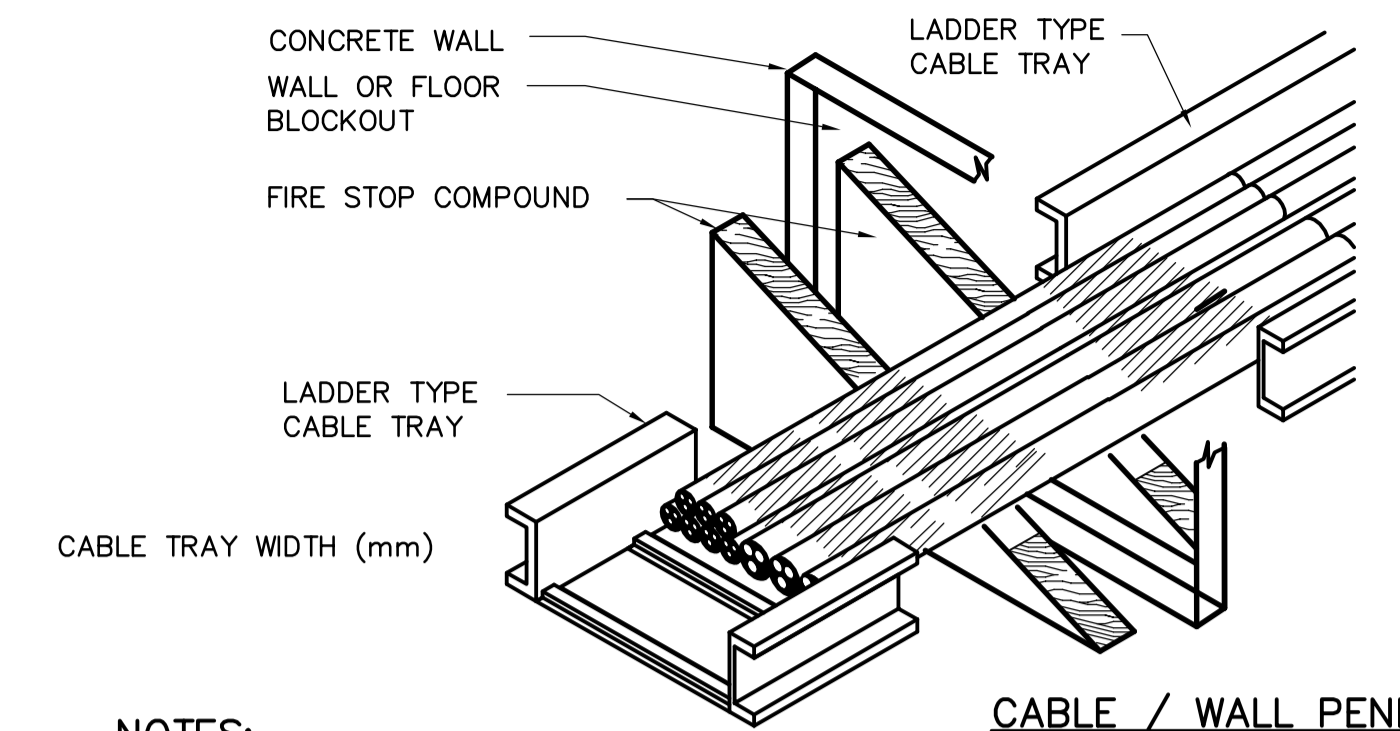


CABLE / WALL PENETRATION

NOTES:

1. APPLY FIRE RESISTANT COATING TO BOTH INSIDE AND OUTSIDE OF WALL AND TO THE TRAY ALSO.
2. ALL COMPONENTS OF A ULC APPROVED FIRE STOP SYSTEM TO BE INSTALLED PER MANUFACTURERS' INSTRUCTIONS FOR SPECIFIED FIRE RATING.
3. FIRE STOP MATERIALS & INSTALLATION TO BE DONE BY OTHERS.


1
-
NTS

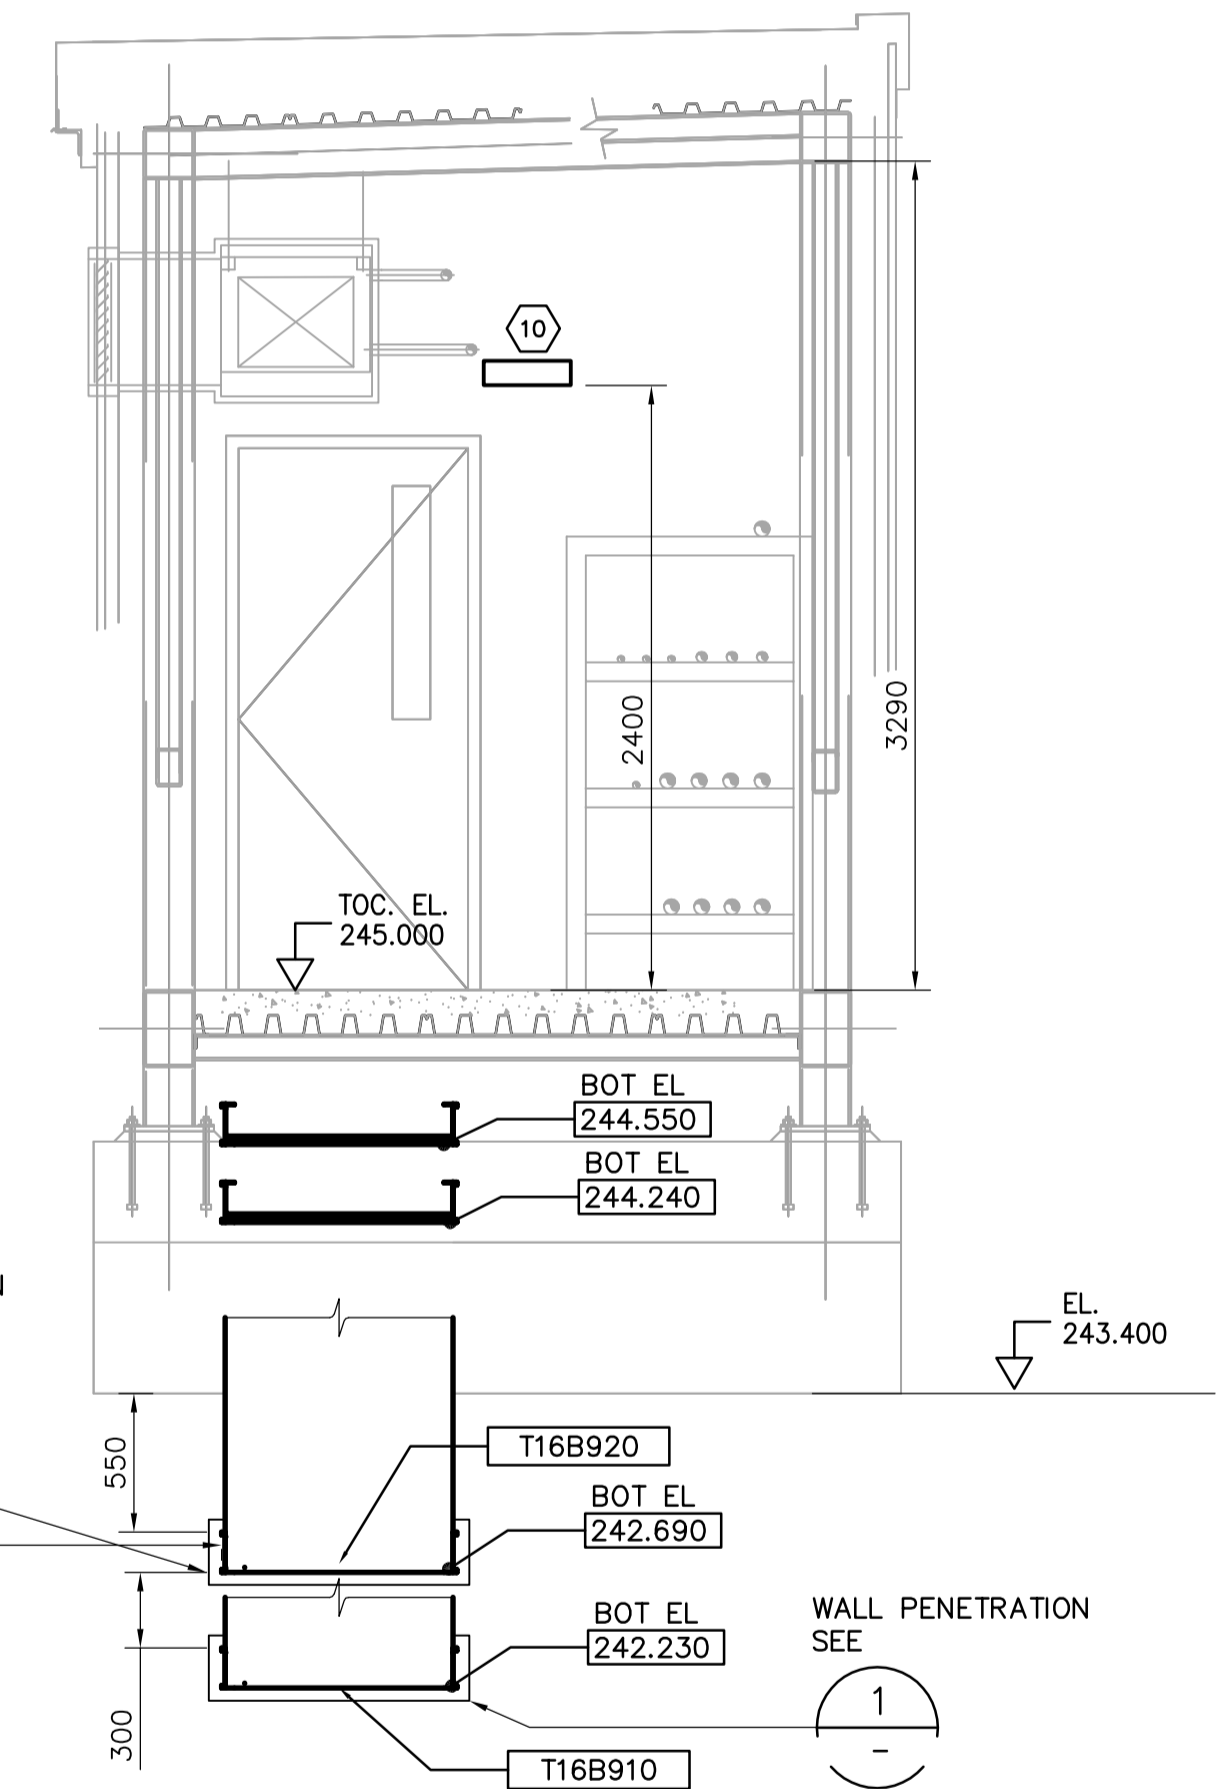

A
-
SECTION
1:30

NOTES:

1. ALL 120V AND 208V, LOADS ARE FED FROM PP-S2022
2. EMERGENCY LIGHTING EM-X-1 IS FED FROM BATTERY PACK EM-41.
3. LUMINAIRE MOUNTING EL. 2.4m FROM T.O.C.

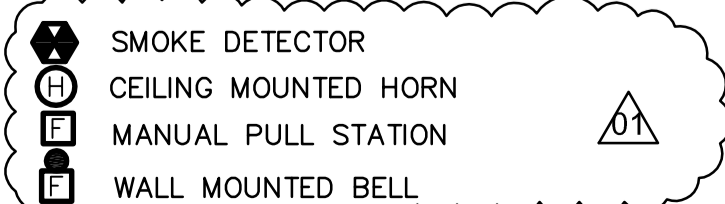

| NO. | REVISIONS | DATE | BY | DATE | BY |
|-----|-----------------------|----------|----|------|----|
| 01 | 792-2006 ADDENDUM 5 | 07/04/10 | LL | | |
| 00 | ISSUED FOR ADDENDUM 2 | 07/03/12 | LL | | |

| | | | |
|---------------------------------------|------------|---------------------------------------|---------------|
| Frederickson Cooper ARCHITECTS | | A Tyco International Ltd. Company | |
| DESIGNED BY | LL | CHECKED BY | |
| DRAWN BY | TLL | APPROVED BY | AHL |
| SCALE: | 1:30 | RELEASED FOR CONSTRUCTION BY: | R. SOROKOWSKI |
| DATE | 2007/03/12 | DATE | 2007/02/16 |

| | |
|------------------------|----------------|
| ENGINEER'S SEAL | |
| ORIGINAL SIGNED BY | L.D. LLEWELLYN |
| | 2007/02/16 |
| CONSULTANT DRAWING NO. | WJ-E0401 |

| | |
|---|--|
| THE CITY OF WINNIPEG WATER AND WASTE DEPARTMENT ENGINEERING DIVISION | |
| WATER TREATMENT PLANT SODIUM HYPOCHLORITE BUILDING SODIUM HYPOCHLORITE AND CHEMICAL STORAGE BUILDINGS | CITY FILE NUMBER SHEET OF CITY DRAWING NUMBER 1-0601J-A-E0401-001-01D |
| ELECTRICAL SKYWAY BRIDGE DETAILS | |