



PLAN AT EL 245.00
1:100

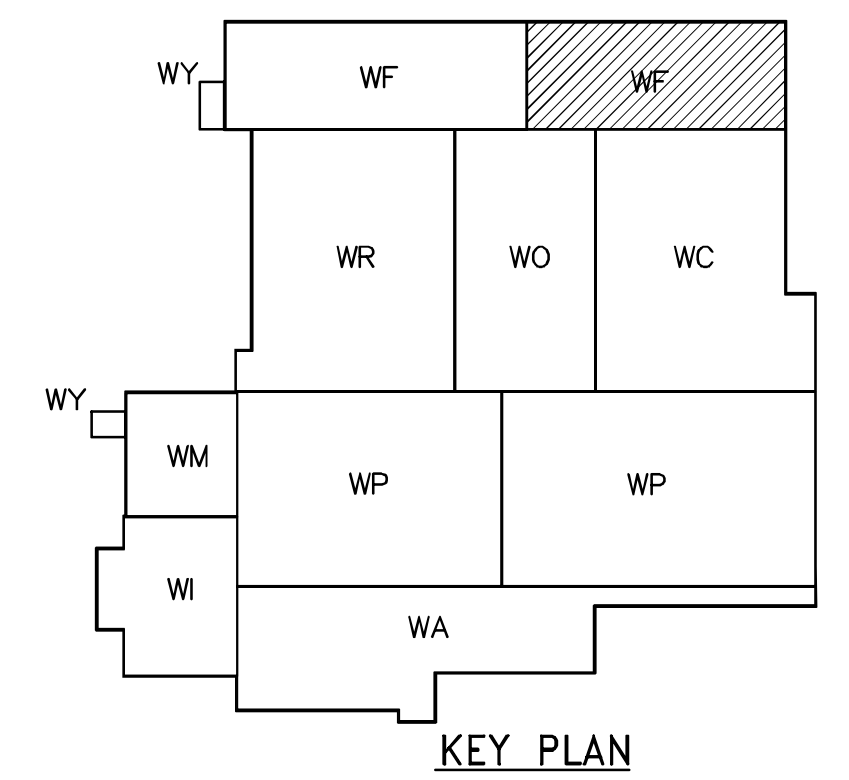

NOTES:
1. SUPPLY BY OTHERS, INSTALLATION BY CONTRACTOR.

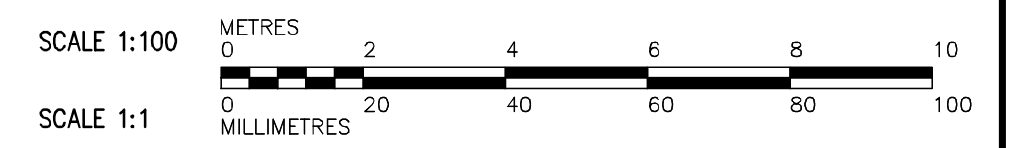

FOR INFORMATION ONLY - ISSUED WITH
BID OPPORTUNITY 792-2006 - ADDENDUM 8

APEGM
Certificate of Authorization
CH2M HILL Canada Ltd.
No. 1441 Expiry: April 30, 2007

| B.M. ELEV. | DATE | BY |
|------------|------|----|
| | | |
| | | |
| | | |

| | | | |
|--|------------------|---|------------------|
| CH2MHILL Frederickson Cooper ARCHITECTS | | EarthTech A Tyco International Ltd. Company | |
| DESIGNED BY: TB | CHECKED BY: LS | DATE: 2005/07/08 | DATE: 2006/03/29 |
| DRAWN BY: TAR/EK | APPROVED BY: AHL | RELEASED FOR CONSTRUCTION BY: R. SOROKOWSKI | DATE: 2006/03/29 |
| SCALE: 1:100 | | | |

ENGINEER'S SEAL
ORIGINAL SIGNED BY
P. WOBMA
2006/03/29
CONSULTANT DRAWING NO.
WF-M0132

THE CITY OF WINNIPEG
WATER AND WASTE DEPARTMENT
ENGINEERING DIVISION

WATER TREATMENT PLANT
FILTRATION
MECHANICAL AND ELECTRICAL

PROCESS MECHANICAL
FILTRATION AREA 2
THIRD FLOOR PLAN

CITY FILE NUMBER
SHEET OF
CITY DRAWING NUMBER
1-0601F-A-M0132-001-010