



1 PAVEMENT SECTION
C1.03 SCALE H=1:100 V=1:33

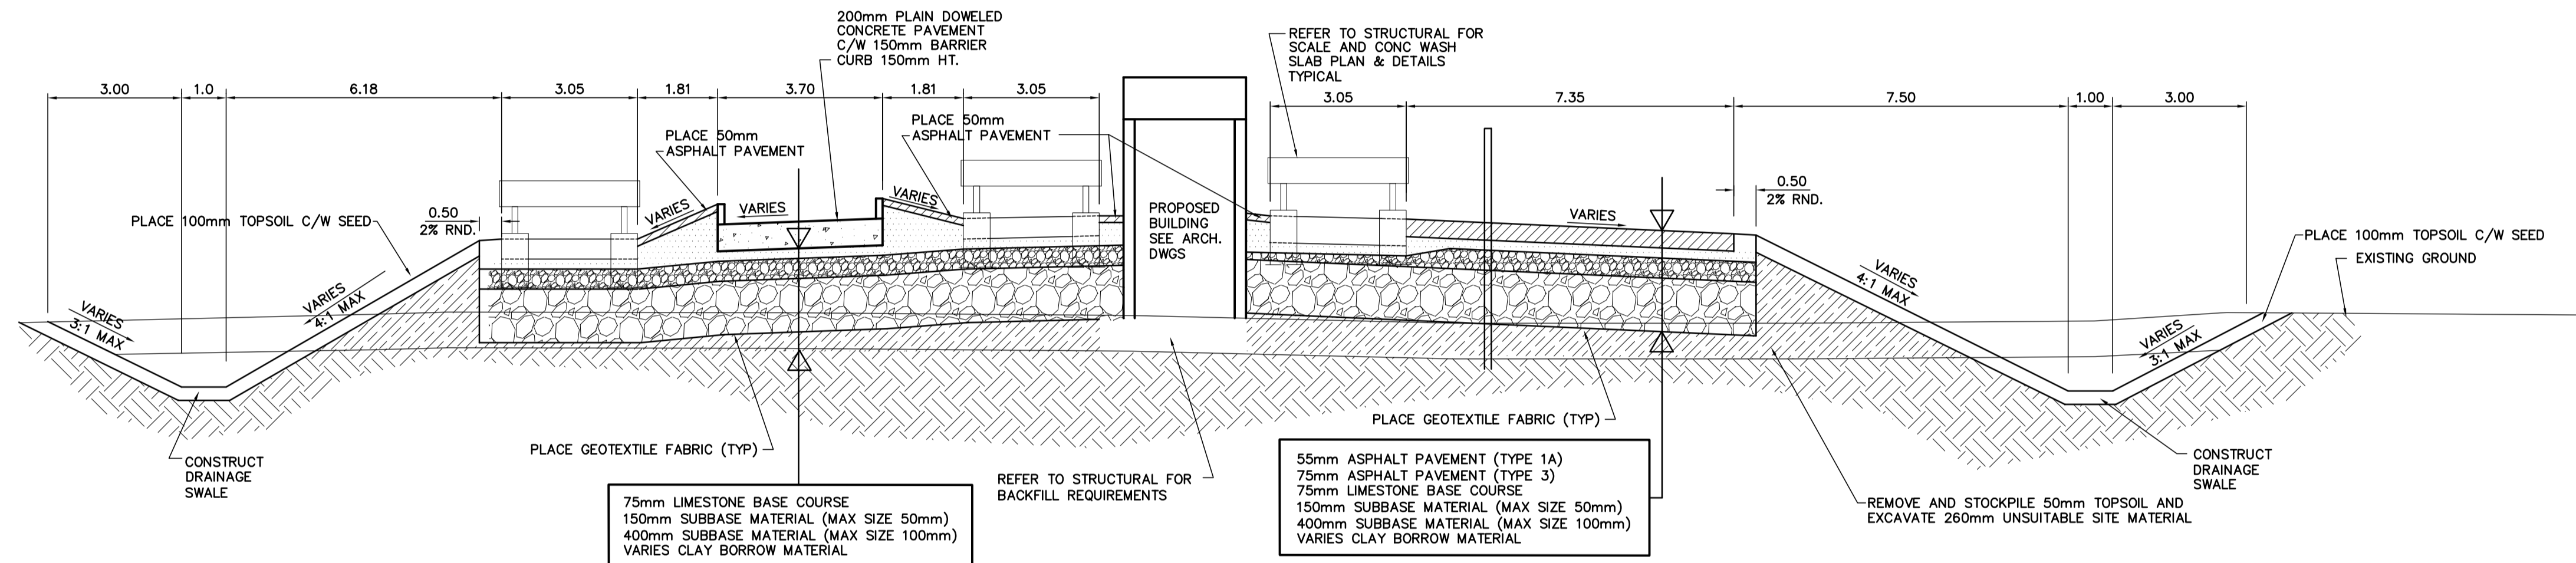

2 PAVEMENT SECTION
C1.03 SCALE H=1:100 V=1:33

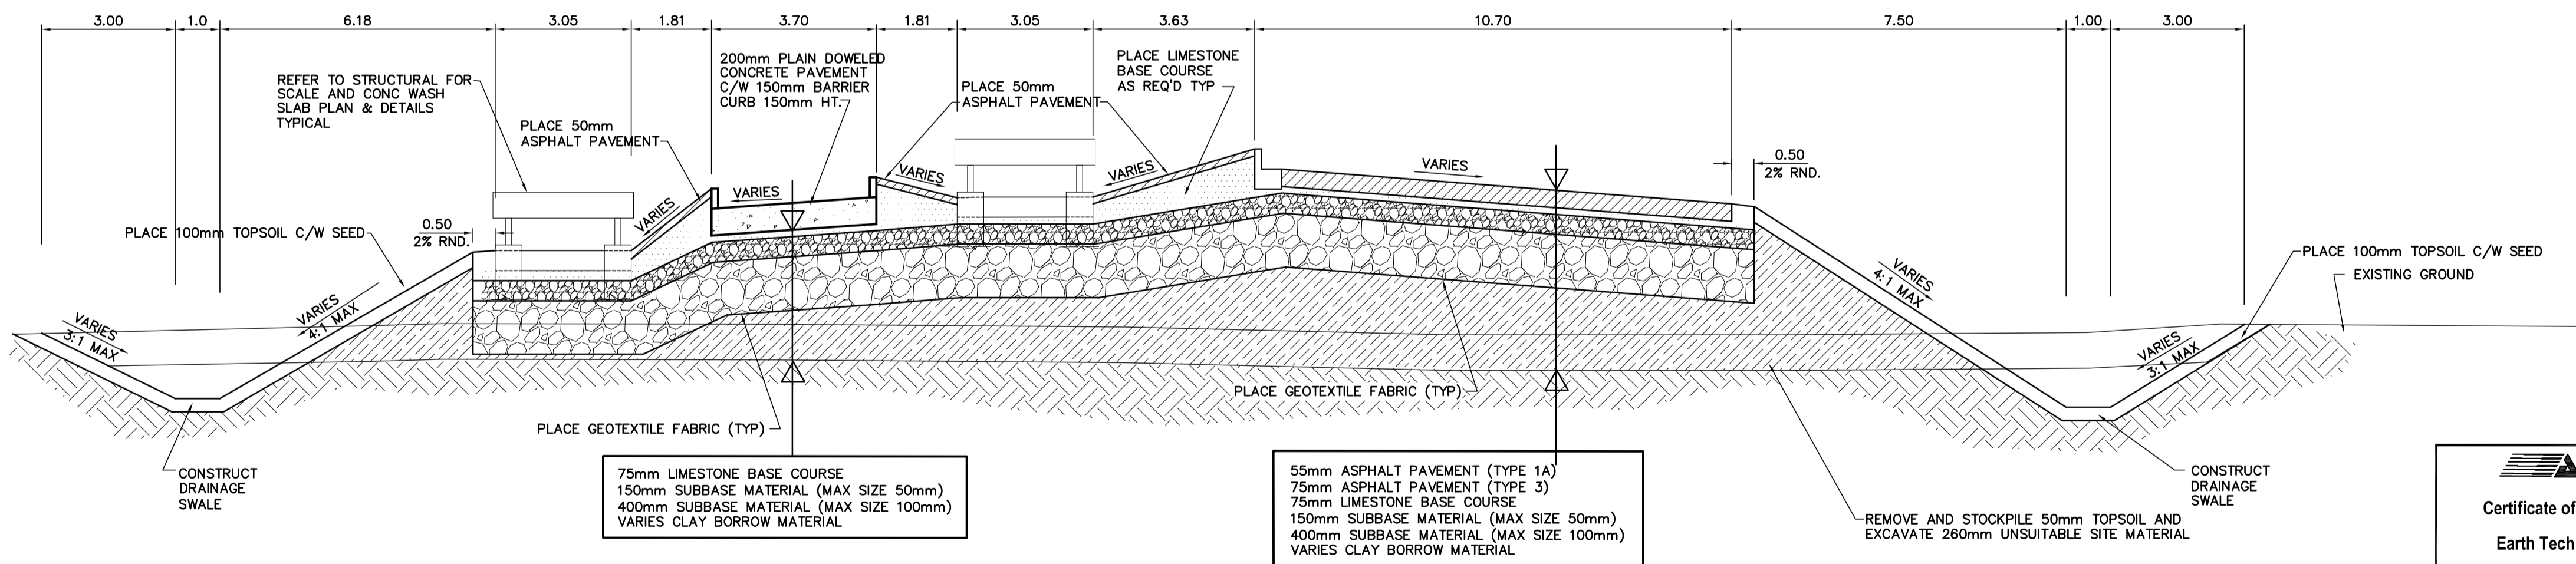

3 PAVEMENT SECTION
C1.03 SCALE H=1:100 V=1:33

- REFERENCE NOTES
- A. REFER TO DWG C1.01 FOR HORIZONTAL GEOMETRY
 - B. REFER TO DWG C1.02 FOR PROPOSED PAVING AND GRADING
 - C. REFER TO ARCHITECTURAL DRAWINGS FOR PROPOSED BUILDING PLAN AND DETAILS
 - D. REFER TO STRUCTURAL DRAWING FOR PROPOSED TRUCK SCALE PLAN AND DETAILS.
 - E. REFER TO ELECTRICAL DRAWINGS FOR PROPOSED ELECTRICAL PLAN AND DETAILS.
 - F. REFER TO ET. FIELD BOOK #4490



METRIC
WHOLE NUMBERS INDICATE MILLIMETRES
DECIMALIZED NUMBERS INDICATE METRES

150 mm W.M.	WATERMAIN	150 mm W.M.	HYDRO	150 mm W.M.	WATERMAIN
◇	HYDRANT	+	M.T.S.	+	HYDRANT
⊙	VALVE	⊙	CONCRETE	+	VALVE
300mm L.D.S.	LAND DRAINAGE SEWER	300mm L.D.S.	ASPHALT	+	LAND DRAINAGE SEWER
250mm W.W.S.	WASTEWATER SEWER	250mm W.W.S.	PROPERTY LINE	+	WASTE WATER SEWER
○	MANHOLE	⊕	SURVEY BAR	+	⊕ PROFILE
□	CATCH BASIN	232.750	ELEVATION	⊕	N/W GUTTER
▽	CURB INLET	300φ	TREE	○	S/E GUTTER
+	JUNCTIONS	+	SIDEWALK RAMP	◇	N/W PROPERTY LINE
+	CULVERT	+	CONCRETE SIDEWALK	○	S/E PROPERTY LINE
+	GAS	+	FENCE	+	
EXISTING	LEGEND - PLAN	PROPOSED	EXISTING	LEGEND - PLAN	PROPOSED
EXISTING	LEGEND - PROFILE	PROPOSED	EXISTING	LEGEND - PROFILE	PROPOSED

LOCATION APPROVED UNDERGROUND STRUCTURES

SUPV. U/G STRUCTURES DATE COMMITTEE

NOTE:
LOCATION OF UNDERGROUND STRUCTURES AS SHOWN ARE BASED ON THE BEST INFORMATION AVAILABLE, BUT NO GUARANTEE IS GIVEN THAT ALL EXISTING UTILITIES ARE SHOWN OR THAT THE GIVEN LOCATIONS ARE EXACT. CONFIRMATION OF EXISTENCE AND EXACT LOCATION OF ALL SERVICES MUST BE OBTAINED FROM THE INDIVIDUAL UTILITIES BEFORE PROCEEDING WITH CONSTRUCTION.

B.M. ELEV.			
NO.	REVISIONS	DATE	BY
0	357-2007 ADDENDUM 1	07/07/27	BC

DESIGNED BY	BC	CHECKED BY	JRM
DRAWN BY	BC	APPROVED BY	TGS
SCALE:	AS NOTED	RELEASED FOR CONSTRUCTION BY:	V. JEANCART
NO.	REVISIONS	DATE	2007/07
DATE	2007/07/20		

ENGINEER'S SEAL

PROVINCE OF MANITOBA ORIGINAL SIGNED BY J.R. McCUTCHON 2007/07/20 REGISTERED PROFESSIONAL ENGINEER

CONSULTANT DRAWING NO. C1.05

THE CITY OF WINNIPEG
Winnipeg **SOLID WASTE SERVICES DIVISION**

BRADY RD. LANDFILL NEW ENTRANCE AND SCALE FACILITY

PAVEMENT SECTIONS

CITY FILE NUMBER

SHEET 5 OF 5

CITY DRAWING NUMBER SWD-D-392