
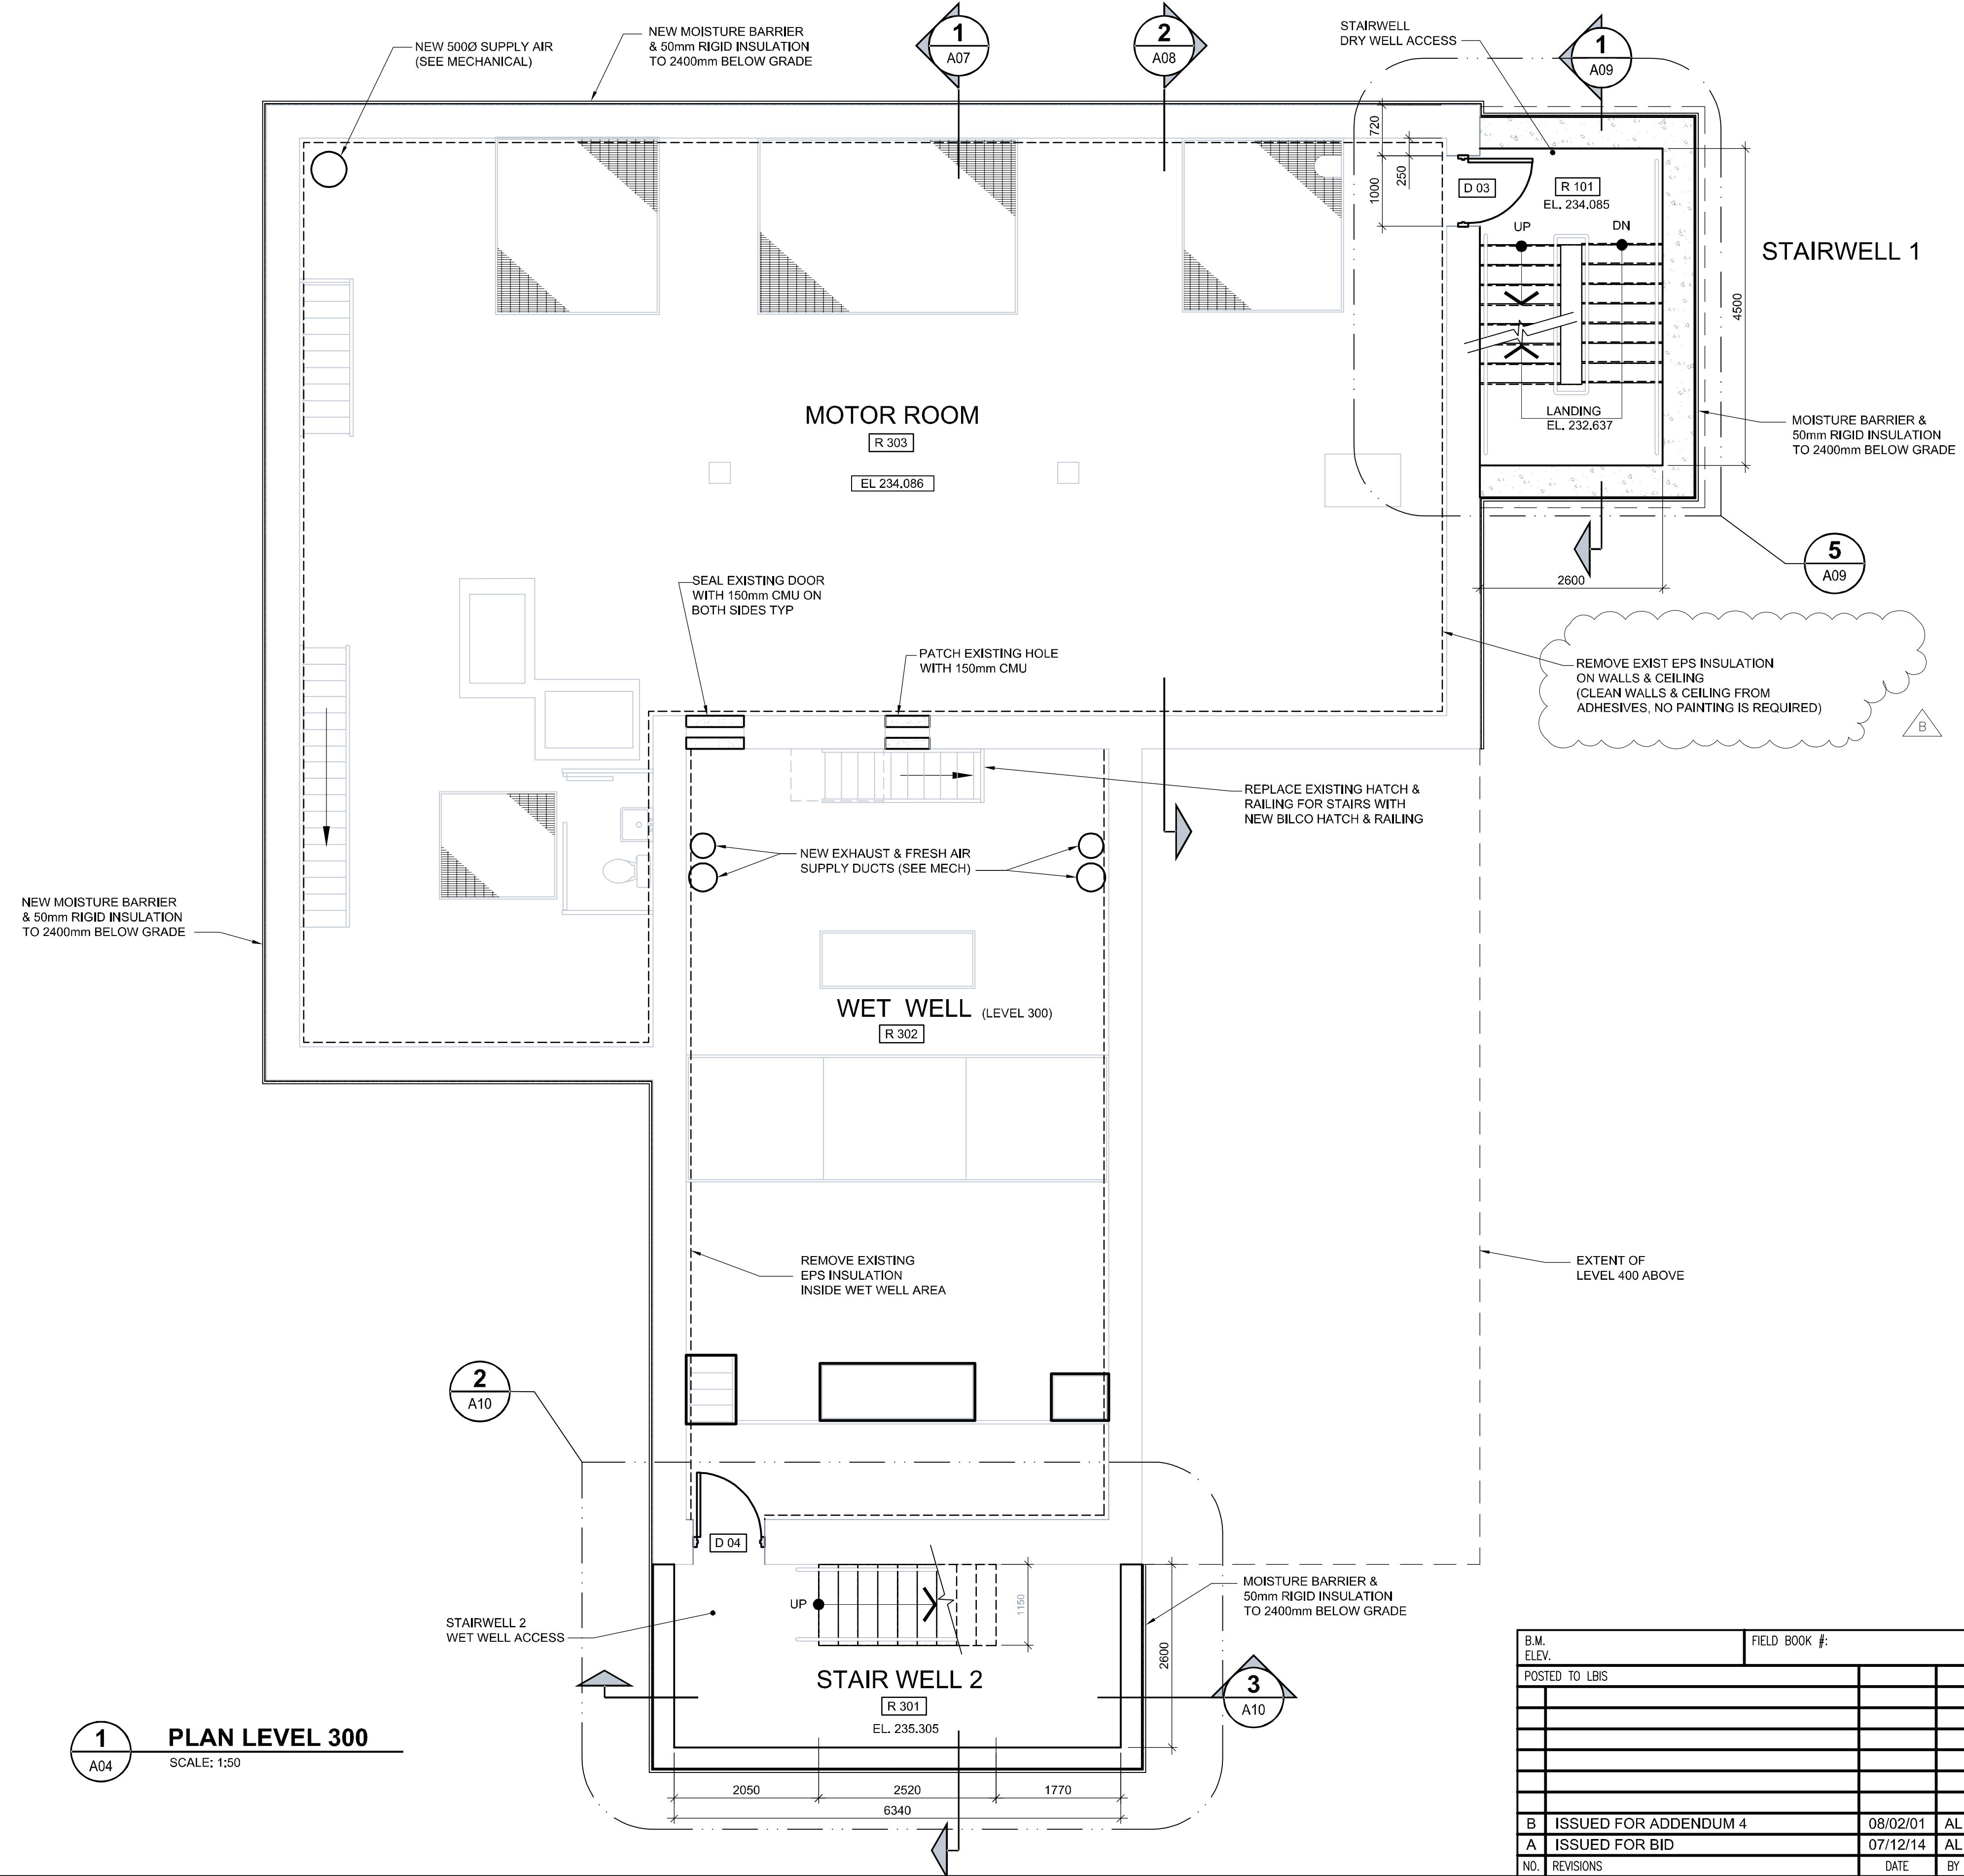


D SIZE 22" x 34" (559mm x 864mm)

PLOT: 2/1/2008 11:18:35 AM

NCA FILE NAME: A0004-AR L300.dwg Saved By: amercio.j

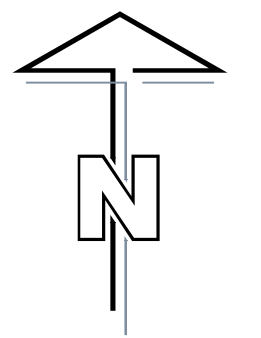

1 PLAN LEVEL 300
SCALE: 1:50

B.M. ELEV.	FIELD BOOK #:	Neil Cooper Architect Inc. 10-395 Berry Street, Winnipeg, Manitoba R3J 1N6 Phone (204) 985-3855 Fax (204) 831-7148	
POSTED TO LBIS		DESIGNED BY NC	CHECKED BY -
		DRAWN BY CGC/AL	APPROVED BY -
		HOR. SCALE AS NOTED	RELEASED FOR CONSTRUCTION
		VERTICAL AS NOTED	
B ISSUED FOR ADDENDUM 4	08/02/01	AL	DATE 07/06/14 DATE
A ISSUED FOR BID	07/12/14	AL	
NO. REVISIONS	DATE	BY	FILENAME: A0004-AR L300.dwg



APEGN
Certificate of Authorization
UMA Engineering Ltd. (MB)
No. 256 Date: 07/12/14

ENGINEER'S SEAL
REVISION - A
ISSUED FOR BID
WAS SEALED BY
NEIL COOPER
AND DATED
DEC 14, 2007

THE CITY OF WINNIPEG
WATER AND WASTE DEPARTMENT
Winnipeg
PERIMETER ROAD PUMPING STATION UPGRADES
Contract B - Building Upgrades
Architectural - New Construction
LEVEL 300 FLOOR PLAN
CITY DRAWING NUMBER
1-0111L-A0004 SHEET REV. SIZE
001 B D