


FILE NAME: 0602-AS.1.dwg | DATE: 2007 June 12 | DESCRIPTION: ROOM FINISH AND DOOR SCHEDULES | PROJECT No: 06024 | ADDRESS: 999 Sargent Ave, Winnipeg, MB

ROOM NO	ROOM NAME	FLOOR		WALLS												CEILING			COMMENTS			
		MAT	COLOUR	BASE	NORTH				EAST				SOUTH				MAT	FINISH		COLOUR	HGT	AFF
					GL	HC	PT	PT	GL	HC	PT	PT	GL	HC	PT	PT						
101	VESTIBULE	RU	PEACOCK	RCB	1	GL	X	X	X	GL	X	X	X	GL	X	X	X	ALUM	X	X	2700	

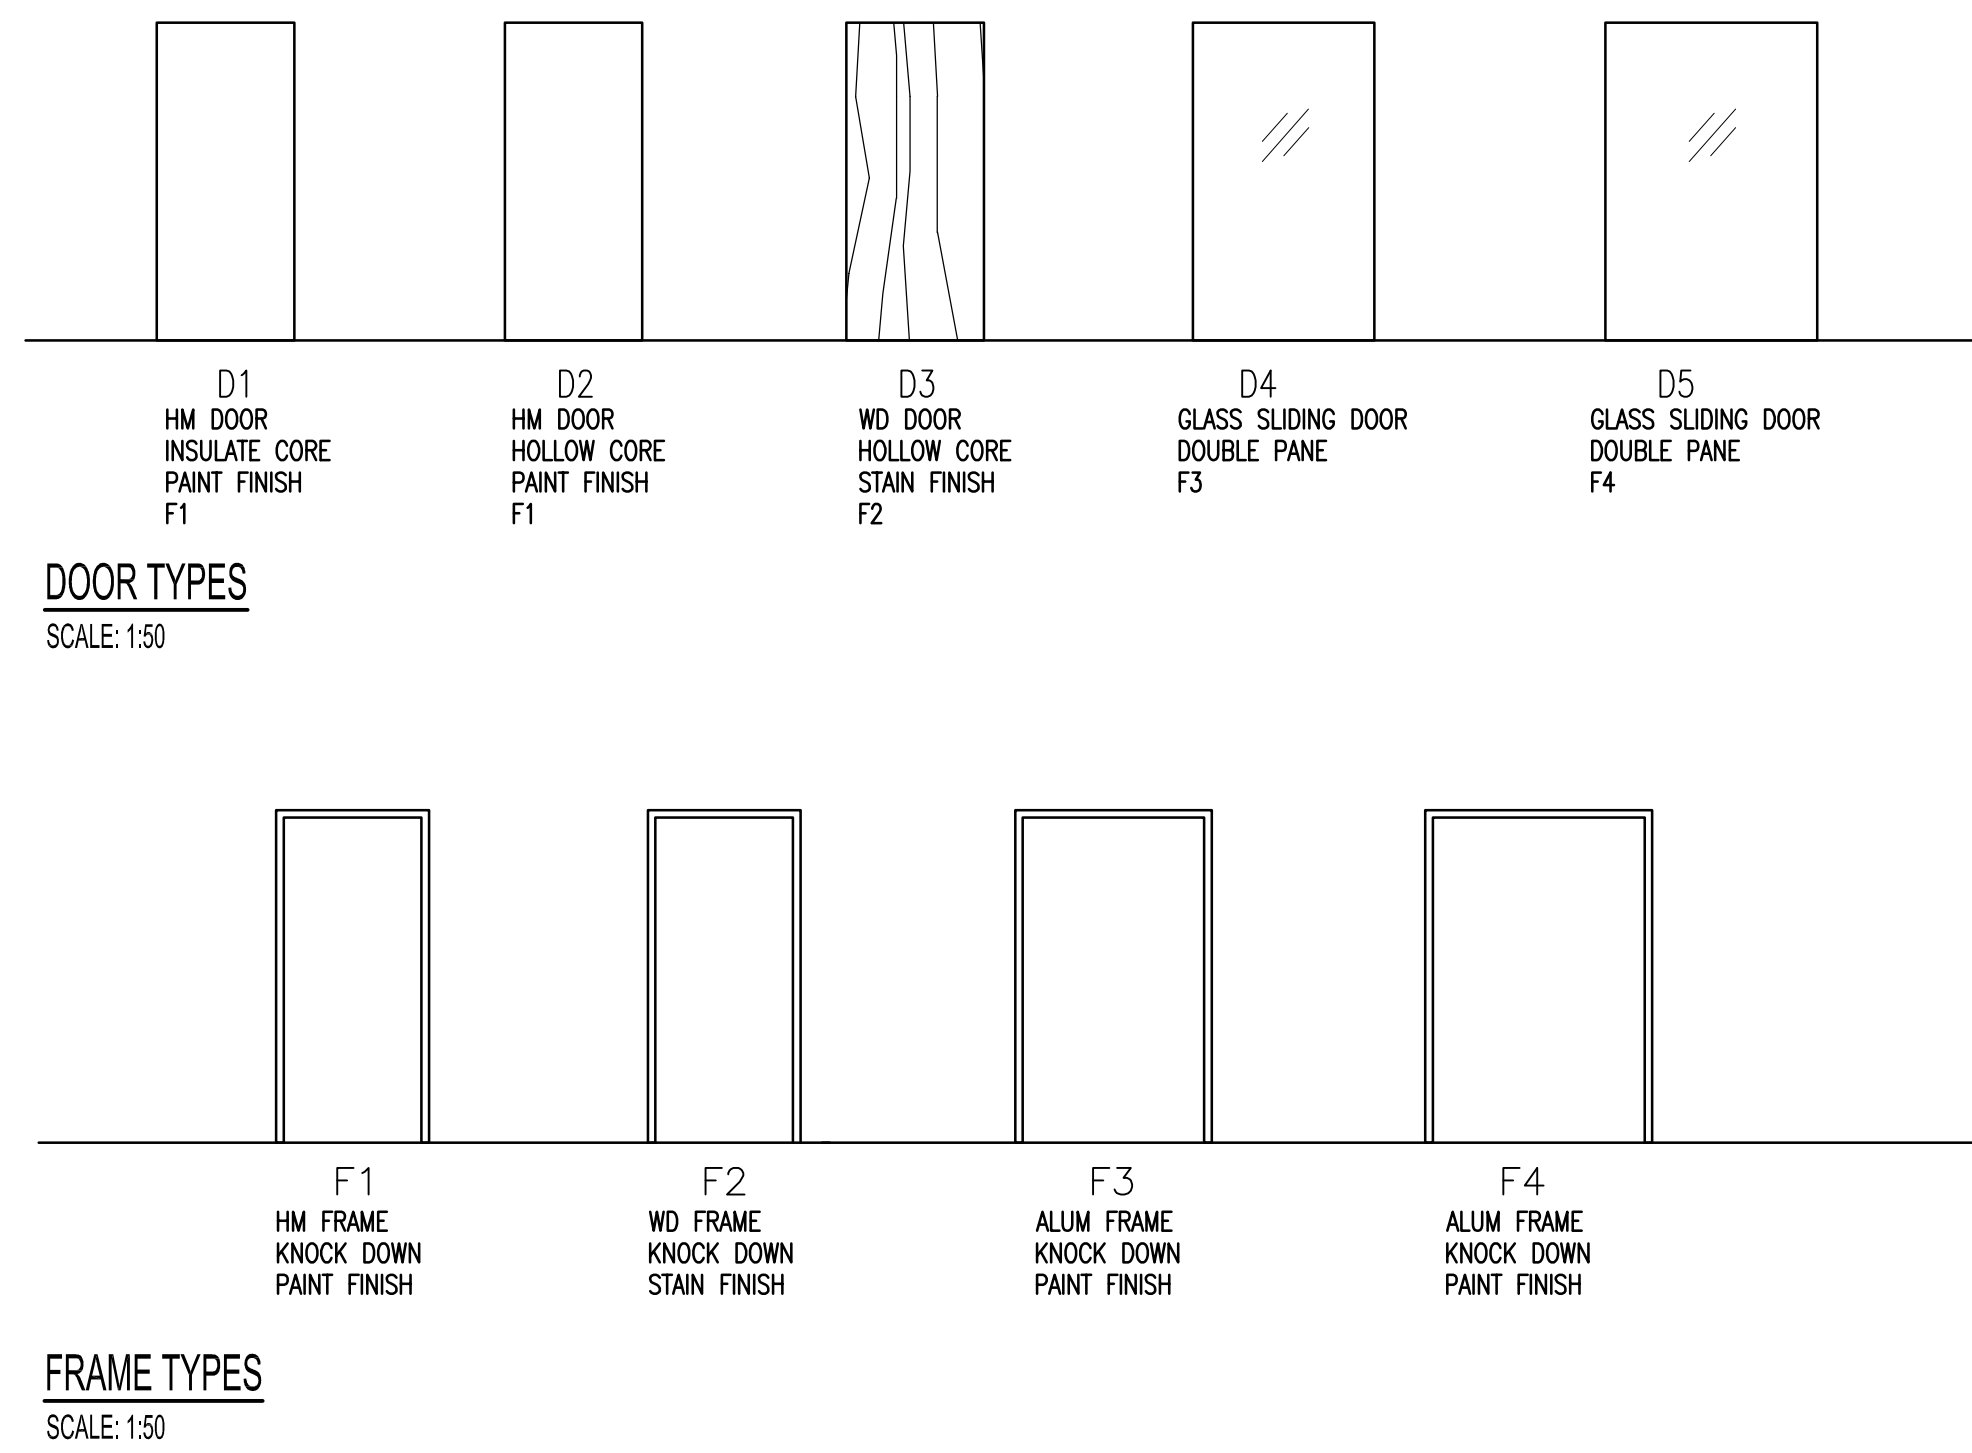

DOOR NO	TO ROOM	SIZE	DOOR		FRAME		HOW GROUP	FIRE RATING	GRILLES	COMMENTS								
			SWING	TYPE	MAT	CORE					FINISH	COLOUR						
D101A	VESTIBULE	1400x2100	SLIDING	5	GLS	HC	N/A	A	F4	ALUM	KD	PT	A	1	N/A	N/A		

LEGEND:

CT - CERAMIC TILE
 RU - RUBBER FLOORING
 WD - PRE-FIN HARDWOOD
 CPT - CARPET TILE
 CP - CARPET ROLL GOODS
 CMU - CONCRETE MASONRY UNIT
 GL - ALUMINUM FRAMED GLAZING
 CONC - CONCRETE
 ACT - ACOUSTIC TILE SYSTEM
 SS - SUSPENDED STUCCO PANELS
 VCB - VINYL COVERED BASE

LEGEND:

RHR - RIGHT HAND REVERSE
 LHR - LEFT HAND REVERSE
 RH - RIGHT HAND
 LH - LEFT HAND
 HM - HOLLOW METAL
 WD - WOOD
 GLS - GLASS
 INSUL - INSULATE
 HC - HOLLOW CORE
 ST - STAIN
 KD - KNOCK DOWN
 PT - PAINT

MATERIAL LIST

SOLID SURFACE DIAMASTONE BY SMDs
 BEIGE DUNA 3/4 THICK

ALL CERAMIC TILE TO BE CENTURA COLLECTIONS SERIES: JUPITER

CERAMIC TILE TYPE 1
 24", 24" GRIFITO
 GROUT FLEXITILE NORTH SEA GREY 663

CERAMIC TILE TYPE 2
 24", 24" GRIFITO
 GROUT FLEXITILE JET BLACK 653

CERAMIC TILE TYPE 3
 24", 24" MARRON POLISHED
 GROUT FLEXITILE JET BLACK 653

CERAMIC TILE TYPE 4
 24", 24" GRIS POLISHED
 GROUT FLEXITILE SMOKE 681

CERAMIC TILE TYPE 5
 24", 24" GRIS POLISHED
 GROUT FLEXITILE SMOKE 681

CERAMIC TILE TYPE 6
 24", 24" BLACK POLISHED
 GROUT FLEXITILE JET BLACK 653

SPORT FLOORING TYPE 1
 MONDO
 SPORT IMPACT COLOR DARK GREY 018

SPORT FLOORING TYPE 2
 MONDO
 SPORT IMPACT COLOR 008 BLACK

SPORT FLOORING TYPE 3
 MONDO
 RAMFLEX 6790 SOLID BLACK

SPORT FLOORING TYPE 4
 MONDO, SPORTFLEX
 P30 RED
 10MM THICK, ROLLED RUBBER
 RUNNING TRACK PAINTED GAME LINES, AS PER DRAWING OR OWNER

RUBBER FLOORING TYPE 1
 MONDO
 TERRANOVA, 406 STONE GREY

RUBBER FLOORING TYPE 2
 MONDO
 TERRANOVA, 448 PEACOCK

RUBBER COVE WALL BASE TYPE 1
 JOHNSONITE
 COLOR: 38 PEWTER
 SIZE: 4.375" TIGHTLOCK RESILIENT

RUBBER COVE WALL BASE TYPE 2
 JOHNSONITE
 COLOR: 09 CLAY
 SIZE: 4.375" TIGHTLOCK RESILIENT

STAIR NOSINGS
 RITE GRIP
 COLOR: 01 BLACK
 MODEL: 7700 PROBLEM SOLVER
 2" SAFETY YELLOW AT LANDINGS

NOTES :

THESE DRAWINGS SHALL NOT BE SCALED.

THE CONTRACTOR SHALL VISIT THE SITE AND SATISFY HIMSELF ALL DIMENSIONS, DATUM AND DETAILED INFORMATION SHOWN ARE CORRECT.

THE CONTRACTOR IS TO REVIEW AND COORDINATE ALL ARCHITECTURAL, MECHANICAL, ELECTRICAL AND STRUCTURAL DRAWINGS FOR ADDITIONAL OPENINGS THROUGH FLOORS, WALLS, AND CEILINGS FOR DUCT, PIPE & ELECTRICAL RISERS AND ALL OPENINGS NOT SHOWN ON DRAWINGS.

ALL OPENINGS THROUGH FIRE ASSEMBLIES ARE TO BE FIRE STOPPED AND SEALED WITH ULC APPROVED FIRE STOPPING TO MAINTAIN THE INTEGRITY OF THE FIRE SEPARATION AND PROVIDE A SMOKE-TIGHT BARRIER.

ALL PRODUCTS AND MATERIALS TO BE USED AND INSTALLED SHALL CONFORM WITH MANUFACTURER'S SPECIFICATIONS & APPLICABLE CODES.

THE CONTRACTOR SHALL BE RESPONSIBLE TO PATCH AND MAKE GOOD ALL EXISTING CONSTRUCTION AFFECTED BY THE REMOVAL OF ALL ITEMS FORMING THE PART OF THE RENOVATION WORK.

WHERE NEW FLOORING AND BASE IS TO BE INSTALLED IN EXISTING AREAS (REFER TO FLOOR PLAN AND ROOM SCHEDULE) THE EXISTING FLOORING SURFACE AND BASE MUST BE REMOVED, UNLESS OTHERWISE NOTED. ALL FLOOR SURFACES SHALL BE PREPARED IN ACCORDANCE TO MANUFACTURER'S RECOMMENDATIONS FOR INSTALLATION OF NEW FLOOR.

WHERE PAINTING OF EXISTING WALLS IS INDICATED ON THE ROOM SCHEDULE, THESE WALLS MUST BE CLEANED OF ANY EXISTING WALL COVERING, PATCHED & PREPARED TO ACCEPT NEW MATERIAL UNLESS OTHERWISE NOTED.

NO.	REVISION/DESCRIPTION	BY	DATE
02	ADDENDUM NO. 1	DG	AUG 10/07
01	ISSUED FOR PERMIT	DG	AUG 28/07
00	ISSUED FOR TENDER	DG	JUL 24/07

SEALS

DRAWN BY: CAD | CHECKED BY: USER APPROVAL | APPROVED

DATE: 2007 June 12

**CITY OF WINNIPEG
 PLANNING, PROPERTY & DEVELOPMENT DEPARTMENT
 CIVIC ACCOMMODATIONS DIVISION
 300 - 65 GARRY ST. R3C 4K4**

PROJECT: CONSTRUCTION OF CINDY KLASSEN RECREATION COMPLEX FACILITY ENHANCEMENT PROJECT
 999 Sargent Ave, Winnipeg, MB

SHEET TITLE: ROOM FINISH AND DOOR SCHEDULES

SCALE: AS SHOWN | PROJECT NO: 2005-059 | SHEET NO: A8.1

DRAWING SHEET SIZE: A1 (841mm x 594mm) PLOT 1:1