


UMA FILE NAME: F953-001-01_01-M2-2004_RX.dwg
 ADDRESS: 999 Sargent St. Winnipeg, Manitoba
 PROJECT No: F953-001-01
 DESCRIPTION: ROOF PLAN HVAC
 DATE: 2007.02.21
 FILE NAME: F953-001-01_01-M2-2004_RX.dwg

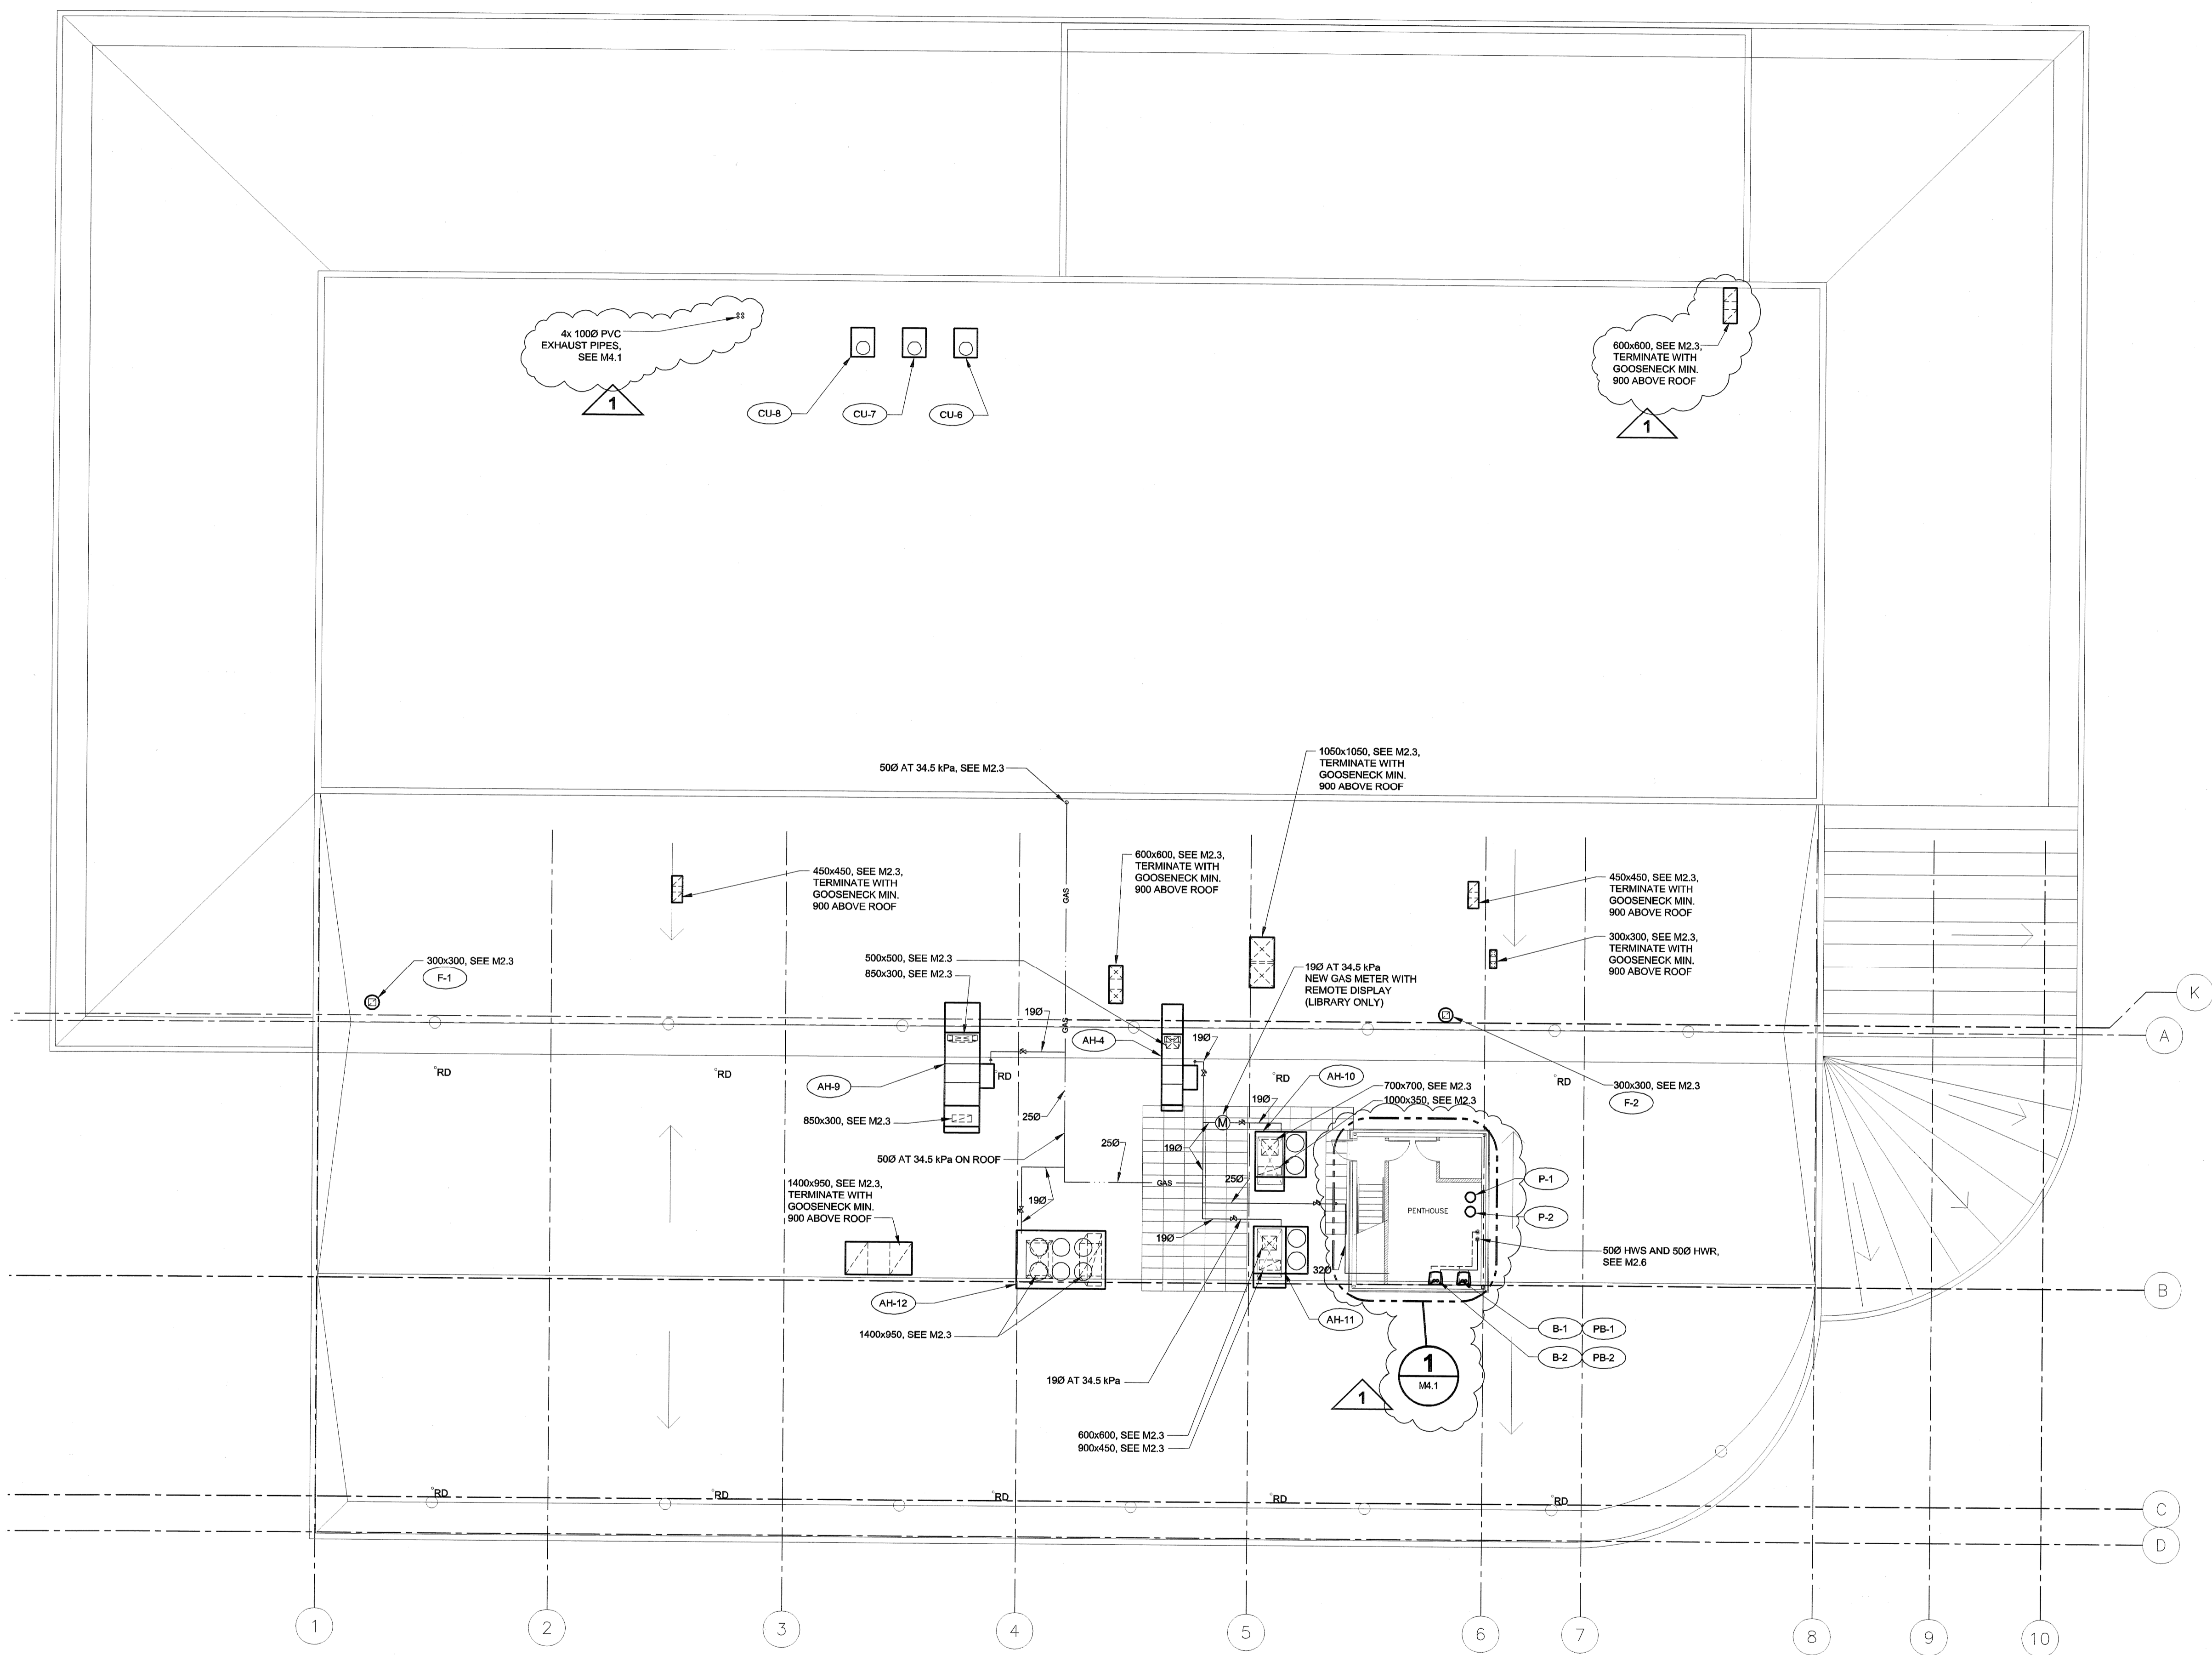

PLAN
 1 M2.4
 0 1500 3000 4500 mm SCALE 1:150
 ROOF PLAN HVAC NEW CONSTRUCTION

UMA | AECOM
 © 2007 UMA ENGINEERING LTD. ALL RIGHTS RESERVED.

APEGM
 Certificate of Authorization
 UMA Engineering Ltd. (MB)
 No. 256 Date: 07/08/22

UMA AECOM REVIEW

NO.	REVISION/DESCRIPTION	BY	DATE
1	ISSUED FOR ADDENDUM #2	RJP	07/08/21
0	ISSUED FOR TENDER	RJP	07/07/23

SEALS

PROVINCE OF MANITOBA
 REGISTERED PROFESSIONAL ENGINEER
 B. M. PETERSON

DRAWN BY: RJP
 CHECKED BY: USER APPROVAL
 DATE: 2007.07.17

CITY OF WINNIPEG
 PLANNING, PROPERTY & DEVELOPMENT DEPARTMENT
 CIVIC ACCOMMODATIONS DIVISION
 300 - 65 GARRY ST. R3C 4K4

PROJECT
 Construction of Cindy Klassen
 Recreation Complex Facility
 Enhancement Project
 999 Sargent St. Winnipeg, Manitoba

SHEET TITLE
 Mechanical
 Roof Plan HVAC
 New Construction

SCALE 1:150	PROJECT NO. 2005-059	SHEET NO. M2.4
----------------	-------------------------	-------------------

DRAWING SHEET SIZE: A1 (841mm x 594mm) PLOT 1:1