



SITE PLAN
SCALE: 1:250

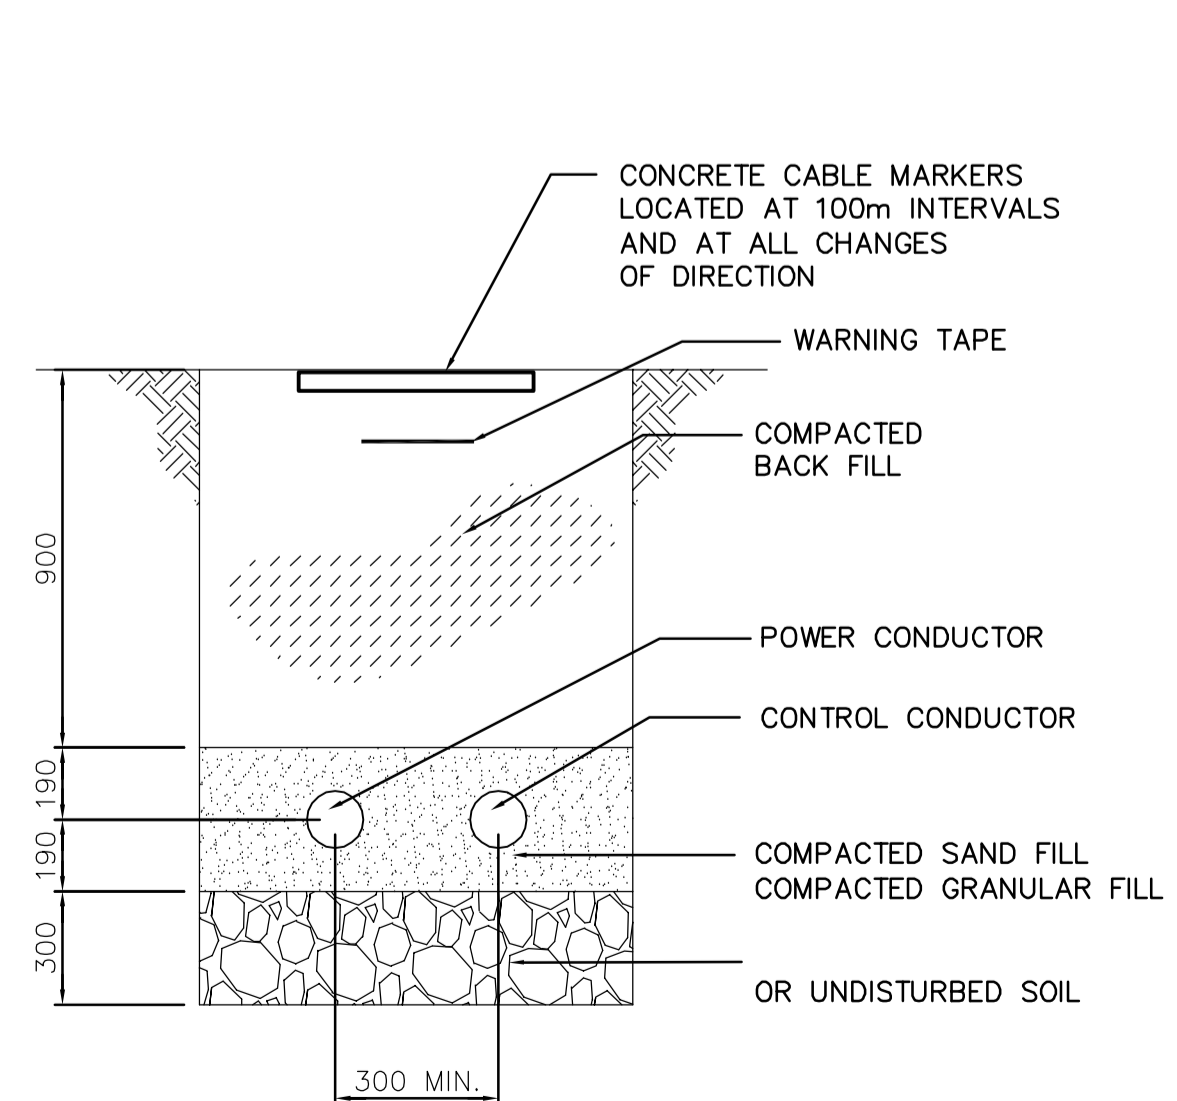

1 SECTION - CABLE TRENCH
N.T.S.

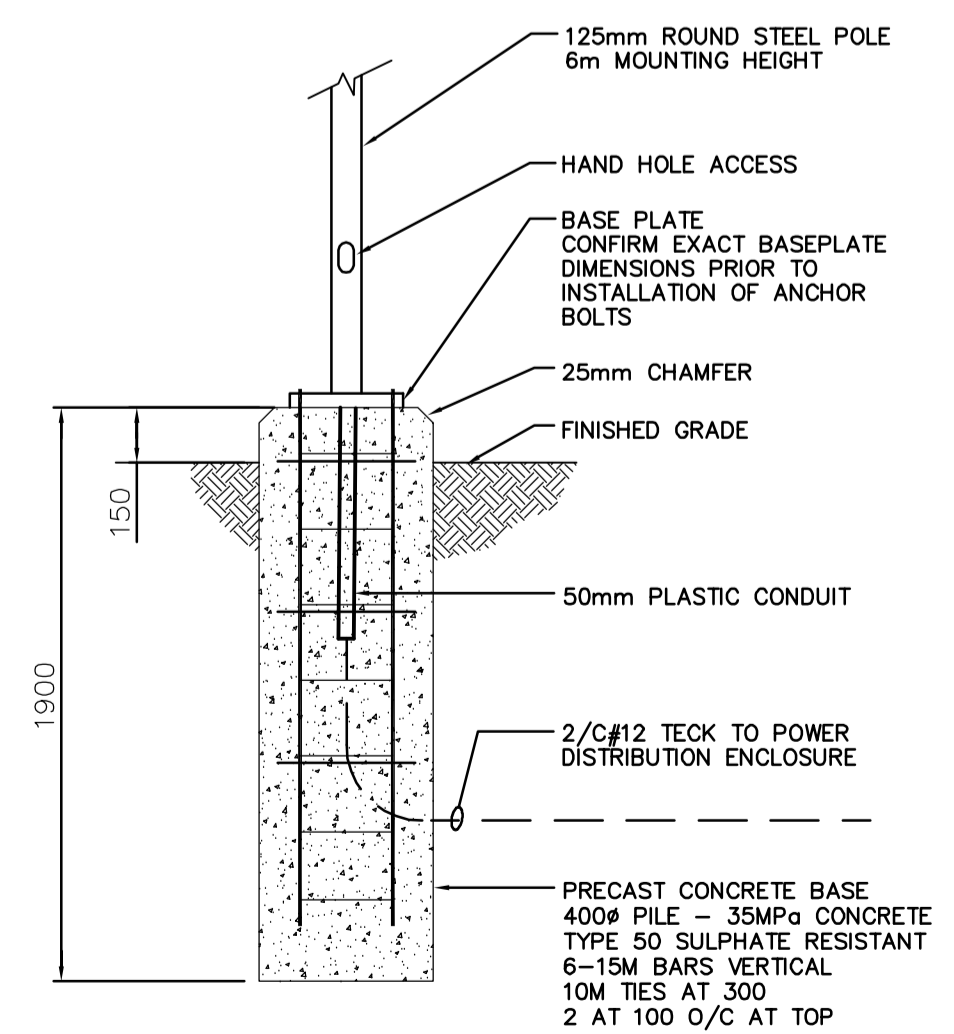

F DETAIL - POLE BASE
N.T.S.

DRAWING NOTES

- ①
- ② THE 3 NEW 150mm CONDUITS ARE TO BE USED AS FOLLOWS:
1 CONDUIT FOR POWER CONDUCTORS
1 CONDUIT FOR CONTROL CONDUCTORS
1 CONDUIT FOR TELEPHONE CABLE.
REFER TO SPECIFICATIONS FOR TYPES AND AMOUNTS OF CONDUCTORS

APECM
Certificate of Authorization
Earth Tech Canada Inc.
No. 730 Expiry: April 30, 2007

NO.	REVISIONS	DATE	BY
03	94-2007 ADDENDUM 4	07-06-07	CPG
02	94-2007 ADDENDUM 2	07/05/22	ERC
01	REVISED CABLE LAYOUT	07/04/05	ERC
00	ISSUED FOR TENDER (94-2007)	07/02/20	ERC

CH2M HILL
Frederickson Cooper ARCHITECTS

EarthTech
A Tyco International Ltd. Company

DESIGNED BY	ERC	CHECKED BY	PS
DRAWN BY	ERC	APPROVED BY	AHL
SCALE:	AS SHOWN	RELEASED FOR CONSTRUCTION BY:	R.SOROKOWSKI
DATE	07/02/19	DATE	2006/02/22

ENGINEER'S SEAL
ORIGINAL SIGNED BY
P. STRYK
2006/02/20
CONSULTANT DRAWING NO.
WH-E0100

THE CITY OF WINNIPEG
WATER AND WASTE DEPARTMENT
ENGINEERING DIVISION

WATER TREATMENT PLANT
SITE UTILITES

ELECTRICAL
SITE PLAN

CITY FILE NUMBER	
SHEET	OF
CITY DRAWING NUMBER	1-0601H-A-E0100-001-030