
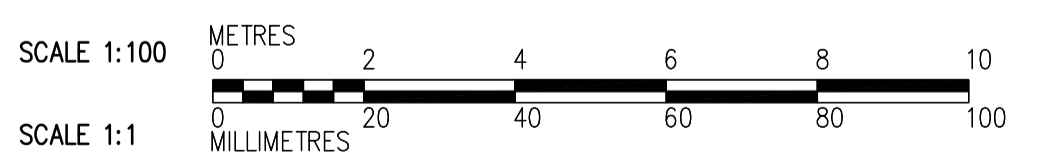


FIRST FLOOR PLAN  
1:100

- NOTES:**
- FOR STAIRS AND HANDRAILS TO PLATFORMS AT ALL LEVELS, SEE ARCHITECTURAL DRAWINGS.
  - COORDINATE ALL FABRICATION WITH BO 742-2005 CONTRACTOR.

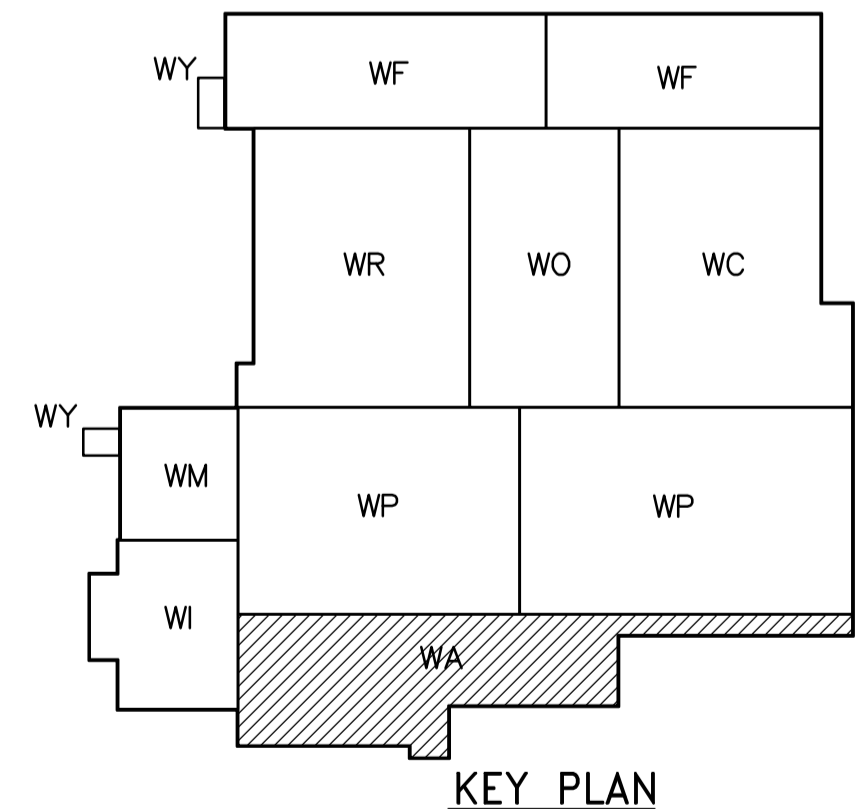

 Certificate of Authorization CH2M HILL Canada Ltd. No. 1441 Expiry: April 30, 2008	 Frederickson Cooper ARCHITECTS		 A Tyco International Ltd. Company		ENGINEER'S SEAL  ORIGINAL SIGNED BY C. MILITANO  2007/06/05	 THE CITY OF WINNIPEG WATER AND WASTE DEPARTMENT ENGINEERING DIVISION  WATER TREATMENT PLANT ADMINISTRATION OFFICE AND PLANT INTERIOR FINISHES  STRUCTURAL ADMINISTRATION AREA FIRST FLOOR PLAN	CITY FILE NUMBER
	DESIGNED BY EL	CHECKED BY AP	CONSULTANT DRAWING NO. WA-S4116		SHEET OF		
	DRAWN BY CR	APPROVED BY AHL	RELEASED FOR CONSTRUCTION BY: R. SOROKOWSKI		CITY DRAWING NUMBER 1-0601A-A-S4116-001-02D		
	SCALE: 1:100	DATE 2007/06/12	DATE 2007/05/06				
NO. REVISIONS 02 95-2007 ADDENDUM 2 07/06/18 MH 01 ADDENDUM 1 07/06/12 MH 00 ISSUED FOR TENDER 07/06/05 EL	DATE 2007/06/12	DATE 2007/05/06					