

NOTES :

GENERAL NOTES


- 1 PROVIDE INSTALL 80mm X 150mm LAMACOID WITH INFORMATION AS DETAILED IN THIS DRAWING

NOTE 1

INCOMING FEEDER	B2-1 P-8 HIGH TEMP LOOP CIRCULATOR PUMP 1.5 HP 15A CB NEMA SIZE 1	SPARE
	B2-2 P-10 BUILDING LOOP PUMP 2 HP 15A CB NEMA SIZE 1	SPARE
T.V.S.S.	B2-3 P-11 BUILDING LOOP PUMP 2 HP 15A CB NEMA SIZE 1	SPARE
	B2-4 P-12 FLUID COOLER PUMP 0.75 HP 15A CB NEMA SIZE 1	SPARE
SPARE	B2-5 P-13 PHC PUMP 1 HP 15A CB NEMA SIZE 1	SPARE
	SPARE	SPARE

100 mm HOUSEKEEPING PAD

1 MCC-B - NEW MOTOR CONTROL CENTER
N.T.S.

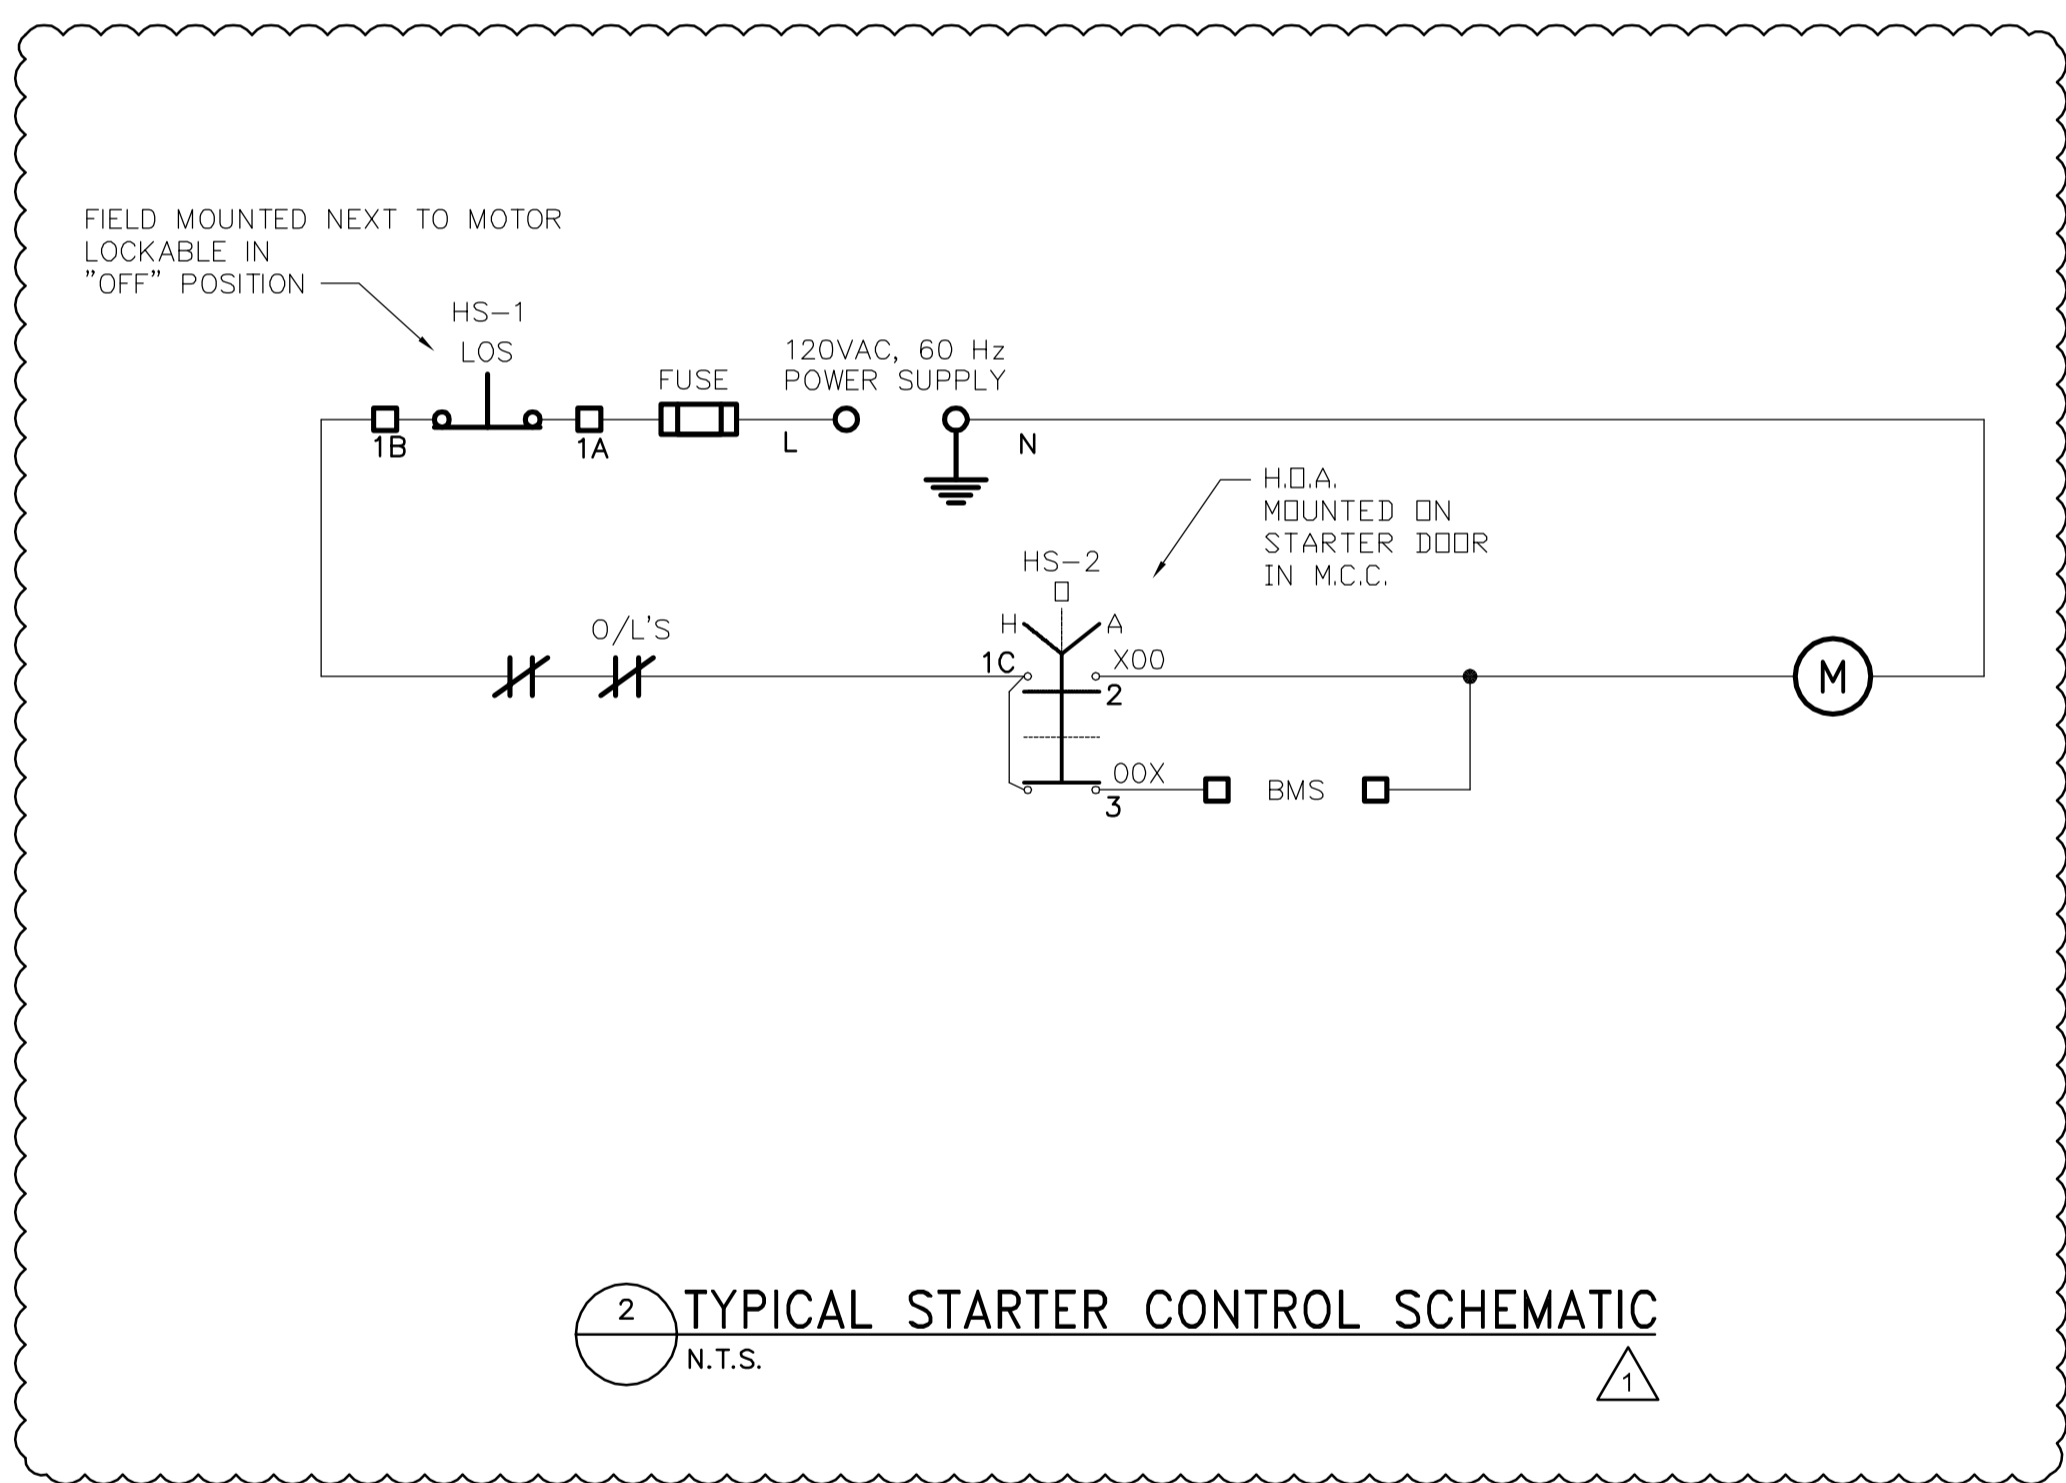

2 TYPICAL STARTER CONTROL SCHEMATIC
N.T.S.

1	ISSUED FOR ADDENDUM 4	ES	2009.01.06
0	ISSUED FOR ADDENDUM 2	ES	2008.12.12
NO.	REVISION/DESCRIPTION	BY	DATE

SEALS



DRAWN BY	DL	CHECKED BY	APPROVED
DATE	2009.01.06	USER APPROVAL	

Winnipeg CITY OF WINNIPEG
PLANNING, PROPERTY AND
DEVELOPMENT DEPARTMENT
CIVIC ACCOMMODATIONS DIVISION
300 - 65 GARRY ST. R3C 4K4

PROJECT
CONFEDERATION BUILDING
SUPPLEMENTARY HEATING UPGRADES
PHASE 1 - CITY BID OPP. NO. 757-2008
457 MAIN STREET, WINNIPEG, MANITOBA

SHEET TITLE
ELECTRICAL
MOTOR CONTROL CENTER
MCC-B



APEGM
Certificate of Authorization
Earth Tech Canada Inc.
No. 730 Expiry: April 30, 2009

AECOM
© 2008 EARTH TECH (CANADA) INC. ALL RIGHTS RESERVED.
THIS DOCUMENT IS PROTECTED BY COPYRIGHT LAW AND MAY NOT BE USED, REPRODUCED OR MODIFIED IN ANY MANNER OR FOR ANY PURPOSE EXCEPT WITH THE WRITTEN PERMISSION OF EARTH TECH (CANADA) INC. DOING BUSINESS AS AECOM (AECOM) OR A PARTY TO WHICH ITS COPYRIGHT HAS BEEN ASSIGNED. AECOM ACCEPTS NO RESPONSIBILITY, AND DENIES ANY LIABILITY WHATSOEVER, TO ANY PARTY THAT USES, REPRODUCES, MODIFIES, OR RELIES ON THIS DOCUMENT WITHOUT AECOM'S EXPRESS WRITTEN CONSENT.

SCALE	PROJECT NO.	SHEET NO.
AS SHOWN	105111	E04