


LUMINAIRE SCHEDULE			
TYPE	MANUFACTURER	CAT. NO.	REMARKS
A	LITHONIA	DMW 2815 120 GER10PS	2 x 28W T-5 RAPID START ENCLOSED FIBREGLASS FLUORESCENT LUMINAIRE
B	LITHONIA	TYRAC 70M 120 CSA PE TYRAC10G FCV	1 x 70W MH MINI WALL PACK WITH VERTICAL CUT-OFF, INTEGRAL PHOTOCELL AND WIRGUARD

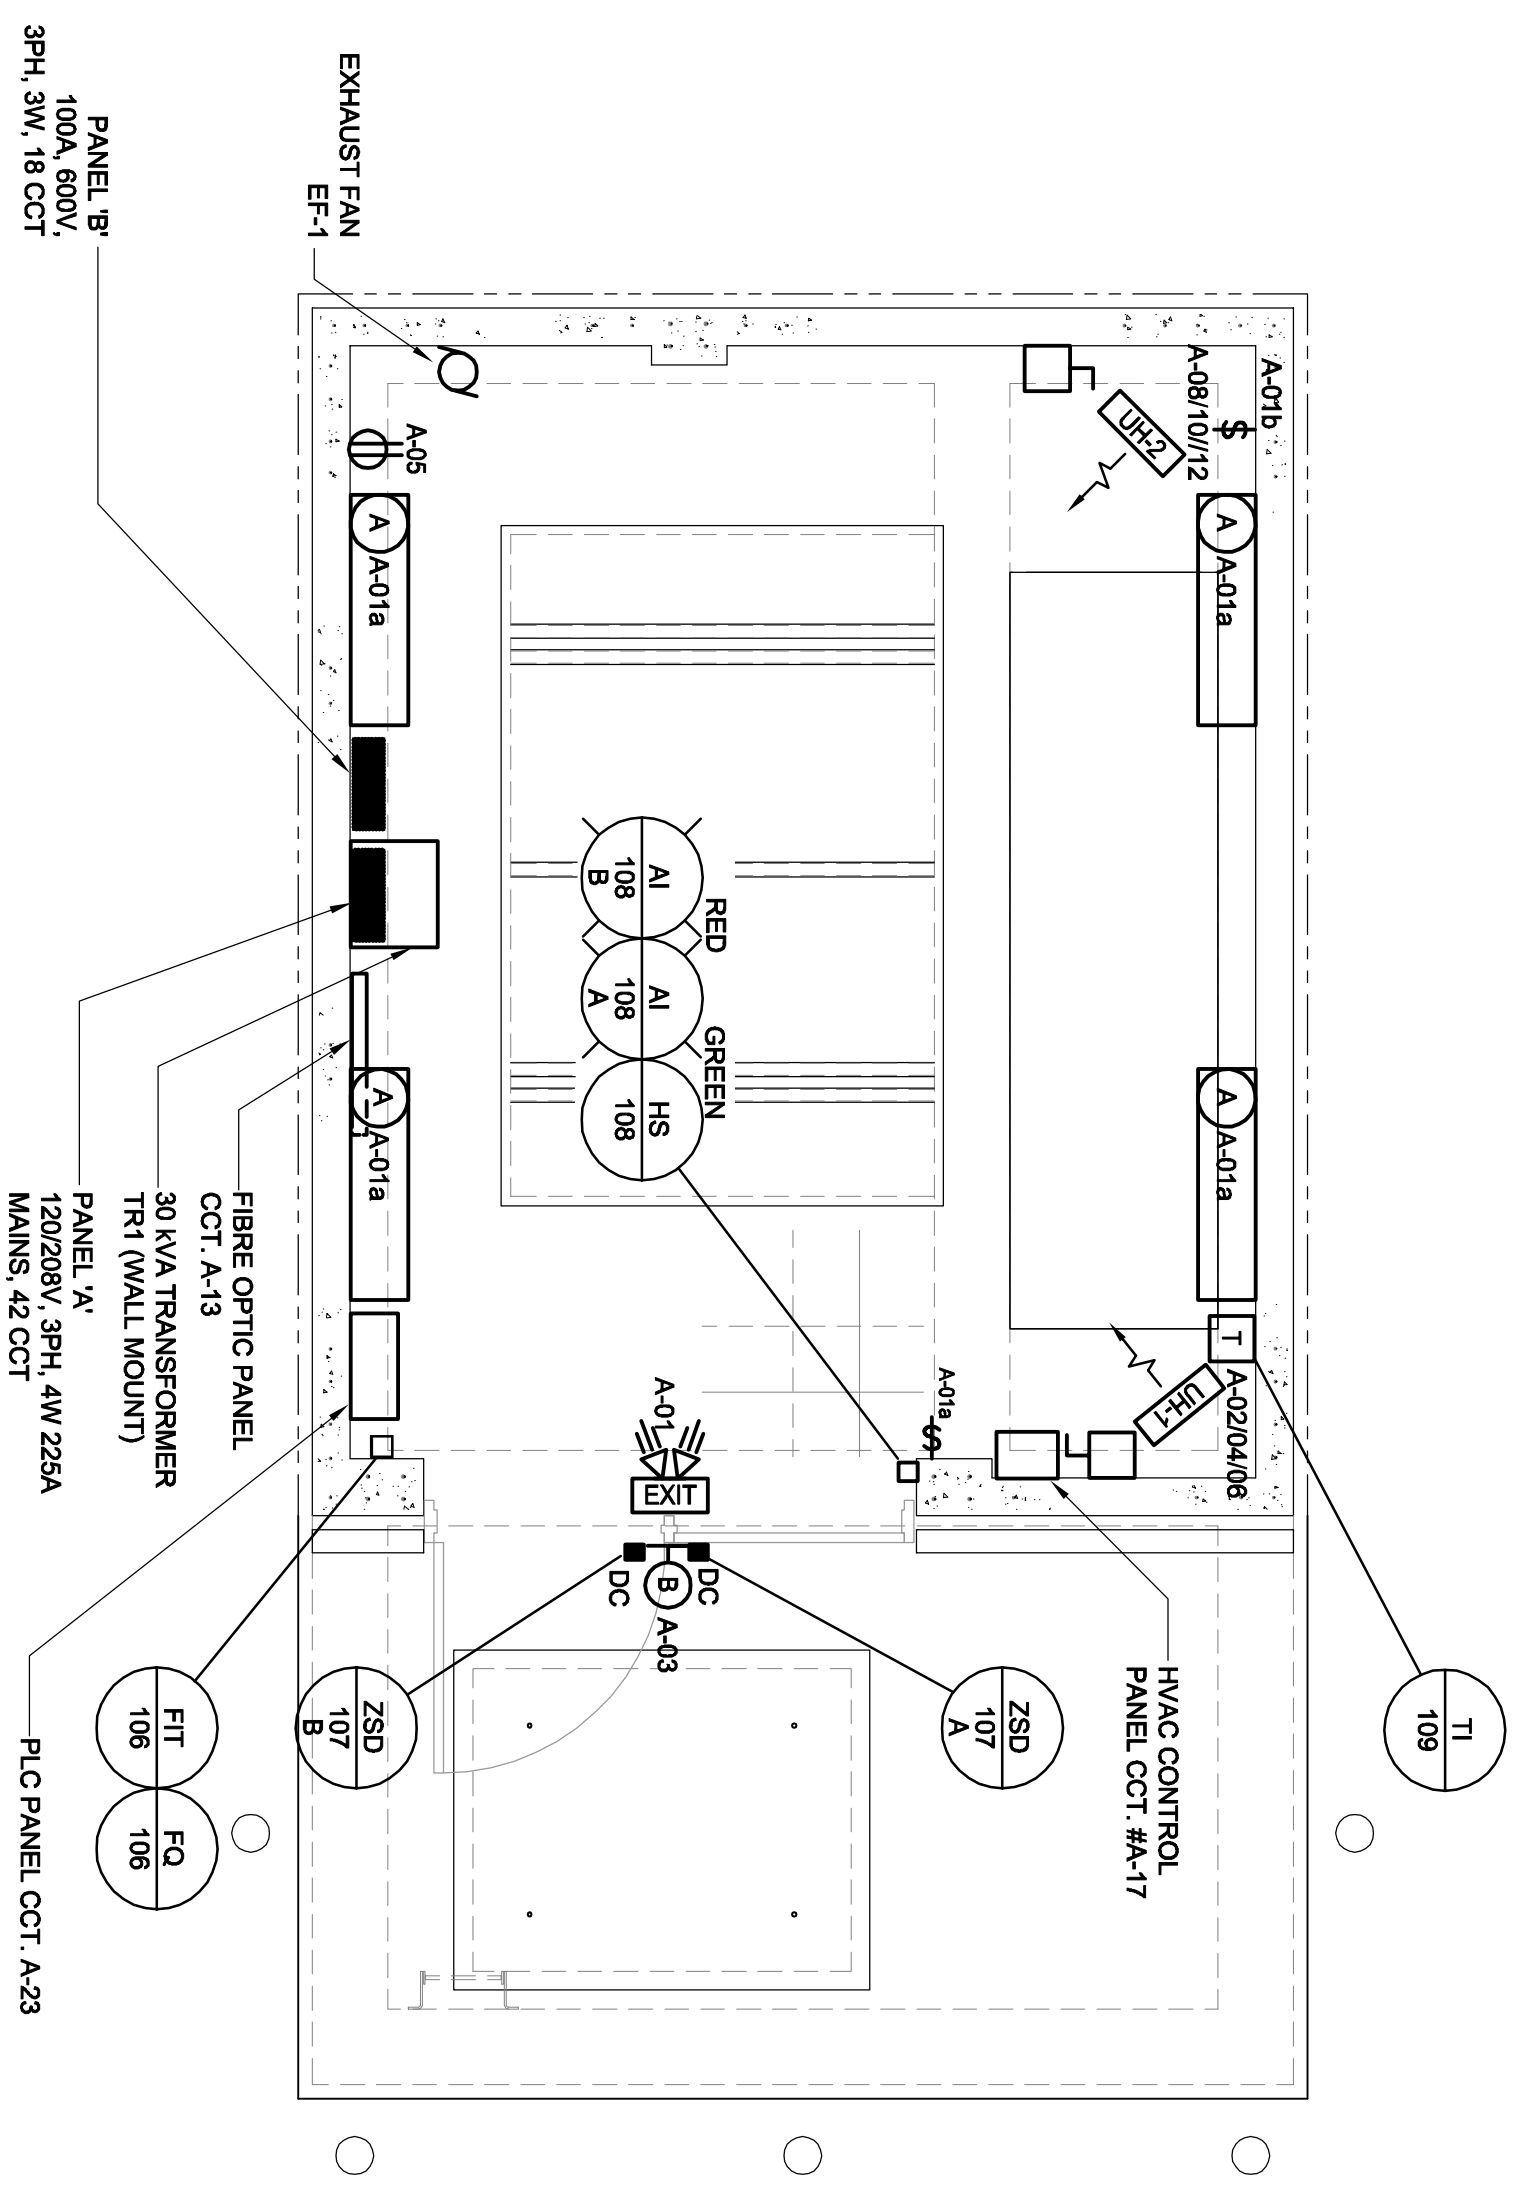

LEGEND	
	GFCI RECEPTACLE
	SURFACE MOUNTED FLUORESCENT
	WALL MOUNTED LIGHT FIXTURE
	SPST SWITCH
	UNIT HEATER
	MOTORIZED DAMPER (SUPPLIED BY OTHERS)
	SELF-POWERED EXIT SIGN / EMERGENCY LIGHTING
	DOOR CONTACTS
	DISCONNECT SWITCH

LOCATION APPROVED
UNDERGROUND STRUCTURES

SUPR. U/G STRUCTURES _____ DATE _____
COMMITTEE _____

NOTE:
LOCATION OF UNDERGROUND STRUCTURES SHALL BE SHOWN ON THE BEST INFORMATION AVAILABLE. THE BEST GUARANTEE IS GIVEN THAT ALL EXISTING UTILITIES ARE SHOWN OR THAT THE GIVEN LOCATIONS ARE EXACT. CONTRACTOR OR SERVICES ARE TO OBTAIN LOCATION OF INDIVIDUAL UTILITIES BEFORE PROCEEDING WITH CONSTRUCTION.

NO.	REVISIONS	DATE	BY
1	ISSUED FOR APPENDUM 1	10/02/26	SKC
0	ISSUED FOR CONSTRUCTION	10/02/26	SKC

AECOM

This drawing has been prepared for the use of AECOM client and may not be used, reproduced or relied upon by third parties, except as approved by AECOM and its client. AECOM shall not be liable for any errors or omissions in this drawing, and shall not be responsible for any liability whatsoever, to any party that may arise from the use of this drawing. All measurements must be obtained from field dimensions.

DESIGNED BY LCK
DRAWN BY SKC
HOK SCALE 1:40
VERT. SCALE _____

CHECKED BY LK
APPROVED BY BTW
RELEASED FOR CONSTRUCTION BY KZ
DATE FEB. 9, 2010

PROFESSIONAL'S SEAL
REV. 0
ISSUED FOR CONSTRUCTION
WAS SEALED BY
B. L. MOORE
AND DATED
FEB. 8, 2010

CONSULTANT DRAWING NO. D265-250-00_01-E-0002_RX.dwg

THE CITY OF WINNIPEG
WATER AND WASTE DEPARTMENT

BRANCH I AQUEDUCT VALVE CHAMBER
AT MCPHILLIPS STREET
PUMPING STATION
ELECTRICAL

LOWER & UPPER LEVEL FLOOR PLAN