


ADDRESS: 999 SARGENT AV. PROJECT No: 557-2010 DESCRIPTION: SECOND FLOOR PLAN-DEMOLITION DATE: July 2010 FILE NAME: CINDY KLASSEN RENOVATION.DWG

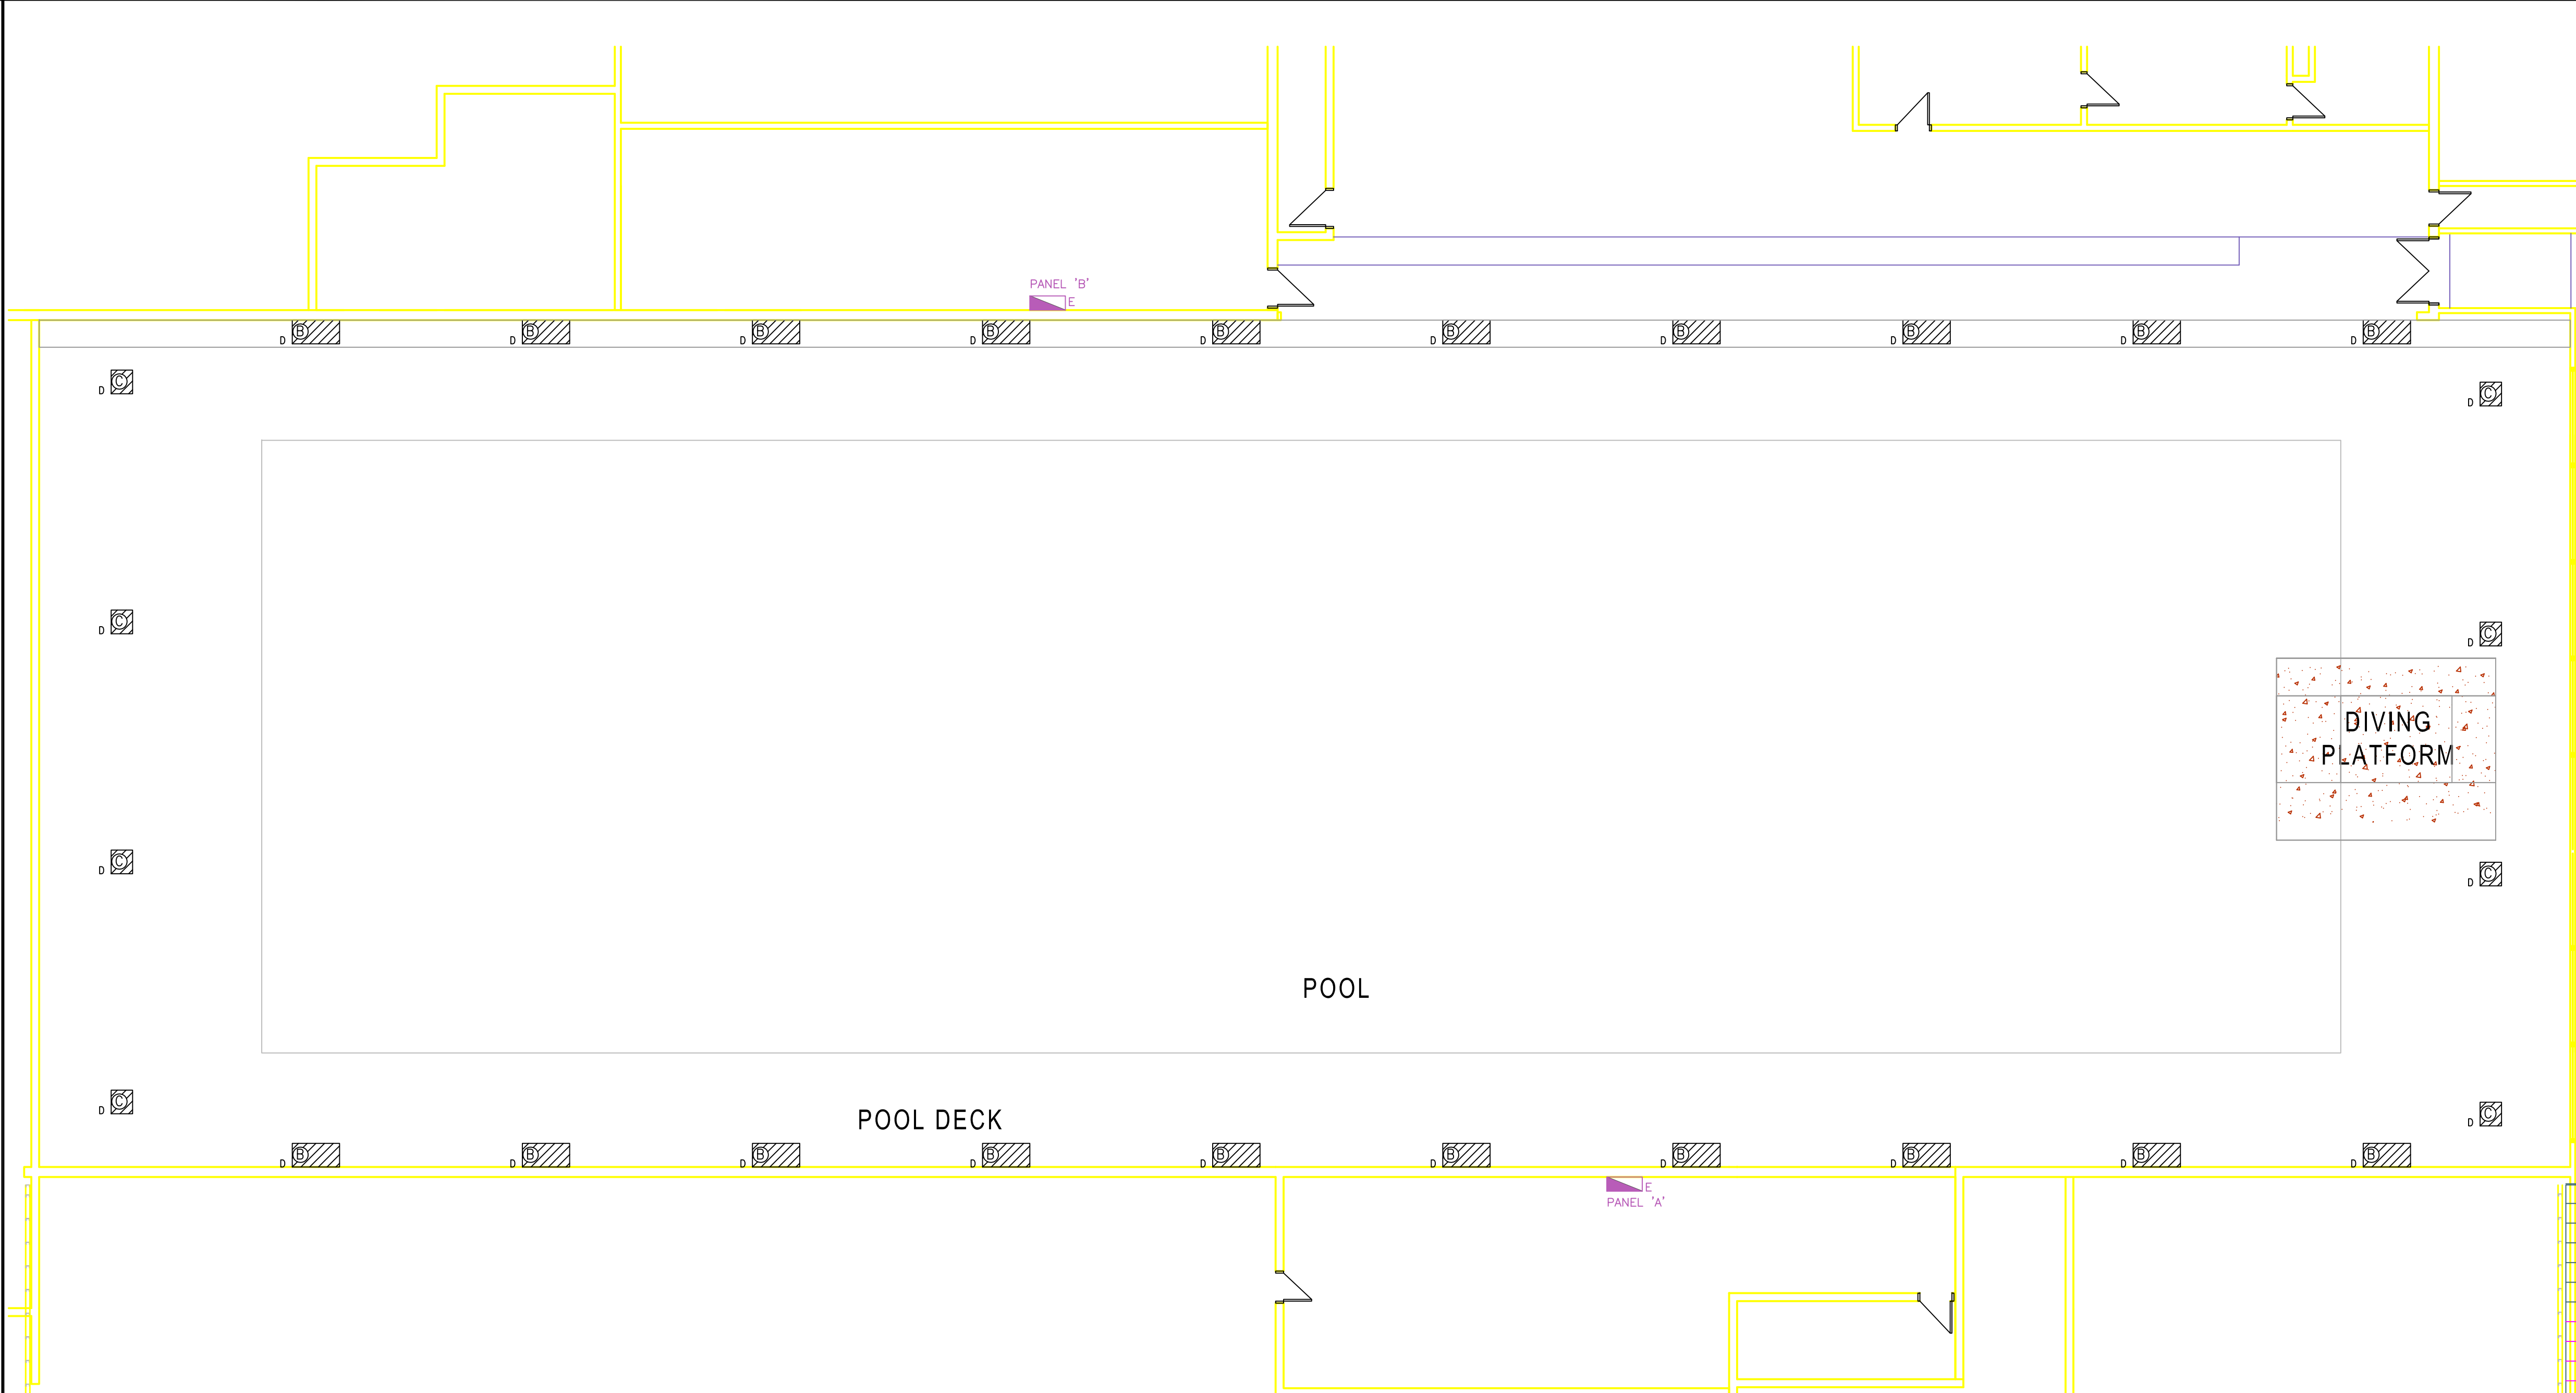

LEGEND

	6x54w IP65 SUSPENDED LUMINAIRE. SEE E-4 FOR SPECIFICATIONS
	2x2 LAMP HPS LUMINAIRE
	ONE LAMP HPS LUMINAIRE
	2x24V IP65 CEILING MOUNTED LUMINAIRE. SEE E-4 FOR SPECIFICATIONS
	MAIN CONTROL UNIT. SEE E-4 FOR SPECIFICATIONS
	INPUT/OUTPUT CONTROL INTERFACE. SEE E-4 FOR SPECIFICATIONS
	FIRE ALARM PANEL
	WALL STATION PUSHBUTTON. SEE E-4 FOR SPECIFICATIONS
	PANELBOARD
	PHOTOCELL. SEE E-4 FOR SPECIFICATIONS
	ADJACENT TO SYMBOL DENOTES 'EXISTING TO BE DEMOLISHED'
	ADJACENT TO SYMBOL DENOTES 'EXISTING TO REMAIN'
	ADJACENT TO SYMBOL DENOTES 'NEW'

DESCRIPTION OF WORK

- THE CONTRACTOR WILL BE RESPONSIBLE FOR COORDINATING THE DELIVERY OF MATERIALS TO SITE, UNLOADING THE MATERIALS AT SITE, AND ARRANGING THE STORAGE AND INSURANCE OF SUCH MATERIALS UPON ARRIVAL.
- REMOVAL OF THE EXISTING AND INSTALLING NEW CONTROLLABLE AND DIMMABLE LIGHTING SYSTEM IN THE POOL AREA.
- WORK TO BE DONE AFTER HOURS, APPROXIMATELY BETWEEN 10:00pm AND 5:00am. THE BUILDING SHALL REMAIN OPEN AND IN NORMAL OPERATION DURING DAY TIME FOR THE CONSTRUCTION PERIOD. PRIOR TO COMMENCEMENT OF WORK CONTRACTOR TO MEET WITH CONTRACT ADMINISTRATOR TO FORMULATE WORK PLAN TO ENSURE POOL REMAINS OPERATIONAL DURING DAY TIME.
 - CONTRACTOR SHALL SPREAD TARPS OVER THE POOL DECK AT THE START OF EACH SHIFT. ALL MATERIALS, EQUIPMENT AND DEBRIS SHALL BE REMOVED FROM THE DECK, AND THE WORK AREA SHALL BE SWEEPED CLEAN PRIOR TO THE END OF EACH SHIFT.
 - CONTRACTOR SHALL TAKE PARTICULAR CARE TO ENSURE THAT NO MATERIALS, EQUIPMENT OR DEBRIS OF ANY KIND FALL INTO THE POOL TANK.
 - WORKERS MUST WEAR CSA PERSONAL FLOTATION DEVICES (PFDs) AT ALL TIMES WHILE ON THE POOL DECK. THE CITY OF WINNIPEG HAS 12 ADULT-SIZE PFDs AT THE SITE THAT THE CONTRACTOR MAY USE; THE PFDs MUST BE LEFT IN A CLEAN AND UNDAMAGED CONDITION AT THE SITE FOR POOL STAFF AT THE END OF EACH SHIFT.
 - PRIOR TO THE END OF EACH WORK SHIFT, CONTRACTOR SHALL MAKE SURE THAT THE NIGHT TIME LIGHTING LEVELS ARE NOT LESS THAN 200lx ON THE POOL DECK.
- LUMINAIRE OPERATION:
 - DAYTIME – LUMINAIRES CONTROLLED VIA PHOTOCELL TO MAINTAIN NOT LESS THAN 200lx ON POOL DECK.
 - NIGHTTIME
 - UNOCCUPIED – LUMINAIRES DIMMED TO MAINTAIN PRESET MINIMUM LIGHTING LEVEL OF 10lx
 - OCCUPIED – PUSH BUTTON MAINTENANCE OVERRIDE INCREASES LIGHT LEVELS TO 200lx FOR PRESET TIME PERIOD.

GENERAL NOTES

THE CONTRACTOR SHALL VISIT THE SITE AND SATISFY ONESELF ALL DIMENSIONS, DATUM, AND DETAILED INFORMATION SHOWN ARE CORRECT.

THE CONTRACTOR IS TO REVIEW EXISTING DRAWINGS PRIOR TO MAKING ADDITIONAL OPENINGS THROUGH FLOORS, WALLS, AND CEILINGS FOR DUCT, PIPE & ELECTRICAL RISERS AND ALL OPENINGS NOT SHOWN ON DRAWINGS.

ALL OPENINGS THROUGH FIRE ASSEMBLIES ARE TO BE FIRE STOPPED AND SEALED WITH ULC APPROVED FIRE STOPPING TO MAINTAIN THE INTEGRITY OF THE FIRE SEPARATION, AND PROVIDE A SMOKE-TIGHT BARRIER.

DEMOLITION NOTES

- REMOVE ALL EXISTING ELECTRICAL EQUIPMENT, WIRING, FIXTURES AND NON ELECTRICAL SYSTEMS, BACK TO SOURCE, IN THOSE PORTIONS OF THE EXISTING BUILDING WHICH ARE BEING MADE REDUNDANT BY THIS WORK BEING CARRIED OUT.
- CONTRACTOR TO CHECK WITH CONTRACT ADMINISTRATOR PRIOR TO DISPOSAL OF REMOVED EQUIPMENT.

PATCH, PAINT AND REPAIR WALLS, FLOORS AND CEILINGS TO MATCH EXISTING IN EXISTING AREAS FROM WHICH REMOVAL OF EQUIPMENT OR SUPPORTING STRUCTURE HAS TAKEN PLACE.

1 ELECTRICAL DEMOLITION - SECOND FLOOR
E-1 SCALE: 1:100

NO.	REVISION/DESCRIPTION	BY	DATE
R-01	CHANGES IN LEGEND	vc	7/27/2010

DRAWN BY: VC CHECKED BY: VC APPROVED: [Signature] DATE: July 2010 USER APPROVAL

CITY OF WINNIPEG
PLANNING, PROPERTY AND DEVELOPMENT DEPARTMENT
Municipal Accommodations Division
185 King St Winnipeg, MB R3B 1J1

PROJECT
CINDY KLASSEN POOL
REPLACE LIGHTING ON POOL DECK

999 SARGENT AV.
SHEET TITLE
SECOND FLOOR PLAN
DEMOLITION

SCALE AS SHOWN	PROJECT NO. 557-2010	SHEET NO. E-1
-------------------	-------------------------	------------------