



1 LOWER FLOOR PLAN
SCALE 1:100

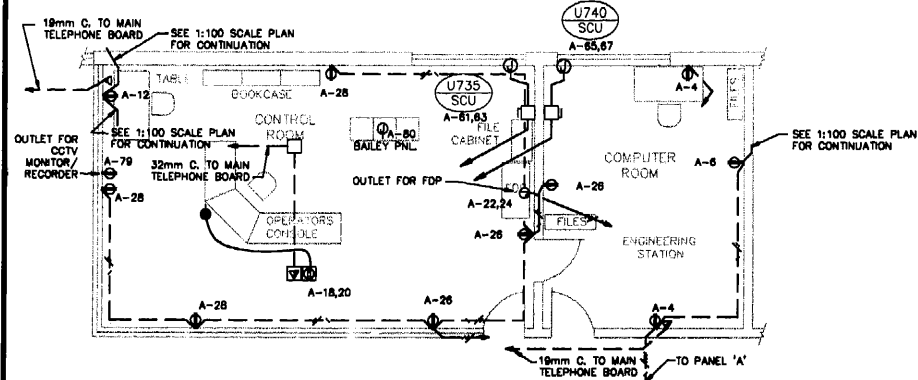

3 CONTROL & COMPUTER RM. LAYOUTS
SCALE 1:75

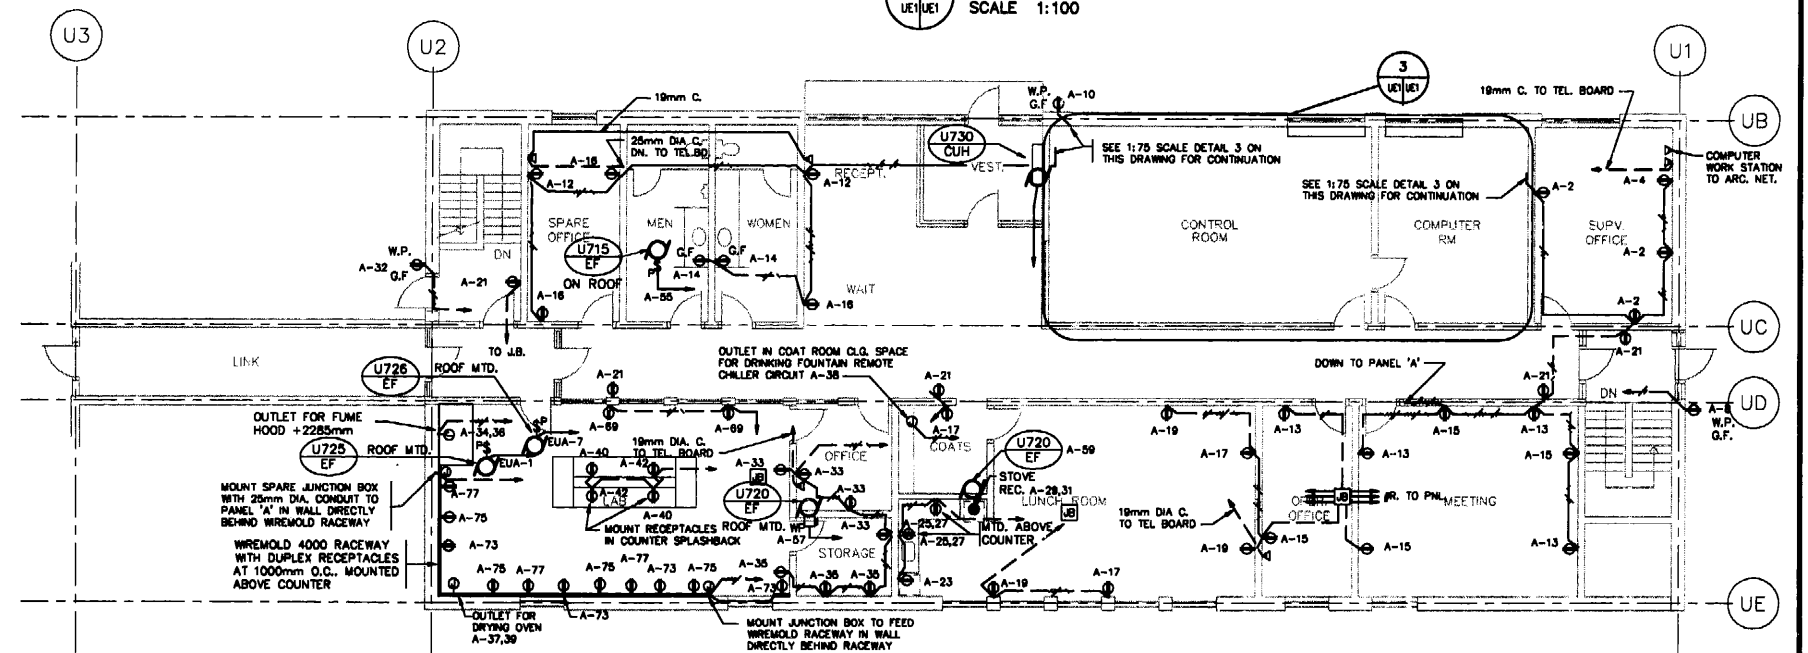

2 UPPER FLOOR PLAN
SCALE 1:100

THE ENGINEER THAT SEALED THIS DRAWING IS RESPONSIBLE FOR ONLY THE AS-CONSTRUCTED CHANGES ON THIS DRAWING.
THE ORIGINAL DESIGN WAS THE RESPONSIBILITY OF THE DESIGN ENGINEER WHO SEALED THE ISSUED FOR TENDER DRAWINGS IN 1991.

REID, CROWTHER & PARTNERS LIMITED
WINNIPEG
AS CONSTRUCTED
SIG: *[Signature]* DATE: *10/27/91*

detail symbol
A detail number
B drawing where detail shown
C cross reference to drawing where detail taken



B.M. 69-006 ELEV. 237.636 m	DESIGNED BY LT	CHECKED BY DJS
	DRAWN BY EJS	APPROVED BY
1 AS BUILT 93/11 DE	HOR. SCALE: 1:100	RELEASED FOR CONSTRUCTION:
0 ISSUED FOR TENDER	VERTICAL:	DATE
NO. REVISIONS	DATE BY DATE	DATE

Reid Crowther



THE CITY OF WINNIPEG
WORKS AND OPERATIONS DIVISION
WATERWORKS WASTE AND DISPOSAL DEPT.

WEST END WATER POLLUTION CONTROL CENTRE
AREA U - ADMINISTRATION BUILDING

UPPER AND LOWER FLOOR PLANS
ELECTRICAL POWER LAYOUT

CITY DRAWING NUMBER
SHEET OF
WEP-293

20. #14810248