

PRIMARY CLARIFIER
NO. 3

BIOREACTOR NO. 1

BIOREACTOR NO. 2

BIOREACTOR NO. 3

BLOWER
BUILDING

OXYGEN REACTORS
NO. 3 AND NO. 4

SEE DWG
SFDW-R002


SEE DWG
SFDW-R003

SEE DWG
SFDW-R004

OVERALL PILING PLAN
1:200


NOTES:

- REFER TO DWG 1-0102-SGAD-A001 FOR GENERAL NOTES.
- REFER TO DWG 1-0102-SGAD-A002 FOR OVERALL SITE PLAN AND SEQUENCING.
- PILE DIAMETER (D) = 400mm
- ESTIMATED PILE REFUSAL EL 210.000

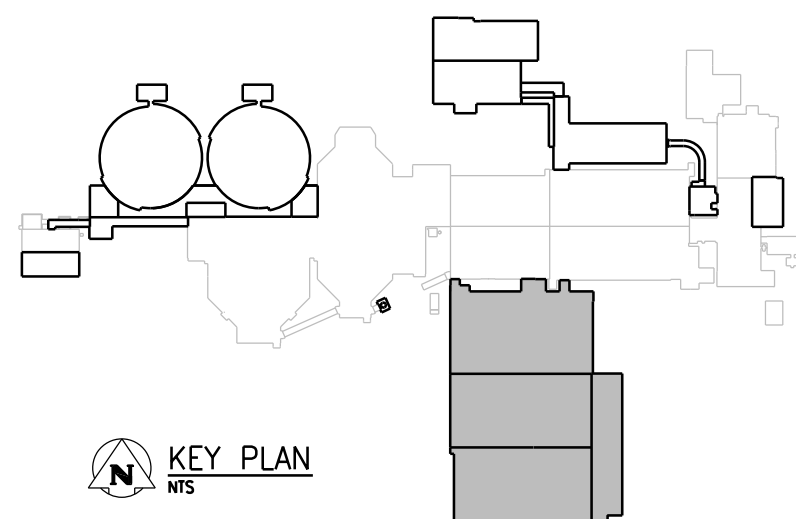

NO.	REVISIONS	DATE	DESIGN CHECK
01	ISSUED FOR ADDENDUM NO. 1	07/2014	G.O. B.W.
00	ISSUED FOR TENDER	06/2014	G.O. B.W.

DESIGNED BY: E. LUI	CHECKED BY: B. WILLIAMSON
DRAWN BY: G. OMORI	APPROVED BY: E. LUI
SCALE: 1:200	ISSUED FOR CONSTRUCTION BY: DATE:
DATE: 2014/06/27	
CONSULTANT NO.: 474248	

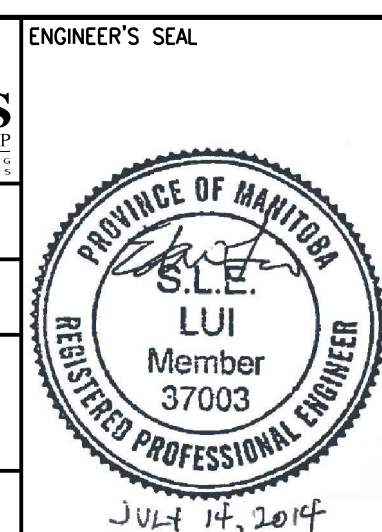

THE CITY OF WINNIPEG
WATER AND WASTE DEPARTMENT
SOUTH END WATER POLLUTION CONTROL CENTRE
SEWPC UPGRADING/EXPANSION PROJECT
STRUCTURAL
BIOREACTORS/BLOWER BUILDING
OVERALL PILING PLAN
CITY DRAWING NUMBER: 1-0102-SFDW-R001 | SHEET: 001 | REV: 01 | SIZE: A1