

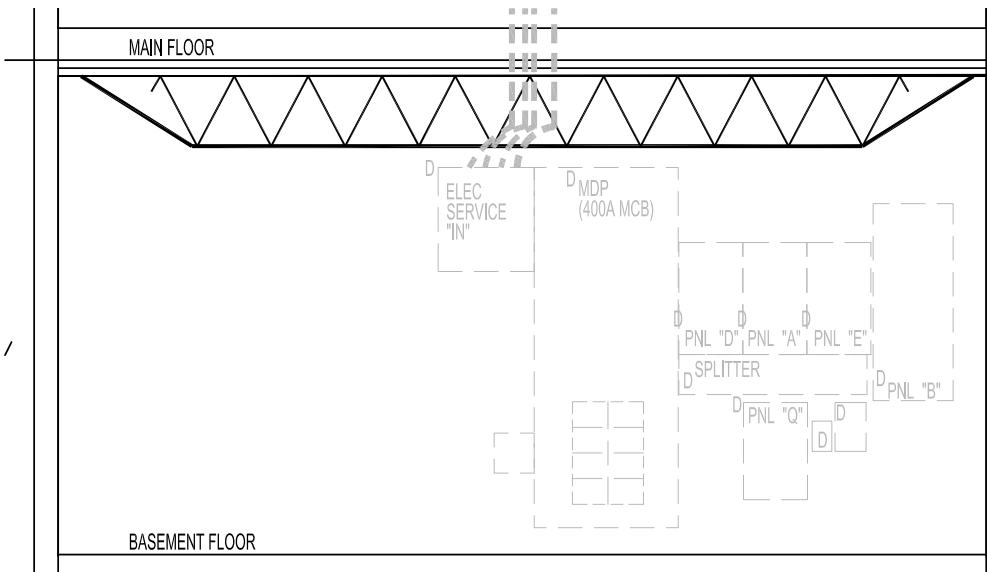


GENERAL NOTES:  
1. REFER TO DRAWING E1.0 & SPECIFICATIONS.

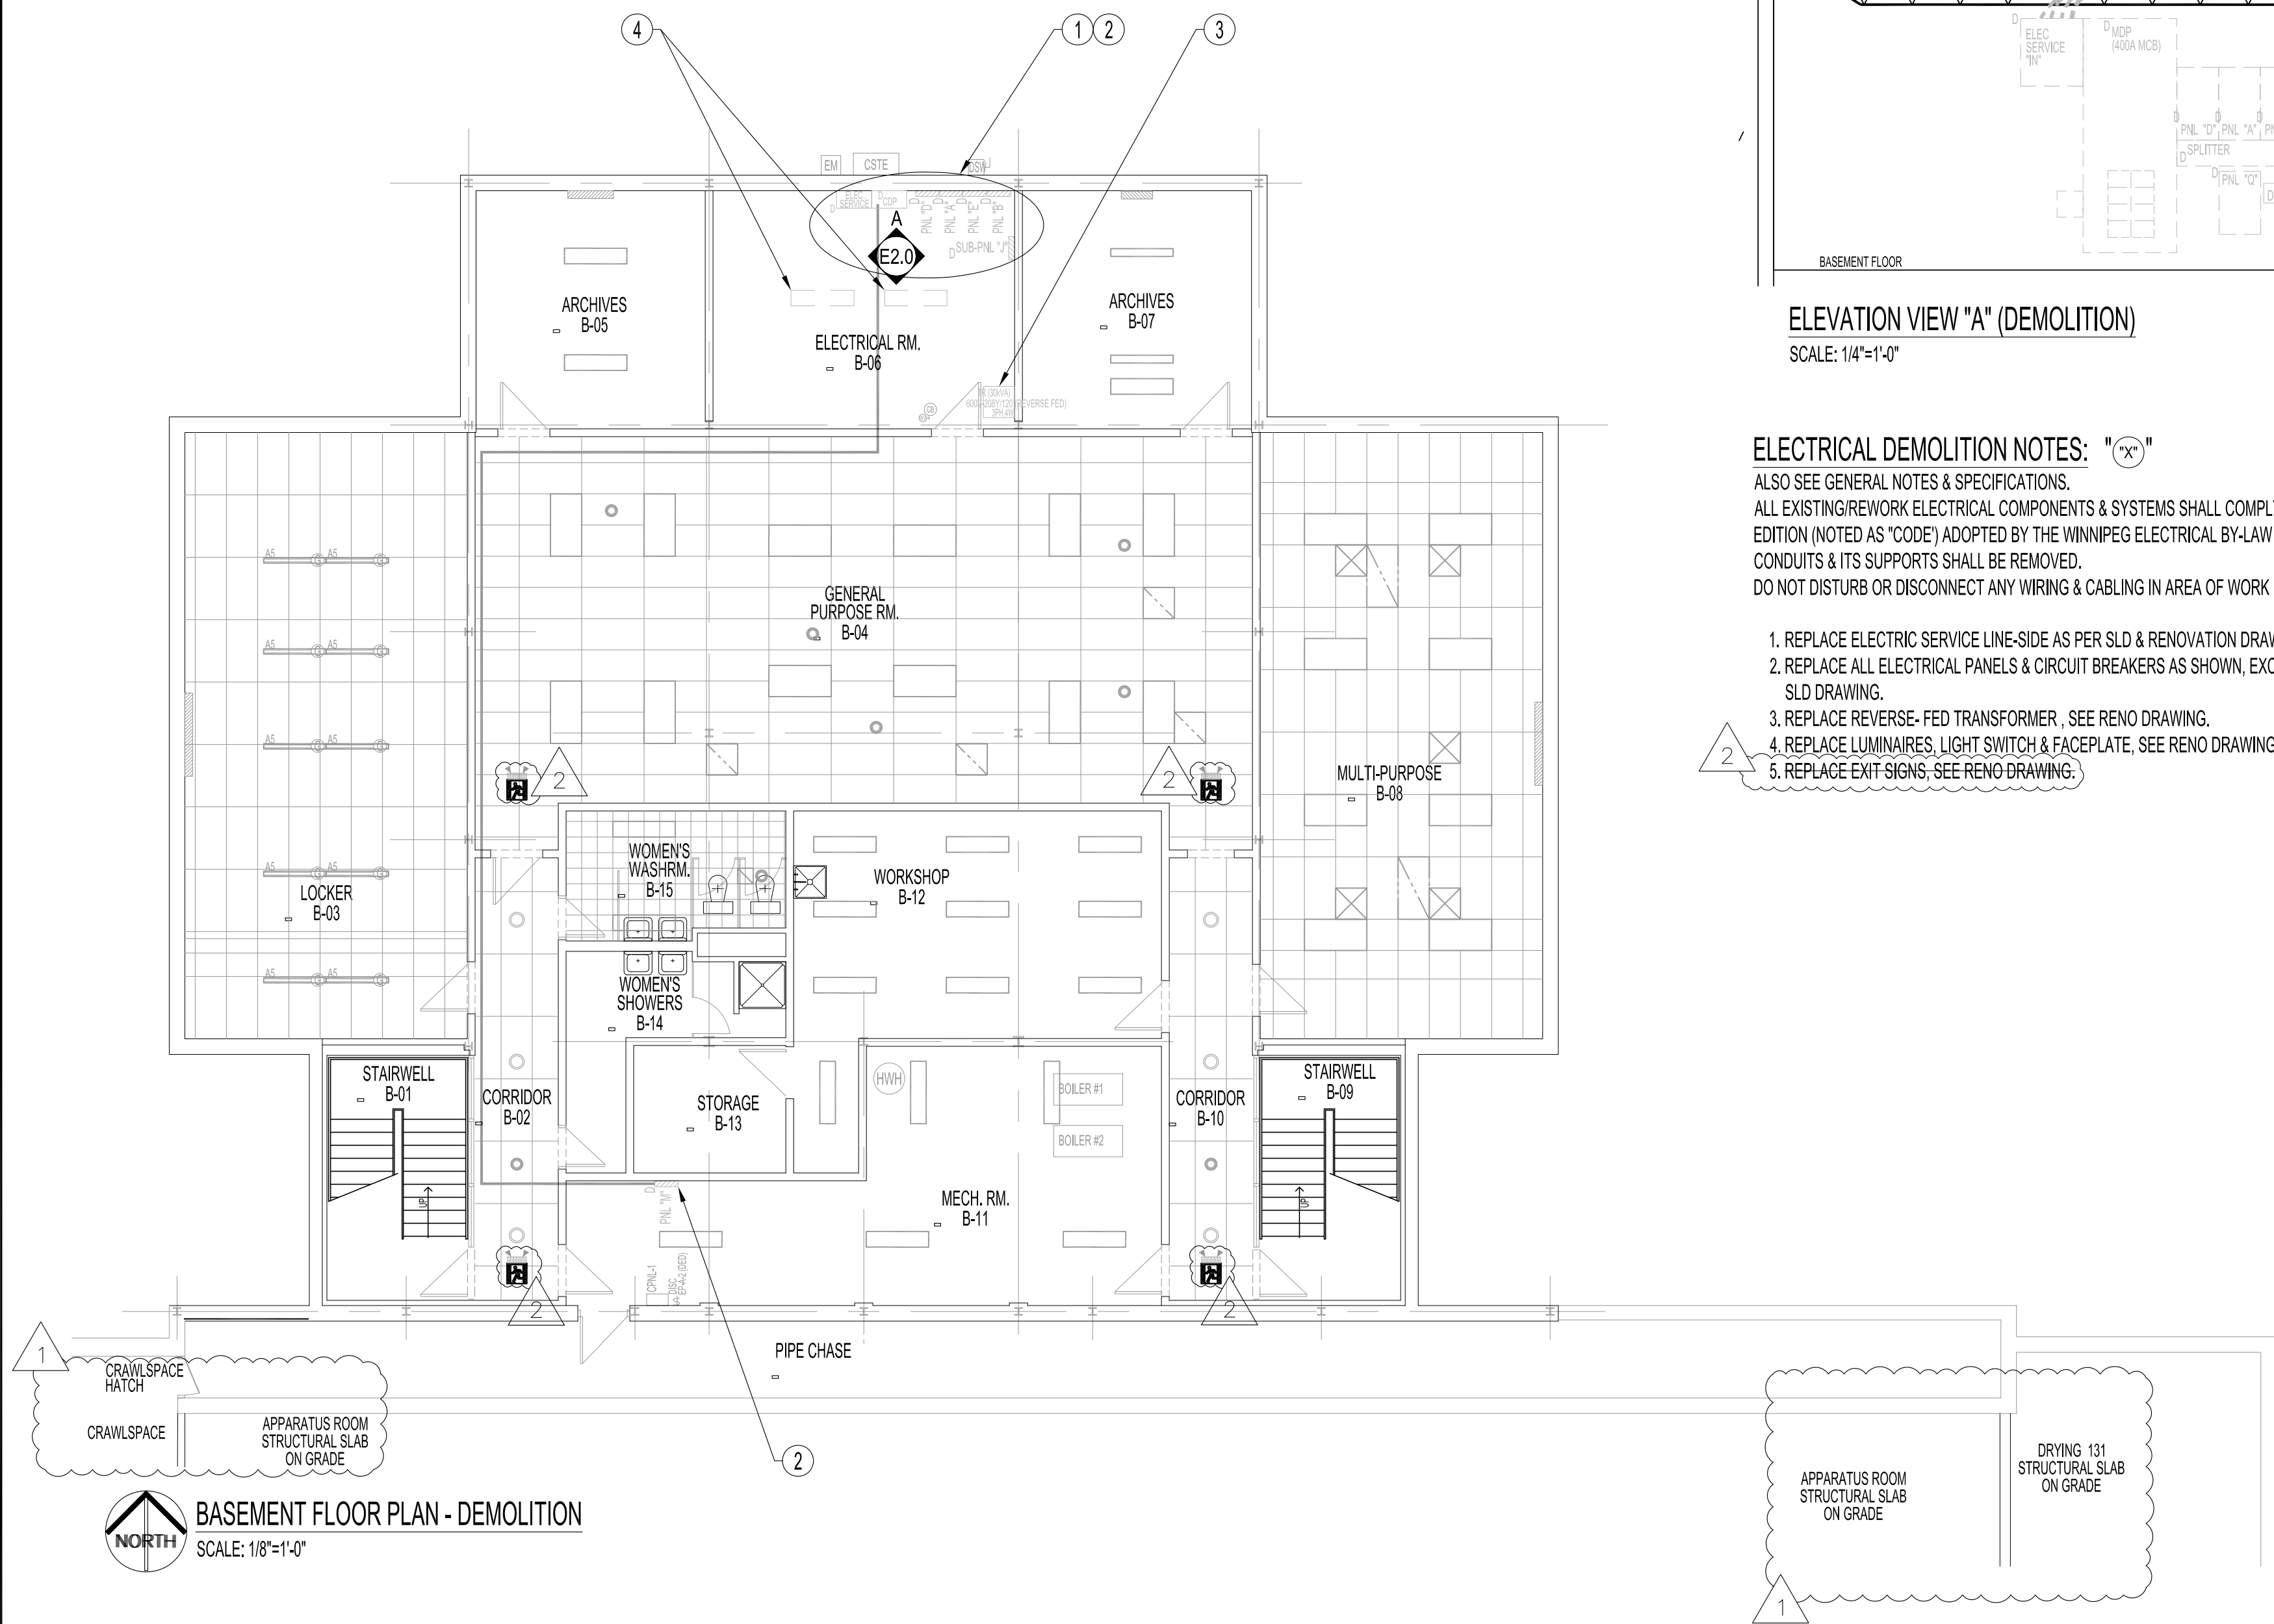

ELEVATION VIEW "A" (DEMOLITION)  
SCALE: 1/4"=1'-0"

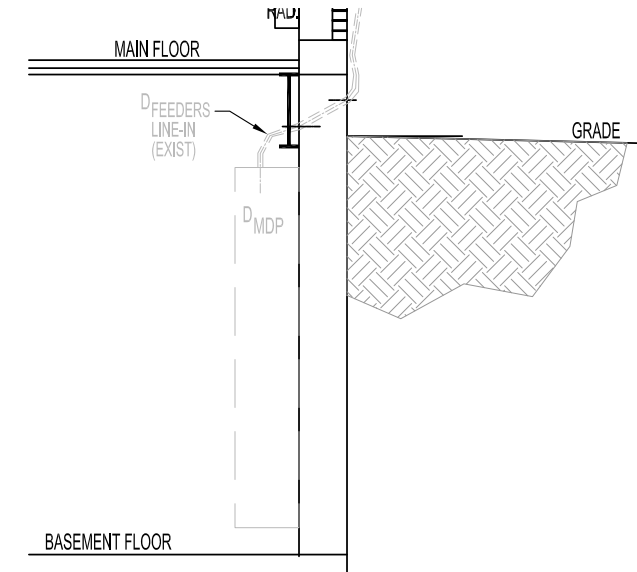

ELEVATION VIEW "A", X-SECTION (DEMOLITION)  
SCALE: 1/4"=1'-0"

- ELECTRICAL DEMOLITION NOTES:** "X"
- ALSO SEE GENERAL NOTES & SPECIFICATIONS.  
ALL EXISTING/REWORK ELECTRICAL COMPONENTS & SYSTEMS SHALL COMPLY TO THE 2021 CANADIAN ELECTRICAL CODE, PART I, 25TH EDITION (NOTED AS 'CODE') ADOPTED BY THE WINNIPEG ELECTRICAL BY-LAW NO. 72/2022. THIS INCLUDES ABANDONED WIRES, CABLES, CONDUITS & ITS SUPPORTS SHALL BE REMOVED.  
DO NOT DISTURB OR DISCONNECT ANY WIRING & CABLING IN AREA OF WORK REQUIRED FOR OTHER AREAS.
1. REPLACE ELECTRIC SERVICE LINE-SIDE AS PER SLD & RENOVATION DRAWINGS.
  2. REPLACE ALL ELECTRICAL PANELS & CIRCUIT BREAKERS AS SHOWN, EXCEPT PANEL "SUB-J" SHALL BE REMOVED & RE-CIRC AS PER SLD DRAWING.
  3. REPLACE REVERSE-FED TRANSFORMER, SEE RENO DRAWING.
  4. REPLACE LUMINAIRES, LIGHT SWITCH & FACEPLATE, SEE RENO DRAWING.
  5. REPLACE EXIT SIGNS, SEE RENO DRAWING.

**BASEMENT FLOOR PLAN - DEMOLITION**  
SCALE: 1/8"=1'-0"

No.	REVISION/DESCRIPTION	BY	DATE
2	ISSUED FOR ADDENDUM 3	DTA	2023 01.08
1	ISSUED FOR ADDENDUM 1	DTA	2022 12.15
0	ISSUED FOR CONSTRUCTION	DTA	2022 11.03

SEAL

DATE	USER	APPROVAL
2022.10.24		

THE CITY OF WINNIPEG  
PLANNING, PROPERTY AND  
DEVELOPMENT DEPARTMENT  
MUNICIPAL ACCOMMODATIONS DIVISION  
3-65 GARRY STREET, R3C 4K4

PROJECT  
WINNIPEG FIRE PARAMEDIC SERVICES  
FIRE STATION #1  
ELECTRICAL SERVICE UPGRADE AND EMERGENCY GENERATOR  
65 ELLEN STREET BID OPP: 805-2022

SHEET TITLE  
BASEMENT FLOOR PLAN  
ELECTRICAL - DEMOLITION  
POWER AND SYSTEMS

SCALE	PROJECT No:	SHEET No:
AS SHOWN	2019-150-01	E2.0-R2