
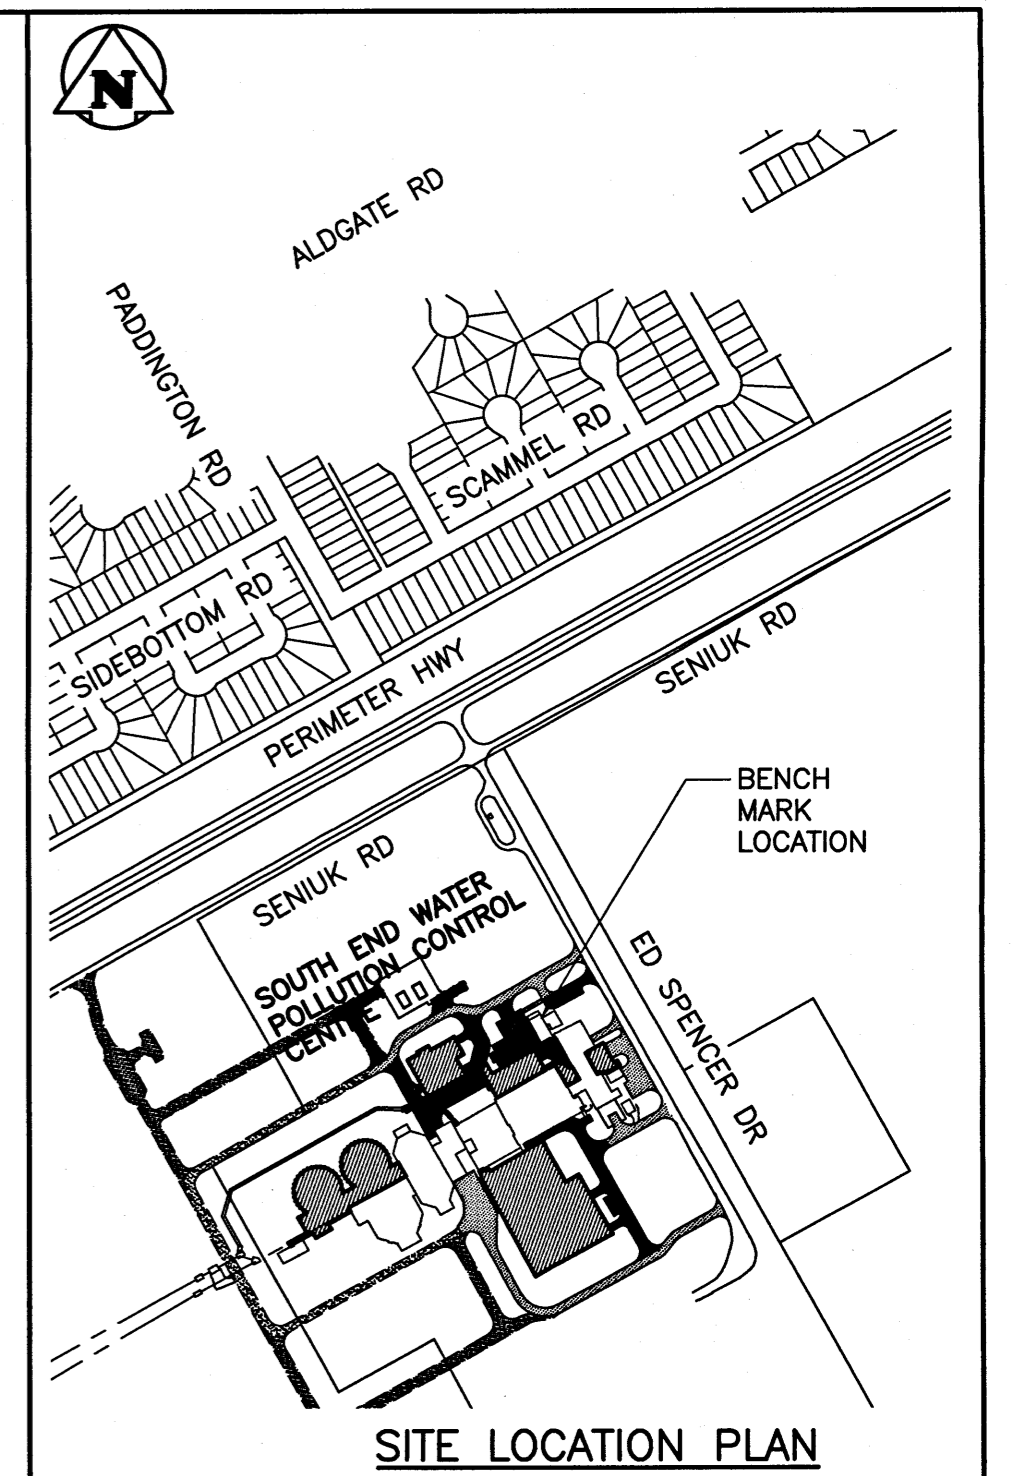


A1 SIZE - 594mm x 841mm

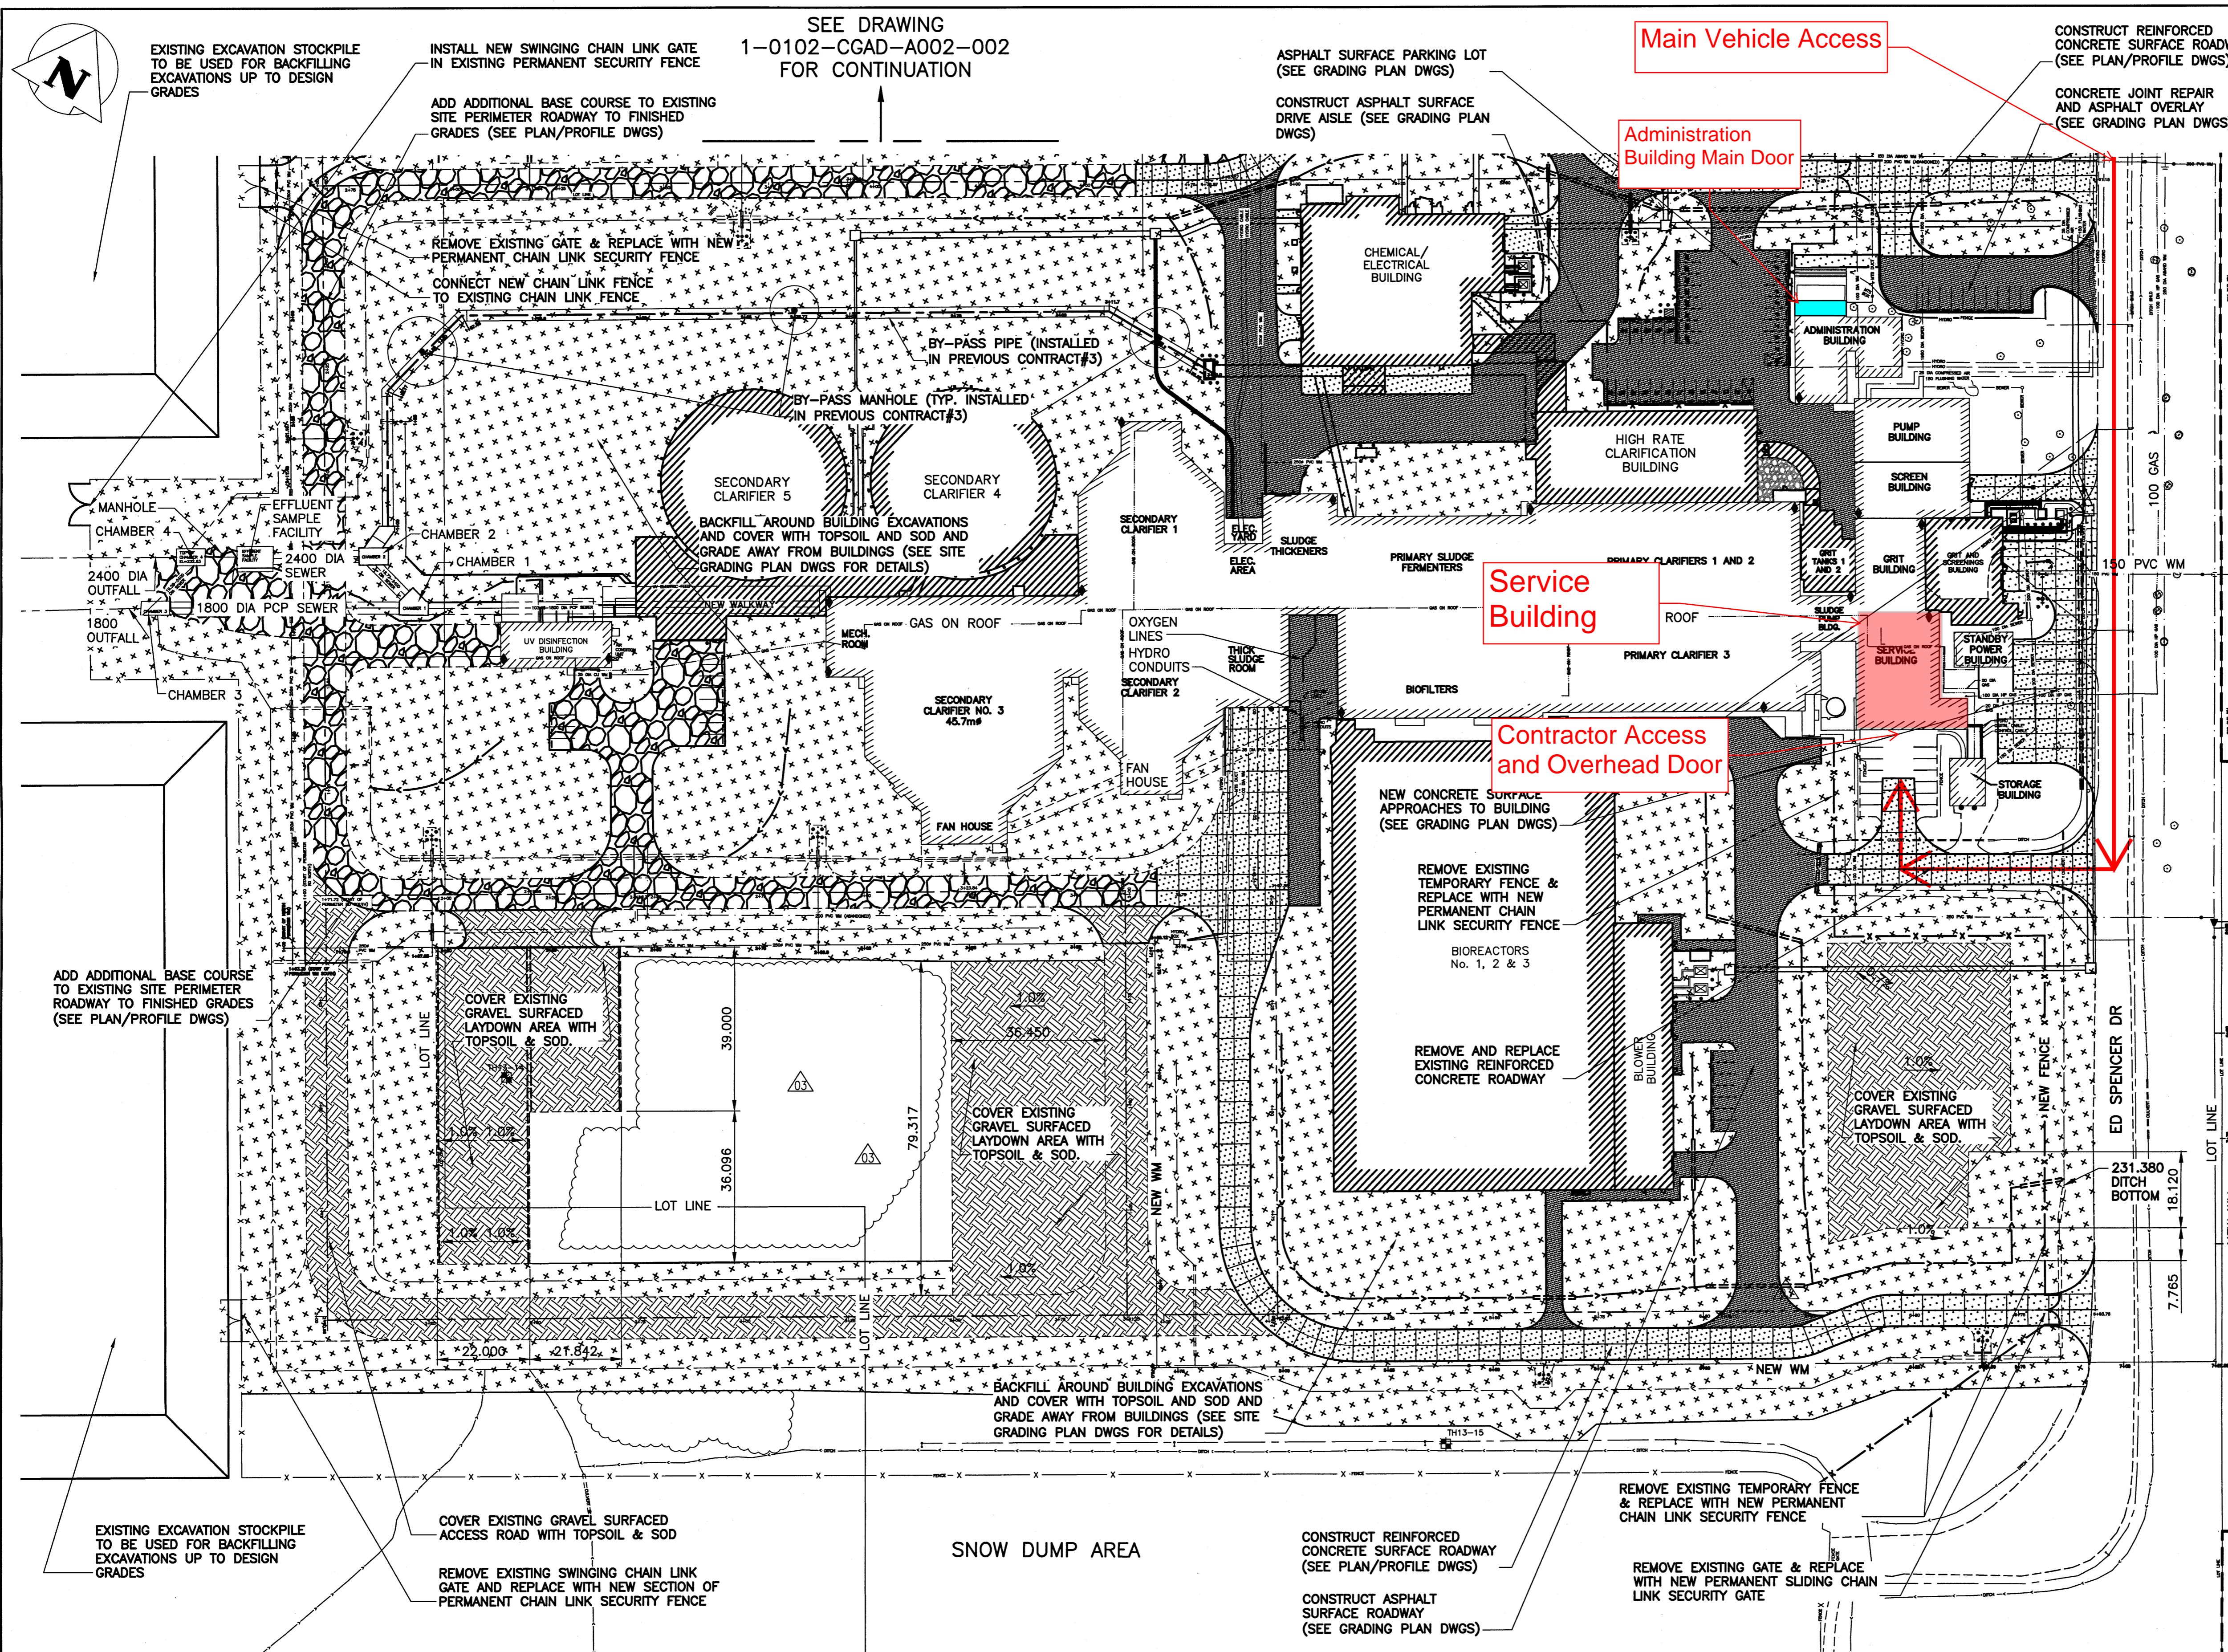

LEGEND

	EXISTING	NEW
SEWER	—	—
SEWER MH	○	●
SEWER PLUG	—	—
SEWER CB	□	□
SEWER STRUCT	—	—
WM	—	—
WM VALVE	⊗	⊗
WM HYDRANT	⊕	⊕
GAS	—	—
HYDRO	—	—
HYDRO POLE	●HP	●HP
HYDRO STR	□	□
HYDRO POLE	●H	●H
STREET LIGHT	⊙	⊙
HYDRO TRANSFORMER	⊗	⊗
BOLLARD	⊙	⊙
TREE	⊙	⊙
SHRUBS/BUSH	⊙	⊙
CULVERT	—	—
DITCH	—	—
ROAD	—	—
FENCE	—	—
BUILDINGS	—	—
TOPSOIL AND SOD OVER EXISTING GRAVEL SURFACED AREA	—	—
TOPSOIL AND SOD OVER DITCHES AND LANDSCAPE AREAS	—	—
ASPHALT PAVEMENT	—	—
CONCRETE PAVEMENT	—	—
GRAVEL ROADWAY	—	—

NOTES:

- ALL WORK SHALL BE PERFORMED IN ACCORDANCE WITH THE CITY OF WINNIPEG STANDARD CONSTRUCTION SPECIFICATIONS.
- DRAWING PREVIOUSLY ISSUED (REV 00 THROUGH REV 03) FOR TENDER AND CONSTRUCTION IN SEWCC CONTRACT 1 - BID OPP 333-2014 FOR CONSTRUCTION OF PRELIMINARY SITE WORKS.
- LATEST REVISION OF DRAWING BEING ISSUED FOR FINAL SITE GRADING FOR SEWCC CONTRACT 4.

ITEMS SHOWN AS EXISTING ARE BASED ON AVAILABLE DOCUMENTATION AND MAY NOT ACTUALLY BE REPRESENTATIVE OF THE EXISTING INFRASTRUCTURE. THE DESIGN ENGINEER IS ONLY RESPONSIBLE FOR INFRASTRUCTURE THAT IS SHOWN AS A NEW INSTALLATION. THE CONTRACTOR IS RESPONSIBLE FOR CONFIRMING THE STATE OF THE EXISTING INFRASTRUCTURE THAT MAY HAVE AN IMPACT ON THE INSTALLATION OF NEW EQUIPMENT.

SCALE: 1:800 (A1)

SEE DRAWING 1-0102-CGAD-A002-002 FOR CONTINUATION

SNOW DUMP AREA

APEGM
Certificate of Authorization
KGS Group
No. 245

NO.	REVISIONS	DATE	DESIGN CHECK
04	ISSUED FOR CONSTRUCTION - 976-2016	2017/04/05	EMS
03	ISSUED FOR FI 4	10/2014	EMS
02	ISSUED FOR CONSTRUCTION	08/2014	EMS
01	ISSUED FOR ADDENDUM NO.1	07/2014	BJM
00	ISSUED FOR TENDER	06/2014	BJM

CH2MHILL
DESIGNED BY: EMS
CHECKED BY: BJM
DRAWN BY: DMW
APPROVED BY: RJH
SCALE: AS NOTED
DATE: 2014/06/27
DATE: 2017/04/05
CONSULTANT NO.: 13-0338-002

ENGINEER'S SEAL
B. J. MIKOLAYENKO
Member 24688
Professional Engineer
March 23/2017

THE CITY OF WINNIPEG
WATER AND WASTE DEPARTMENT
SOUTH END WATER POLLUTION CONTROL CENTRE
SEWCC UPGRADE/EXPANSION PROJECT
CIVIL
SITE PLAN SOUTH

CITY DRAWING NUMBER: 1-0102-CGAD-A002
SHEET: 002
REV: 04
SIZE: A1

LAST SAVE: 2017/03/29 - 11:32am
PATH: P:\Projects\2013\13-0338-002\Drawings\Contract 4\1-0102-CGAD-A002-002.dwg