



AS-CONSTRUCTED

Robert K. Cuthbert 01.09.27

CONTRACT DRAFTING & GRAPHIC DATE
ADMINISTRATION SERVICES WATER AND WASTE DEPARTMENT

METRIC

WHOLE NUMBERS INDICATE MILLIMETRES
DECIMALIZED NUMBERS INDICATE METRES

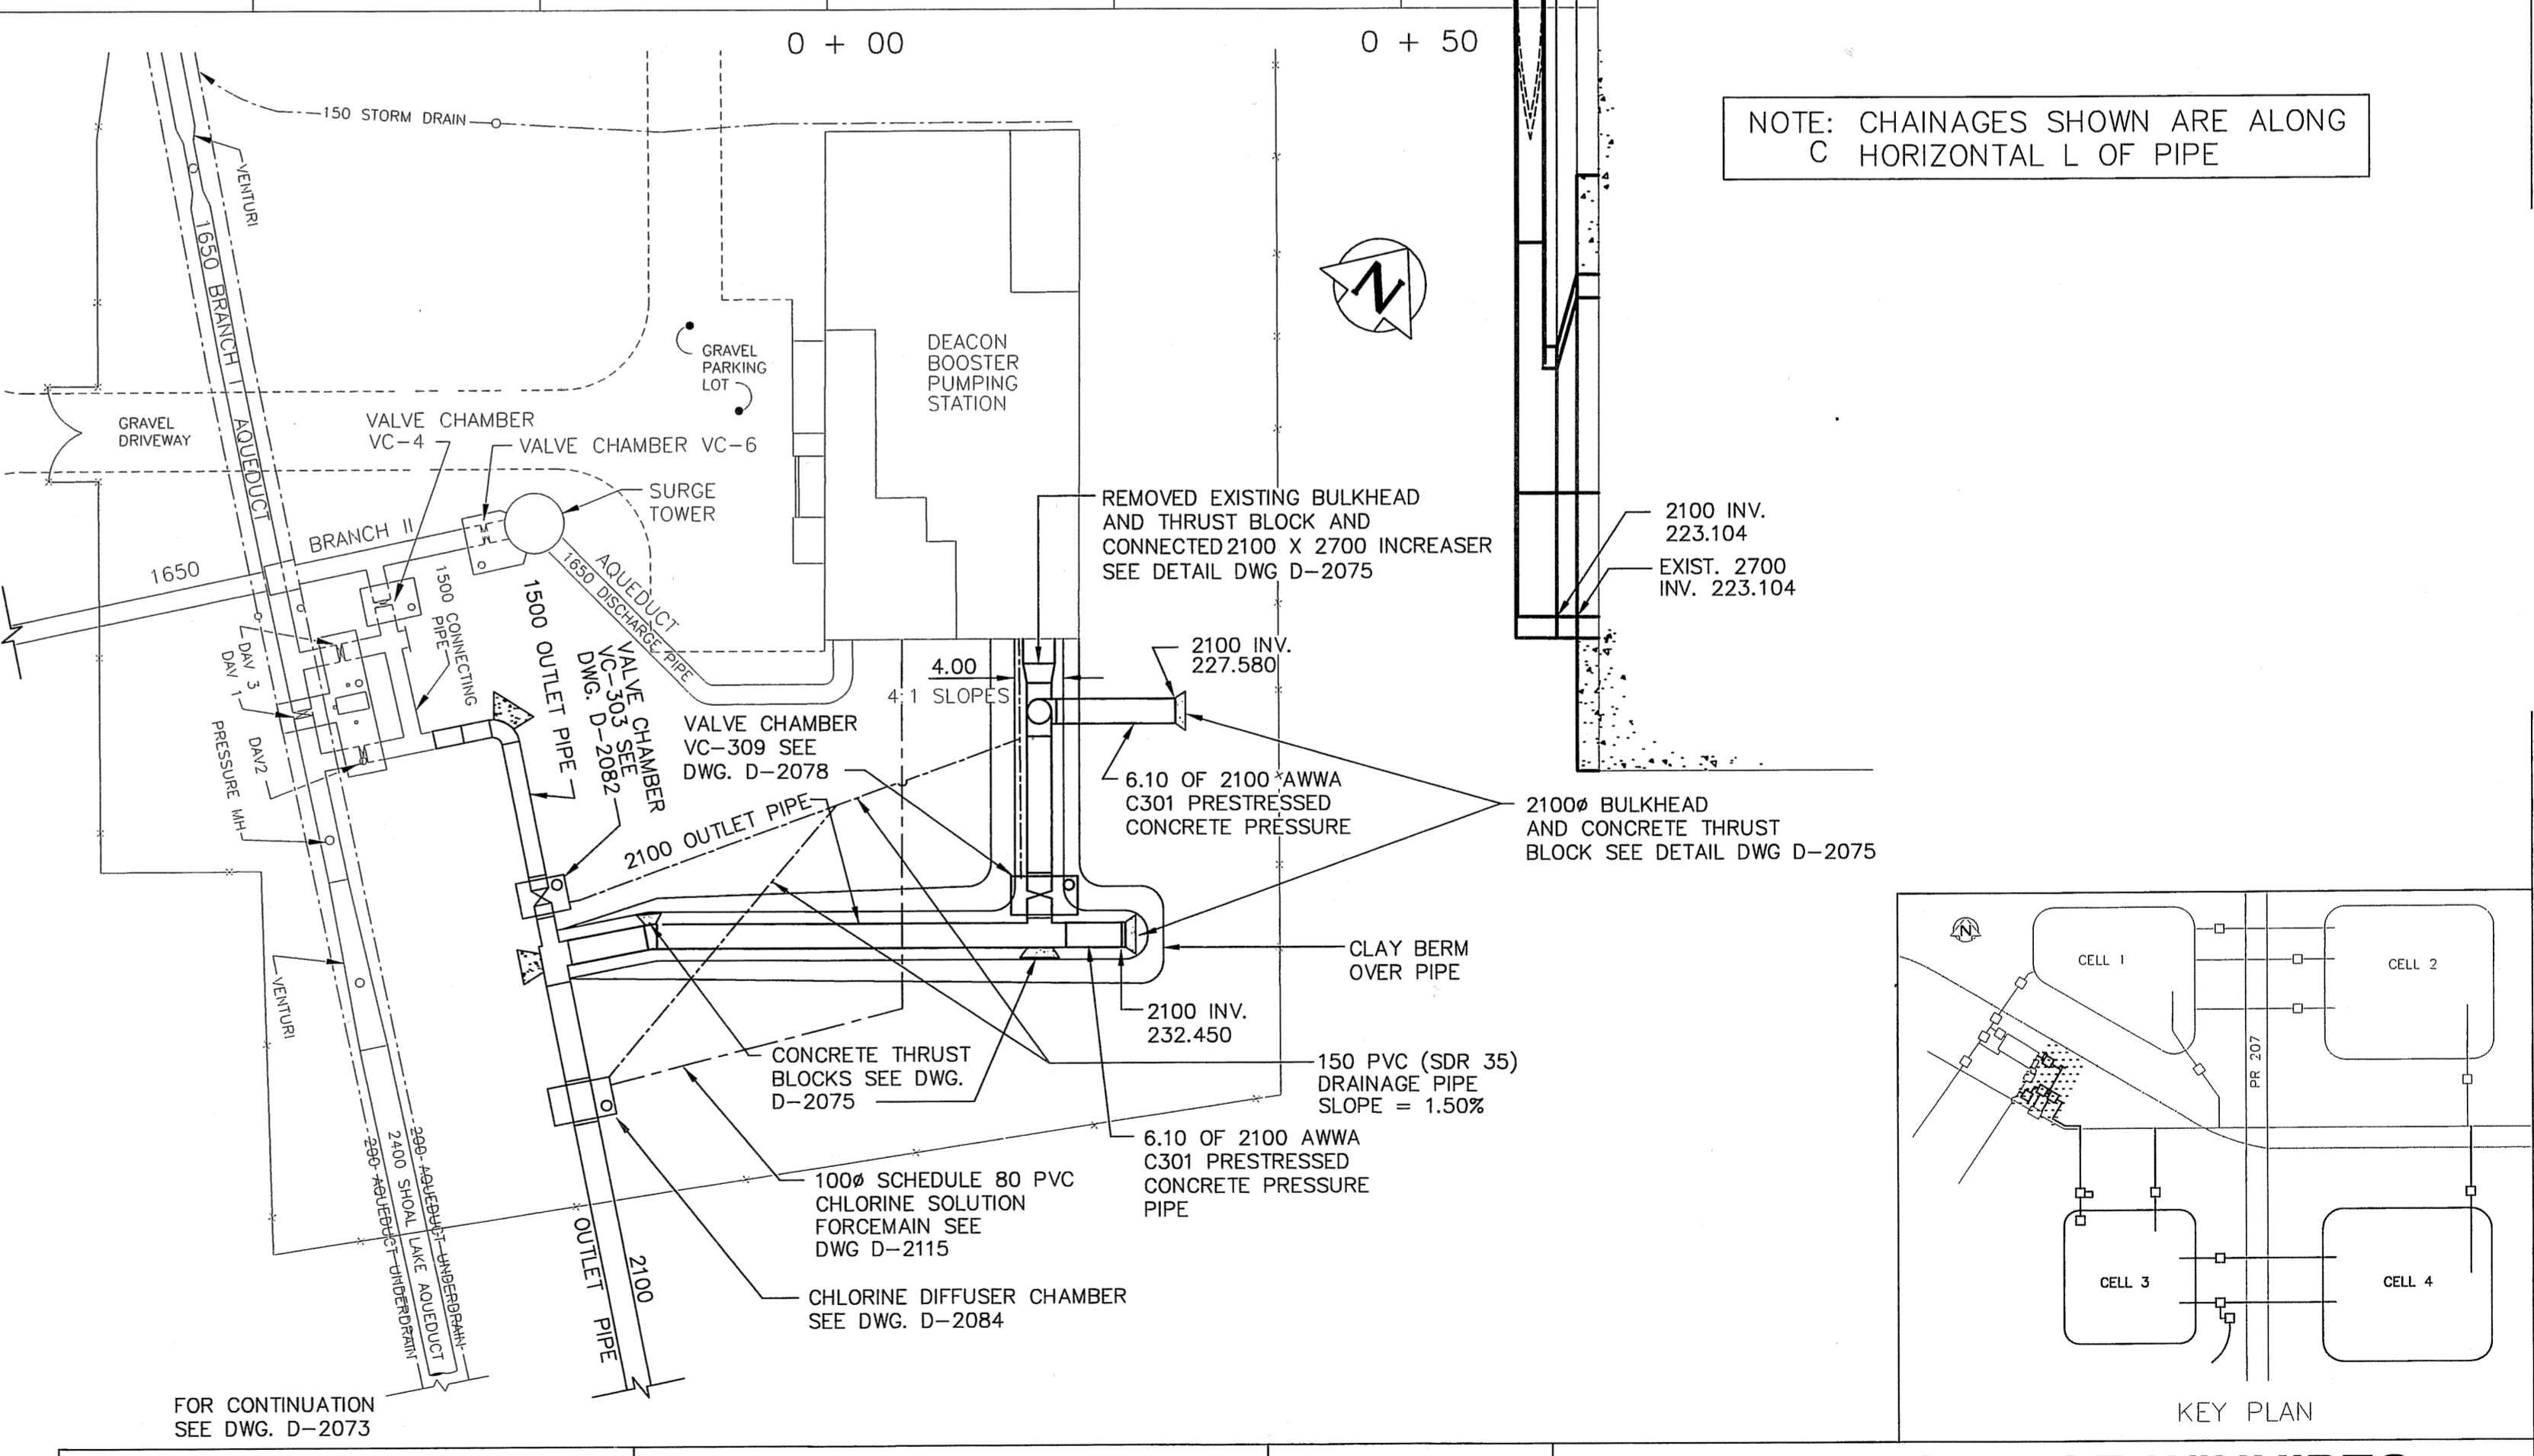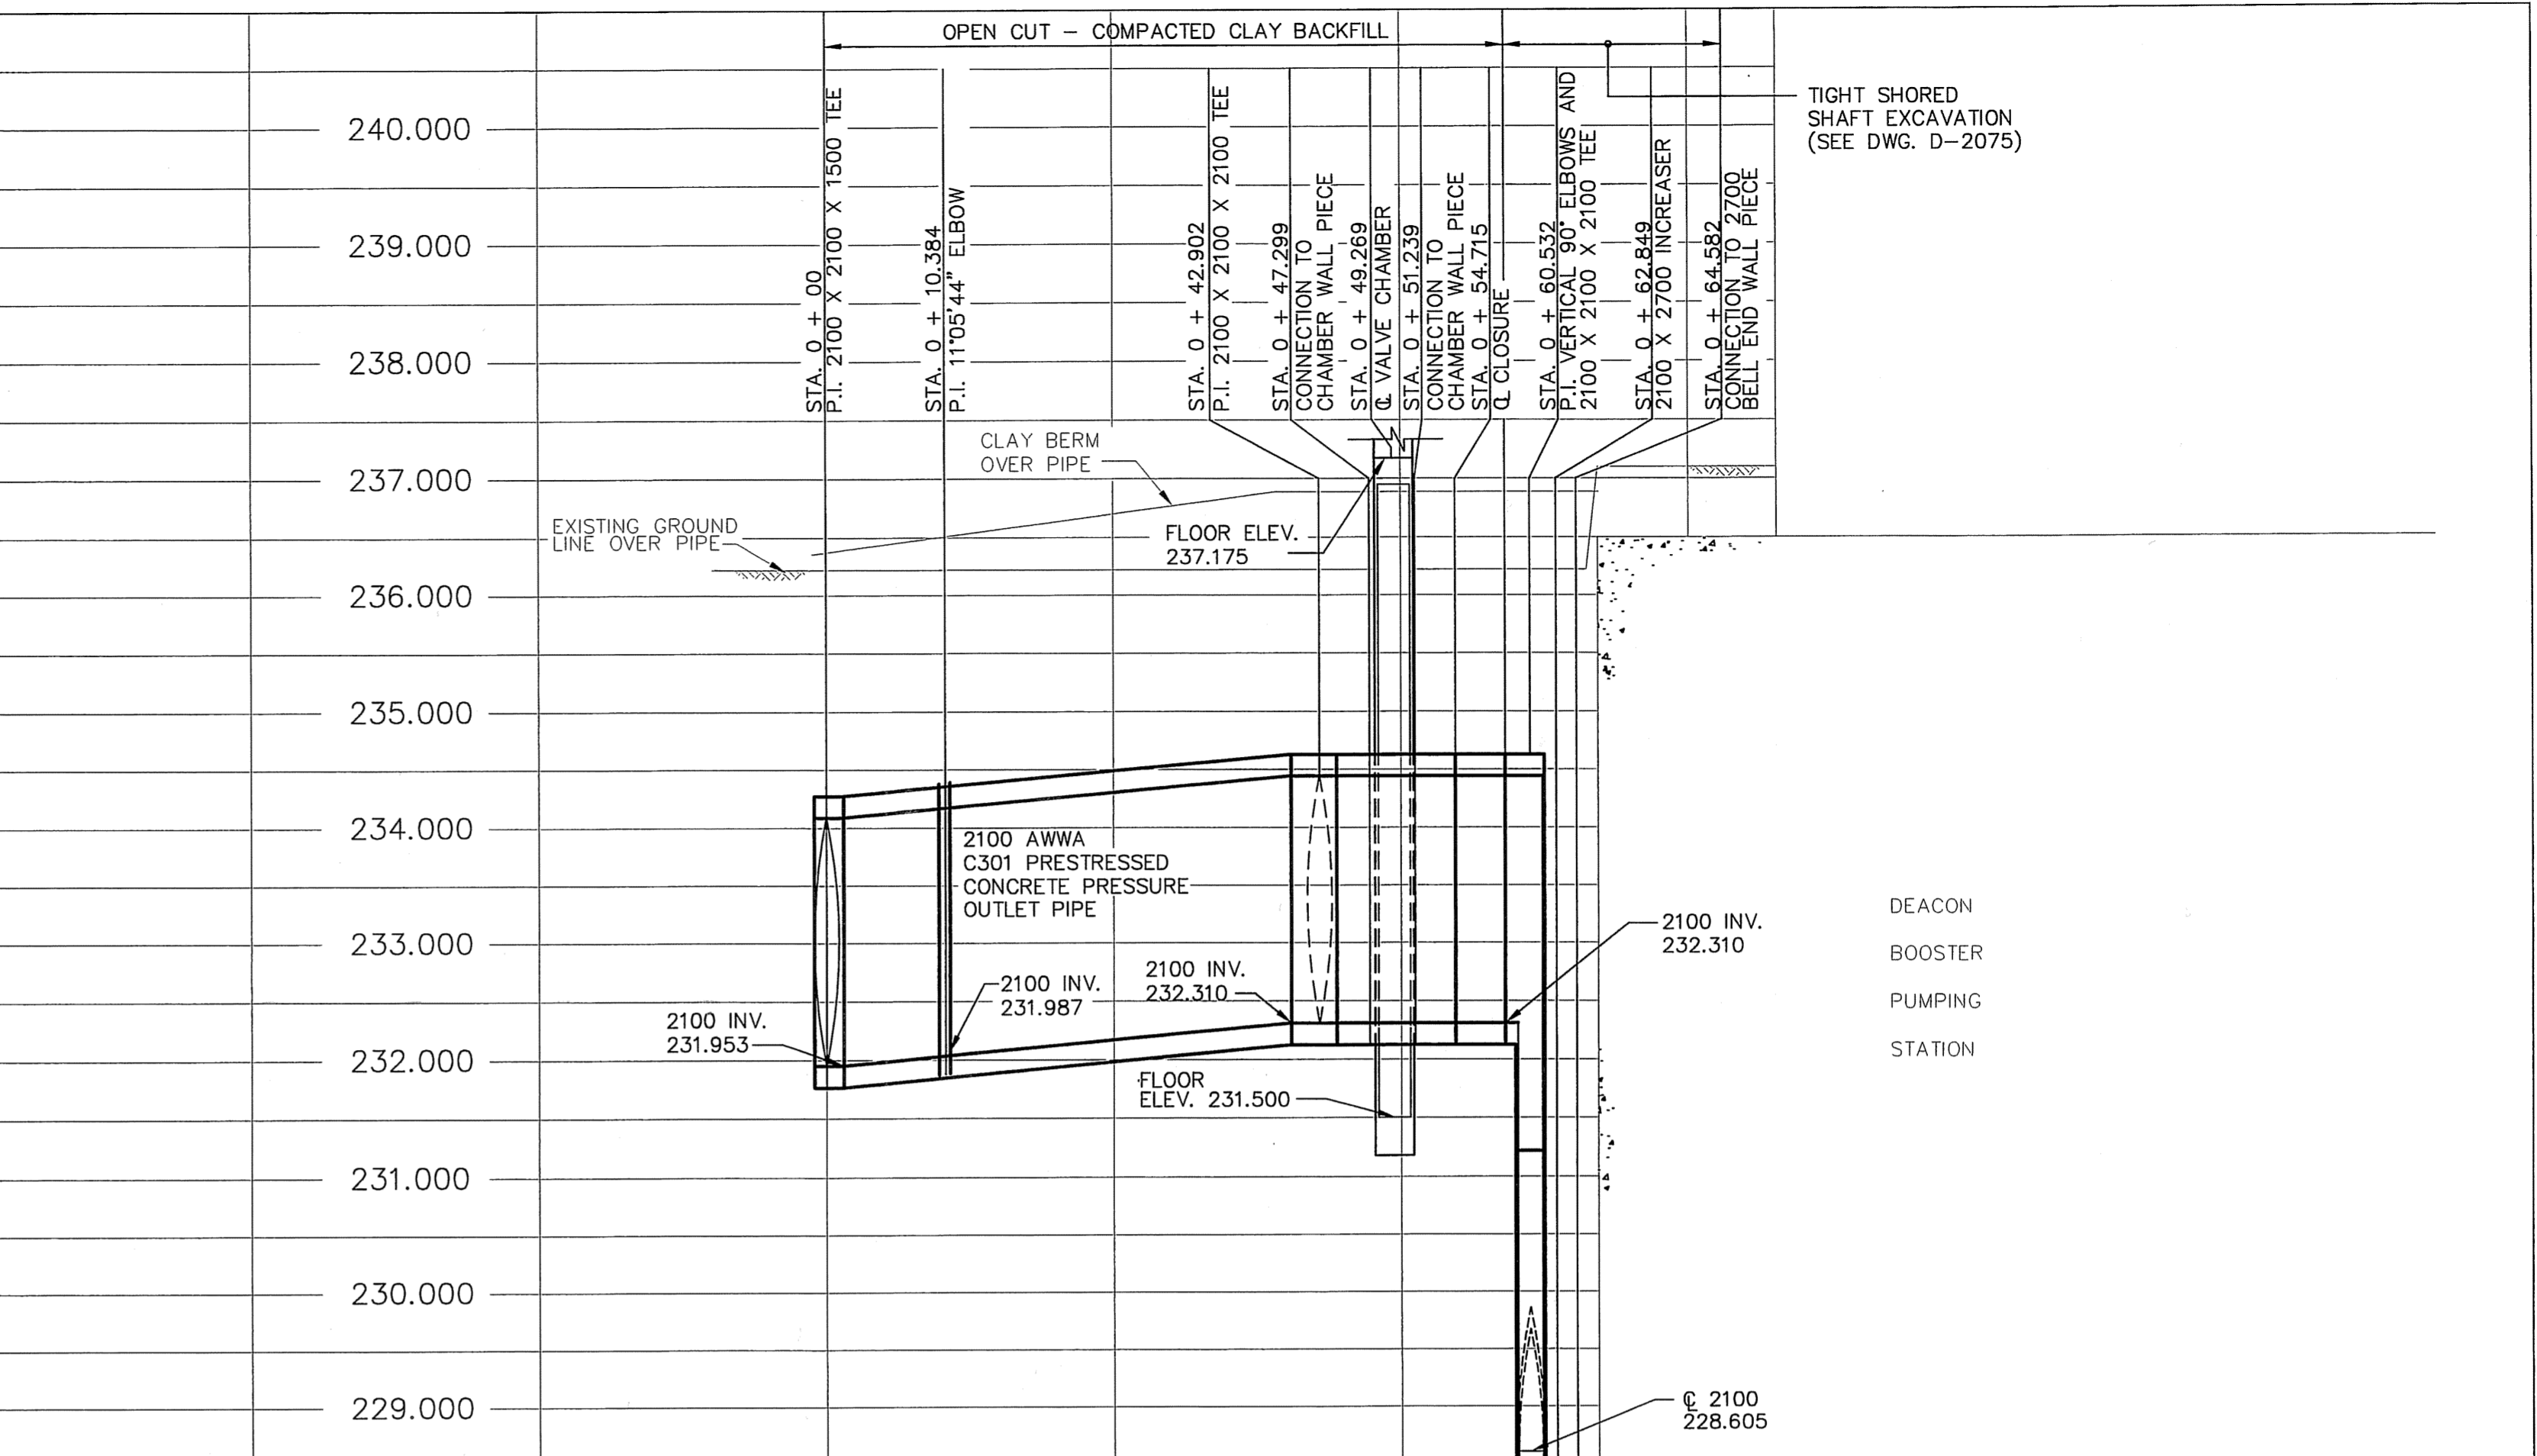

Prepared By: <i>The Engineering Division of the Waterworks, Waste and Disposal Department</i>		ENGINEER'S SEAL ORIGINAL SIGNED BY J. E. COMEAU 1995.01.30	THE CITY OF WINNIPEG WORKS AND OPERATIONS DIVISION WATERWORKS WASTE AND DISPOSAL DEPARTMENT
DESIGNED BY TW CHECKED BY TW/KMD DRAWN BY MTS/TM APPROVED BY JEC	HORIZ. SCALE 1:500 VERTICAL SCALE 1:50 RELEASED FOR CONSTRUCTION DATE 1995 01 20	TENDER 95-2 AUTOCADR2000	DEACON RESERVOIR EXPANSION CONSTRUCTION OF CELL 3 AND CELL 4 CELL 3 OUTLET PIPING FROM 172 METRES NORTH OF CELL 3 TO DEACON BOOSTER PUMPING STATION AND BRANCH 1/II INTERCONNECTION PLAN AND PROFILE
SHEET OF CITY DRAWING NUMBER D-2074			

D-2074