




CODE


1. PENTHOUSE
2. CHIMNEY
3. AIR COND. UNITS
4. SIGN SUPPORT
5. VENTILATOR
6. VENT PIPE
7. DRAIN
8. SKYLIGHT
9. EAVESTROUGH
10. FIRE WALL
11. TANK
12. STUB COLUMN
13. GRAVEL STOP
14. HATCH
15. SCUPPER
16. PITCH BOXES
17. ANTENNA
18. GUYWIRE
- 19.
- 20.

==== PARAPET



AREA "A"

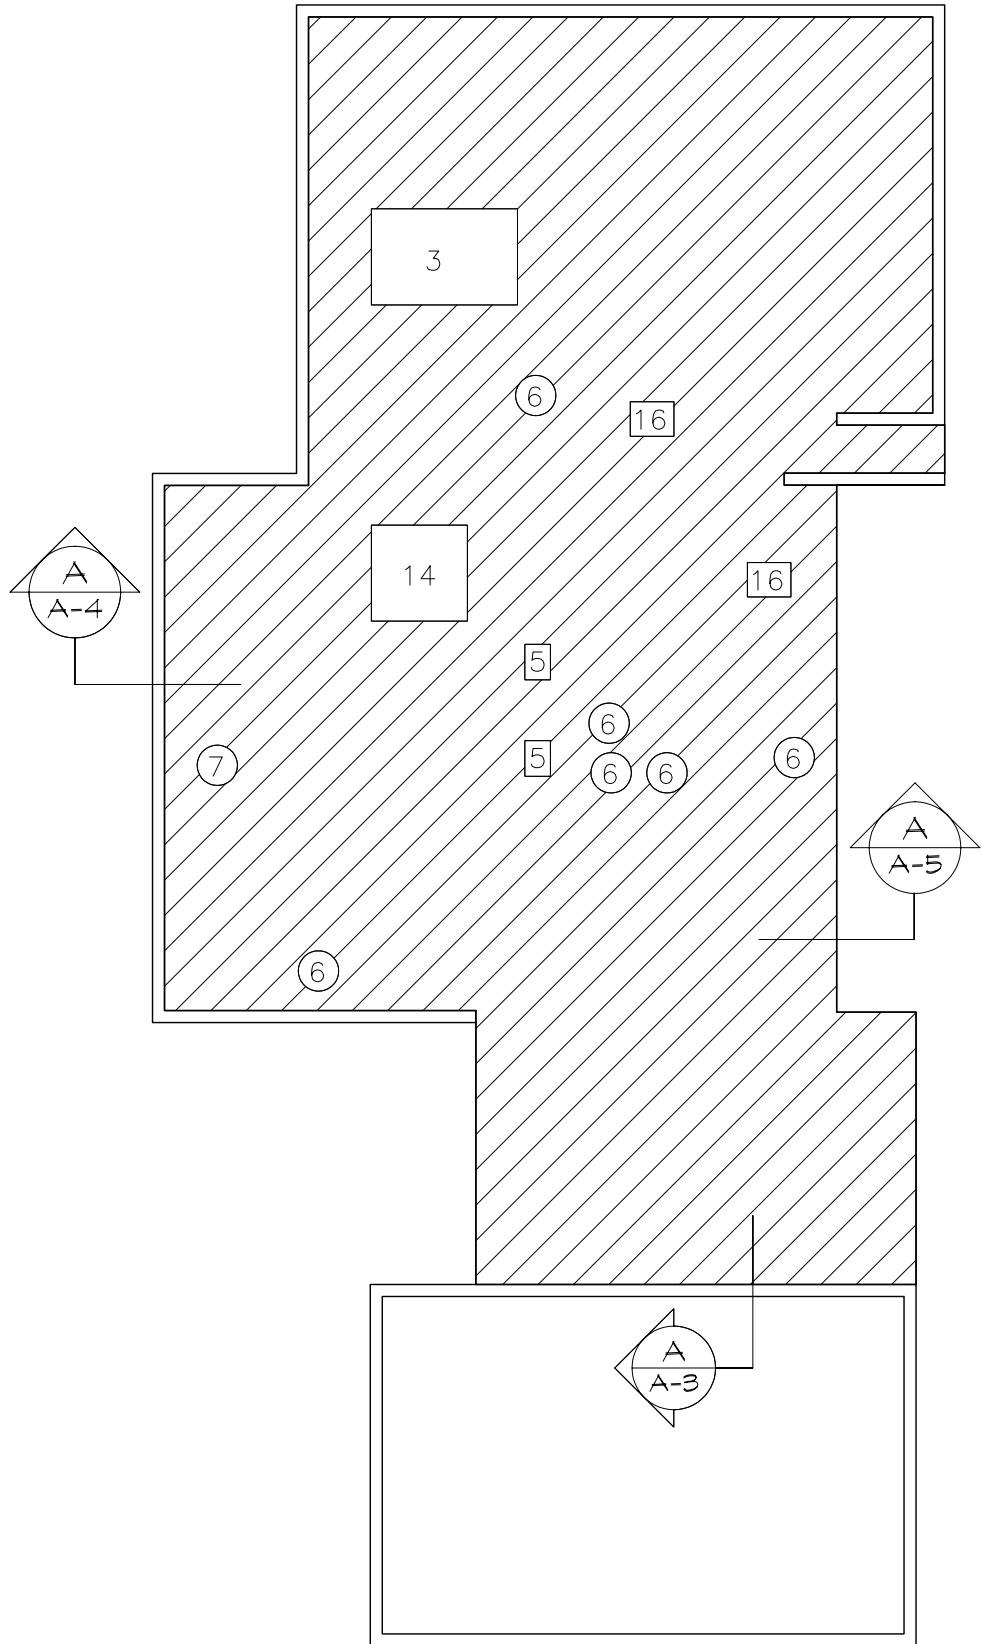

 CITY OF WINNIPEG PLANNING, PROPERTY & DEVELOPMENT DEPARTMENT CIVIC ACCOMMODATIONS DIVISION 300-65 GARRY STREET R3C 4K4		PROJECT DISTRICT 2 POLICE STATION ROOF REPLACEMENT 210 LYLE STREET		SHEET TITLE ROOF PLAN	
DRAWN BY	CHECKED BY	APPROVED BY	DATE	SCALE	SHEET NO.
DNJ	LOR	LOR	2005.05.24	1/16"=1'-0"	A-1
			eFILE 2005046V0.dwg/A1	PROJECT NO. 2005-046	