


PLAN VIEW
SCALE: 1:50

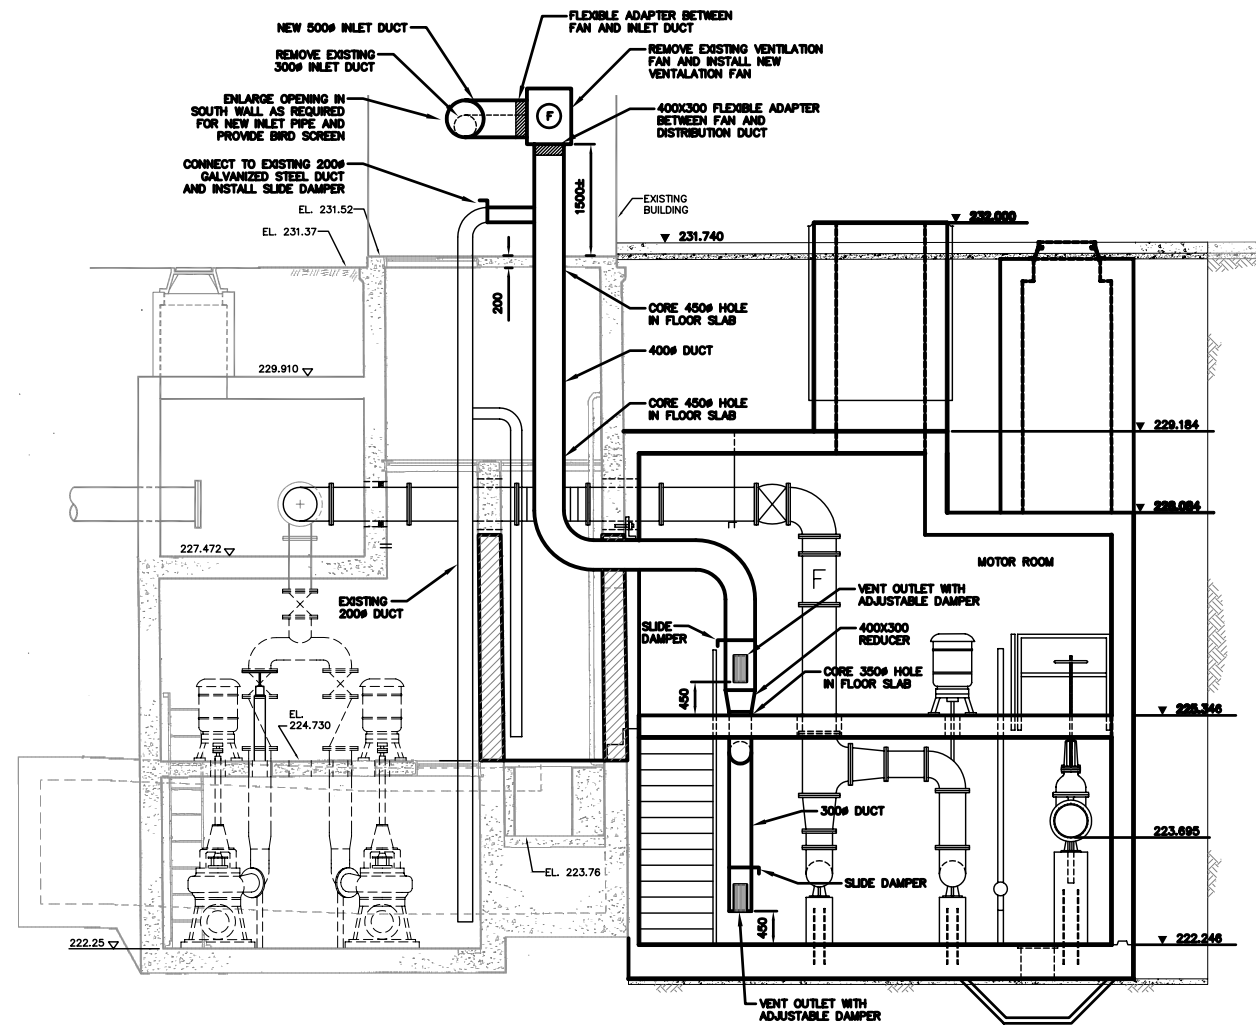

SECTION A-A
SCALE: 1:50

- NOTES:**
1. EXACT LOCATION OF NEW DUCTS TO BE CONFIRMED ON SITE.
 2. VENT OUTLET OPENINGS TO BE 200 X 400 IN SIZE.

METRIC
WHOLE NUMBERS INDICATE MILLIMETRES
DECIMALIZED NUMBERS INDICATE METRES

WARNING

IF POWER EQUIPMENT OR EXPLOSIVES ARE TO BE USED FOR EXCAVATION ON THIS PROJECT THE CONTRACTOR LOCATION OF EXCAVATION.
1) NOTIFY THE GAS COMPANY OF THE PROPOSED LOCATION OF EXCAVATION.
2) TAKE PRECAUTION TO AVOID DAMAGE TO GAS COMPANY INSTALLATIONS.
SEE PROVINCIAL REGULATION 210/72 FOR DETAILS

B.M. ELEV.	FIELD BOOK #	CITY OF WINNIPEG WATER AND WASTE ENGINEERING DIVISION		ENGINEER'S SEAL	THE CITY OF WINNIPEG WATER AND WASTE DEPARTMENT
POSTED TO LBIS					
		DESIGNED BY TW/BS	CHECKED BY TW/BS	BID OPPORTUNITY: 52-2005 FILENAME: MAGER_PS_DWG1_DWG2.dwg PLOT DATE: 2005 02 15	2005 MAGER DRIVE WASTEWATER PUMPING STATION EXPANSION VENTILATION PLAN AND SECTION VIEWS
		DRAWN BY CJH	APPROVED BY		
		HOR. SCALE 1:50 VERTICAL	RELEASED FOR CONSTRUCTION		
NO. REVISIONS	DATE BY	DATE 2005 02 15	DATE		
					SHEET 12 OF 12
					CITY DRAWING NUMBER 05560