
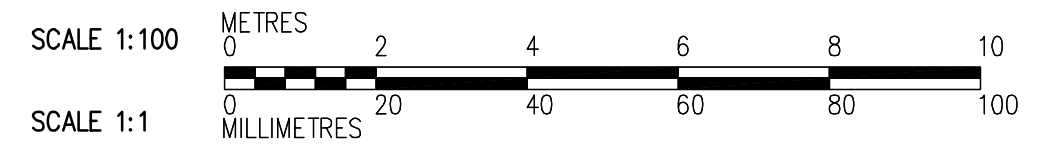


NOTES:
 1. DESIGN LIVE LOAD IS 14.4 kPa.
 2. FOR BEAM AND COLUMN SCHEDULE SEE DWG WC-S0515.

REBAR LEGEND:
 ——— TOP BARS
 - - - - - BOTTOM BARS

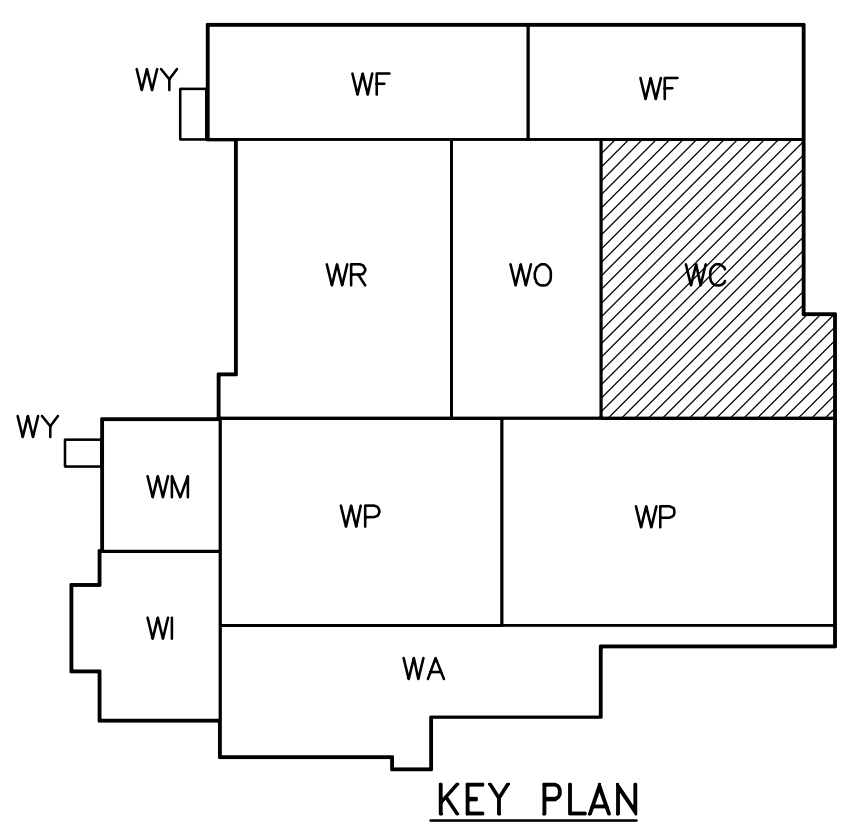

THIRD FLOOR PLAN
1:100

<p>APEGN Certificate of Authorization CH2M HILL Canada Ltd. No. 1441 Expiry: April 30, 2006</p>	B.M. ELEV.		<p>Frederickson Cooper ARCHITECTS</p>	<p>EarthTech A Tyco International Ltd. Company</p>	ENGINEER'S SEAL	<p>THE CITY OF WINNIPEG WATER AND WASTE DEPARTMENT ENGINEERING DIVISION</p>
	DESIGNED BY EL CHECKED BY AP				ORIGINAL SIGNED BY D. KRUGER	
	DRAWN BY RL/DJ APPROVED BY DJT		CONSULTANT DRAWING NO. WC-S0131	WATER TREATMENT PLANT CHEMICAL FEED SYSTEMS FOUNDATIONS AND CONCRETE STRUCTURES	CITY FILE NUMBER SHEET OF	
	SCALE: 1:100 RELEASED FOR CONSTRUCTION BY: R. SOROKOWSKI		DATE 2005/07/07 DATE 2006/02/08	STRUCTURAL ELECTRICAL AND MECHANICAL ROOM AREA THIRD FLOOR PLAN	CITY DRAWING NUMBER 1-0601C-A-50131-001-01D	