



PARTIAL FIRST FLOOR PLAN
1:100

LOWER LEVEL PLAN
1:100

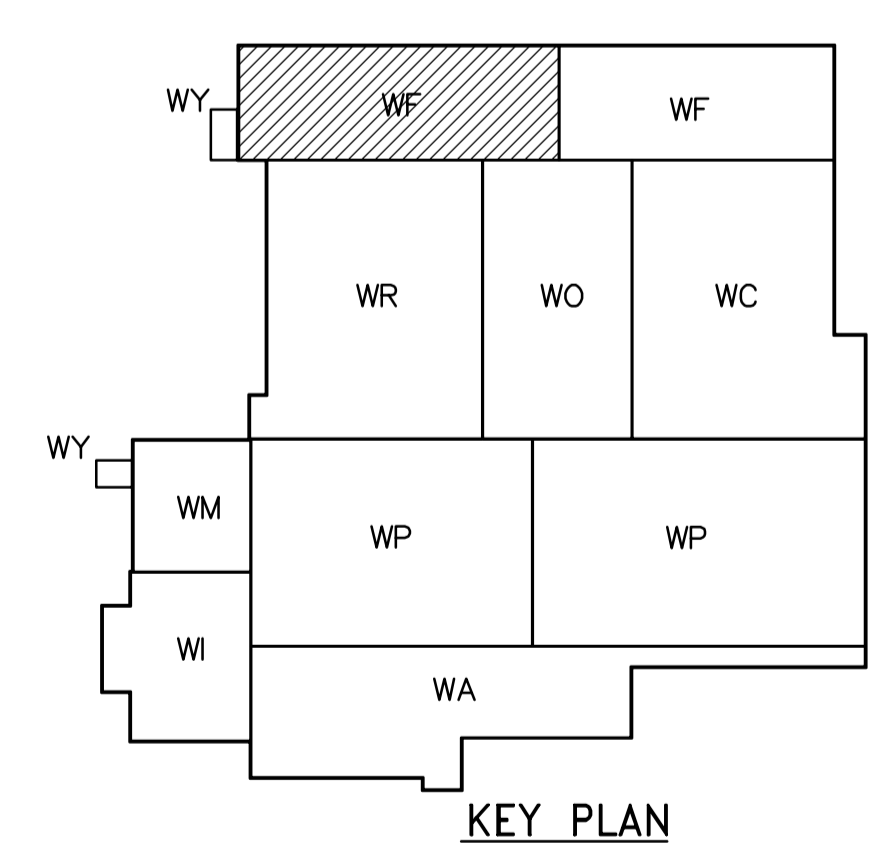

KEY PLAN

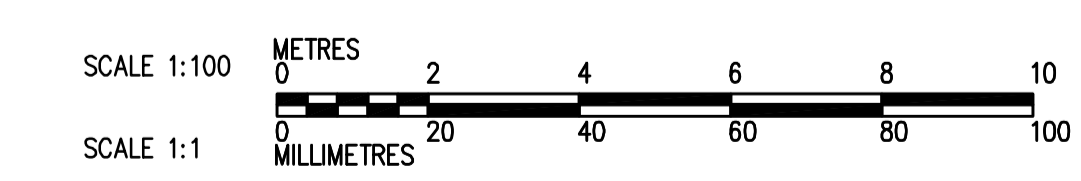

<p>APEGN Certificate of Authorization CH2M HILL Canada Ltd. No. 1441 Expiry: April 30, 2006</p>	<p>Frederickson Cooper ARCHITECTS</p>		<p>EarthTech A Tyco International Ltd. Company</p>		ENGINEER'S SEAL ORIGINAL SIGNED BY D.K. CUDDINGTON 2006/02/06	<p>THE CITY OF WINNIPEG WATER AND WASTE DEPARTMENT ENGINEERING DIVISION</p>
	DESIGNED BY JZ/SW DRAWN BY JMcP SCALE: 1:100		CHECKED BY DL APPROVED BY DJT RELEASED FOR CONSTRUCTION BY: R. SOROKOWSKI		CONSULTANT DRAWING NO. WF-H9104	
	B.M. ELEV.		NO. REVISIONS DATE BY			
	01 583-2005 ADDENDUM 3 06/03/10 JZ 00 ISSUED FOR TENDER 2006/02/03 SW		DATE 2005/08/02 DATE 2006/02/08		WATER TREATMENT PLANT FILTRATION FOUNDATIONS AND CONCRETE STRUCTURES PLUMBING PIPE EMBEDS FILTRATION AREA 1 LOWER LEVEL PLAN	