


- NOTES:**
- DESIGN LIVE LOAD IS 14.4 kPa.
 - FOR BEAM AND COLUMN SCHEDULE SEE DWG WO-S015.
 - APPROXIMATE LOCATIONS FOR EQUIPMENT PADS ARE SHOWN.


REBARS LEGEND:

—— TOP BARS
 - - - - BOTTOM BARS

△01 BACKGROUND HIDDEN LINES REVISED OR SHOWN FOR CLARITY

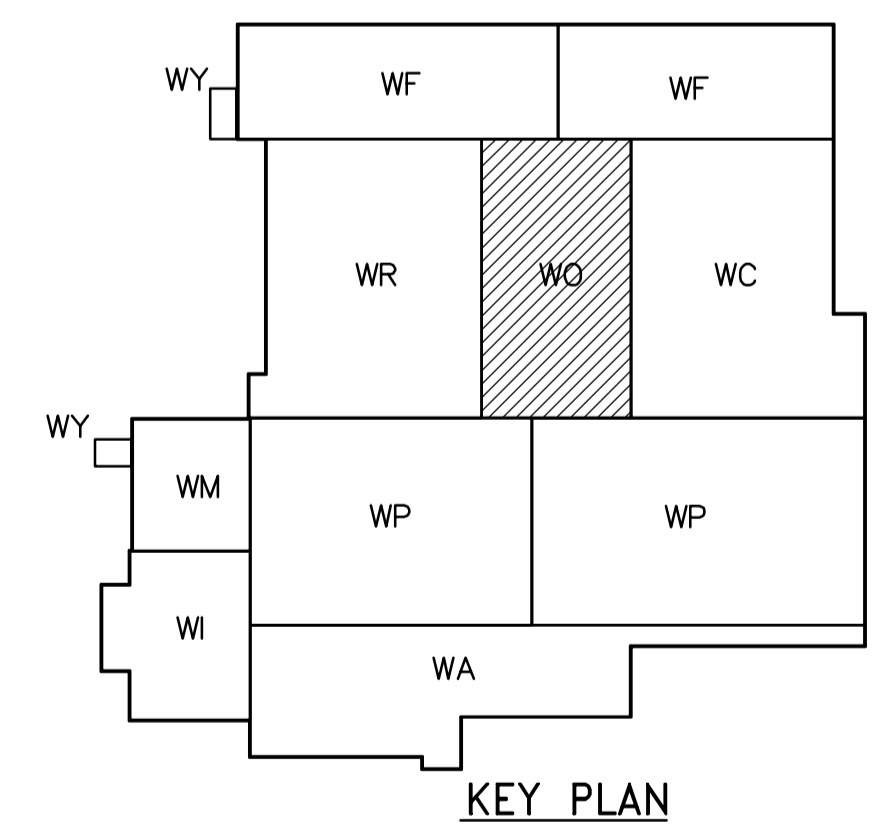

THIRD FLOOR PLAN
 1:100

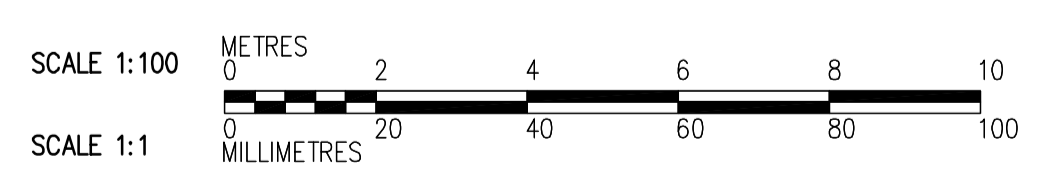

 APECA Certificate of Authorization CH2M HILL Canada Ltd. No. 1441 Expiry: April 30, 2006	 Frederickson Cooper ARCHITECTS		 A Terra International Ltd. Company		ENGINEER'S SEAL ORIGINAL SIGNED BY D. KRUGER 2006/02/06	 THE CITY OF WINNIPEG WATER AND WASTE DEPARTMENT ENGINEERING DIVISION WATER TREATMENT PLANT OZONE FOUNDATIONS AND CONCRETE STRUCTURES STRUCTURAL OZONATION AREA THIRD FLOOR PLAN	CITY FILE NUMBER SHEET OF
	DESIGNED BY MH CHECKED BY AP	DRAWN BY RL APPROVED BY DJT	SCALE: 1:100 RELEASED FOR CONSTRUCTION BY: R. SOROKOWSKI		CONSULTANT DRAWING NO. WO-S0131		CITY DRAWING NUMBER 1-06010-A-S0131-001-01D
	NO. REVISIONS 01 583-2005 ADDENDUM 3 06/03/10 MH 00 ISSUED FOR TENDER 06/02/03 MH	DATE BY 2005/07/07	DATE 2006/02/08				