




- NOTES:**
- FOR BEAM AND COLUMN SCHEDULE SEE DWG WP-S0515.
 - PC 'X' - DENOTES PILE CAP TYPE, SEE DWG WP-S0401 FOR DETAILS.

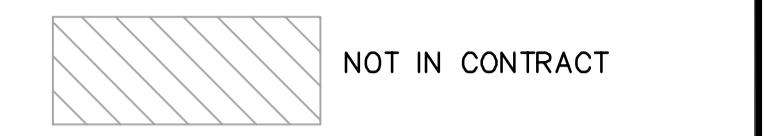

- REBAR LEGEND:**
- TOP BARS
 - BOTTOM BARS

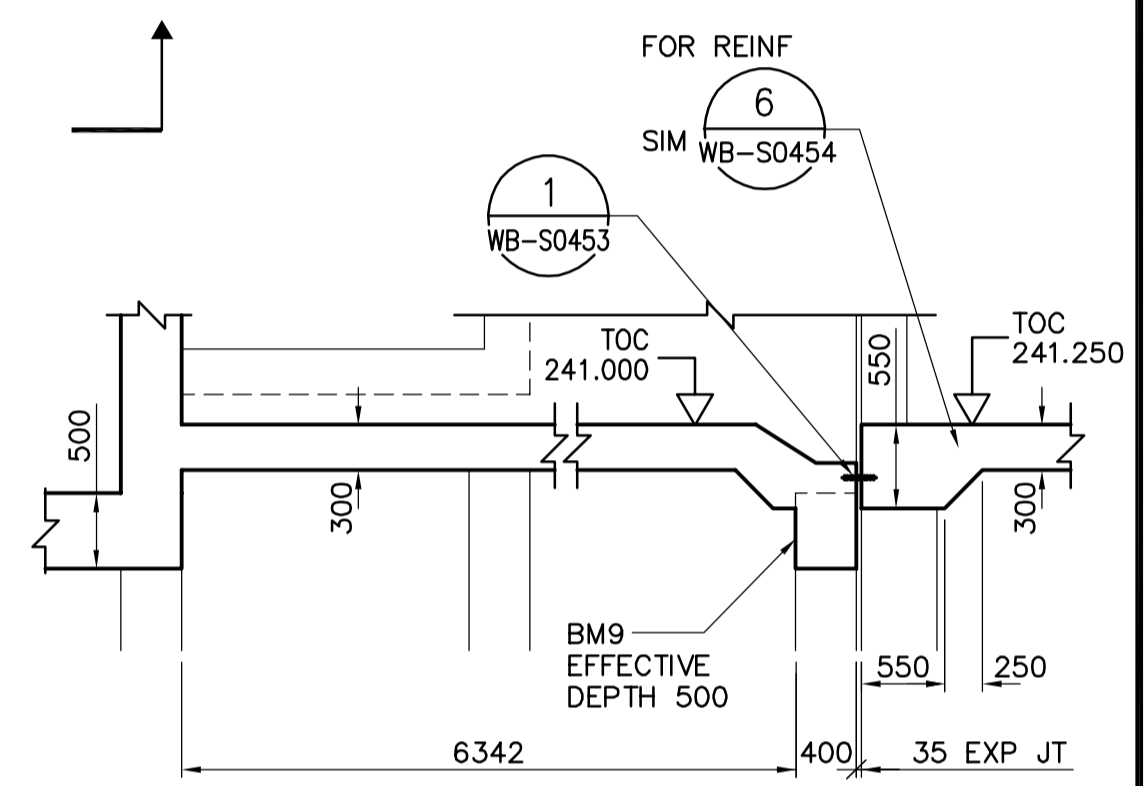


SECTION L
1:50

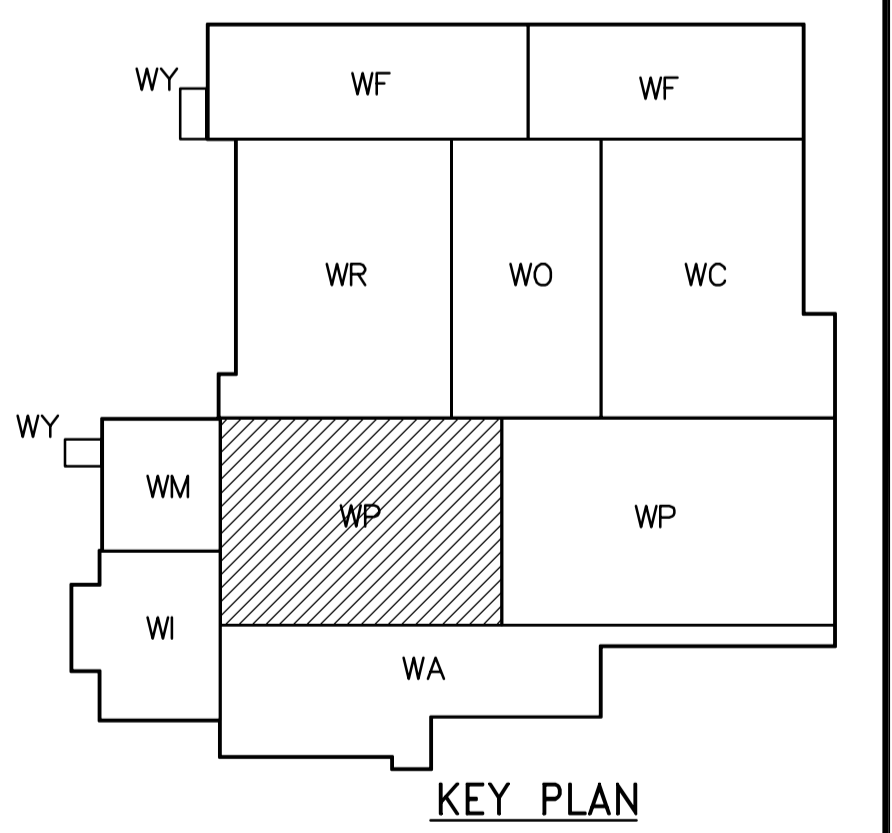

KEY PLAN

CHANNEL FLOOR PLAN
1:100

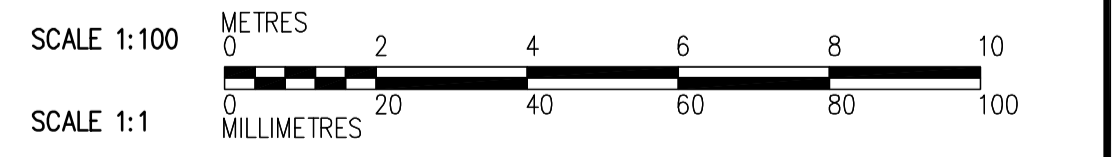

<p>Certificate of Authorization CH2M HILL Canada Ltd. No. 1441 Expiry: April 30, 2006</p>	<p>Frederickson Cooper ARCHITECTS</p>		<p>A Yeo International Ltd. Company</p>		ENGINEER'S SEAL ORIGINAL SIGNED BY D. KRUGER 2006/02/06	<p>THE CITY OF WINNIPEG WATER AND WASTE DEPARTMENT ENGINEERING DIVISION</p> <p>WATER TREATMENT PLANT FLOCCULATION AND DAF FOUNDATIONS AND CONCRETE STRUCTURES</p> <p>STRUCTURAL FLOC/DAF AREA 1 CHANNEL FLOOR PLAN</p>	CITY FILE NUMBER SHEET OF
	DESIGNED BY: RZ CHECKED BY: AP		DRAWN BY: RL APPROVED BY: DJT		CONSULTANT DRAWING NO. WP-S0121		CITY DRAWING NUMBER 1-060P-A-8012-001-0D
	SCALE: 1:100		RELEASED FOR CONSTRUCTION BY: R. SOROKOWSKI				
	NO. REVISIONS: 01 DATE: 06/03/10 BY: RZ		DATE: 2005/06/28		DATE: 2006/02/08		