




LOWER LEVEL PLAN
1:100

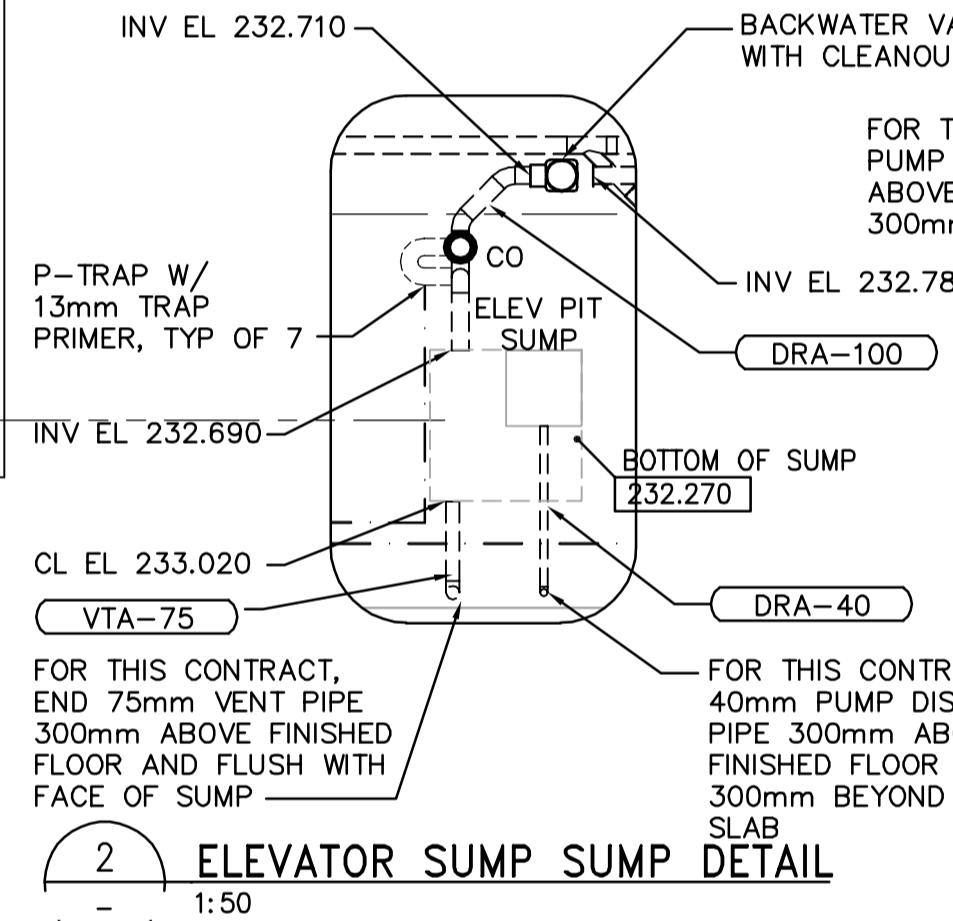


ELEVATOR SUMP SUMP DETAIL
1:50

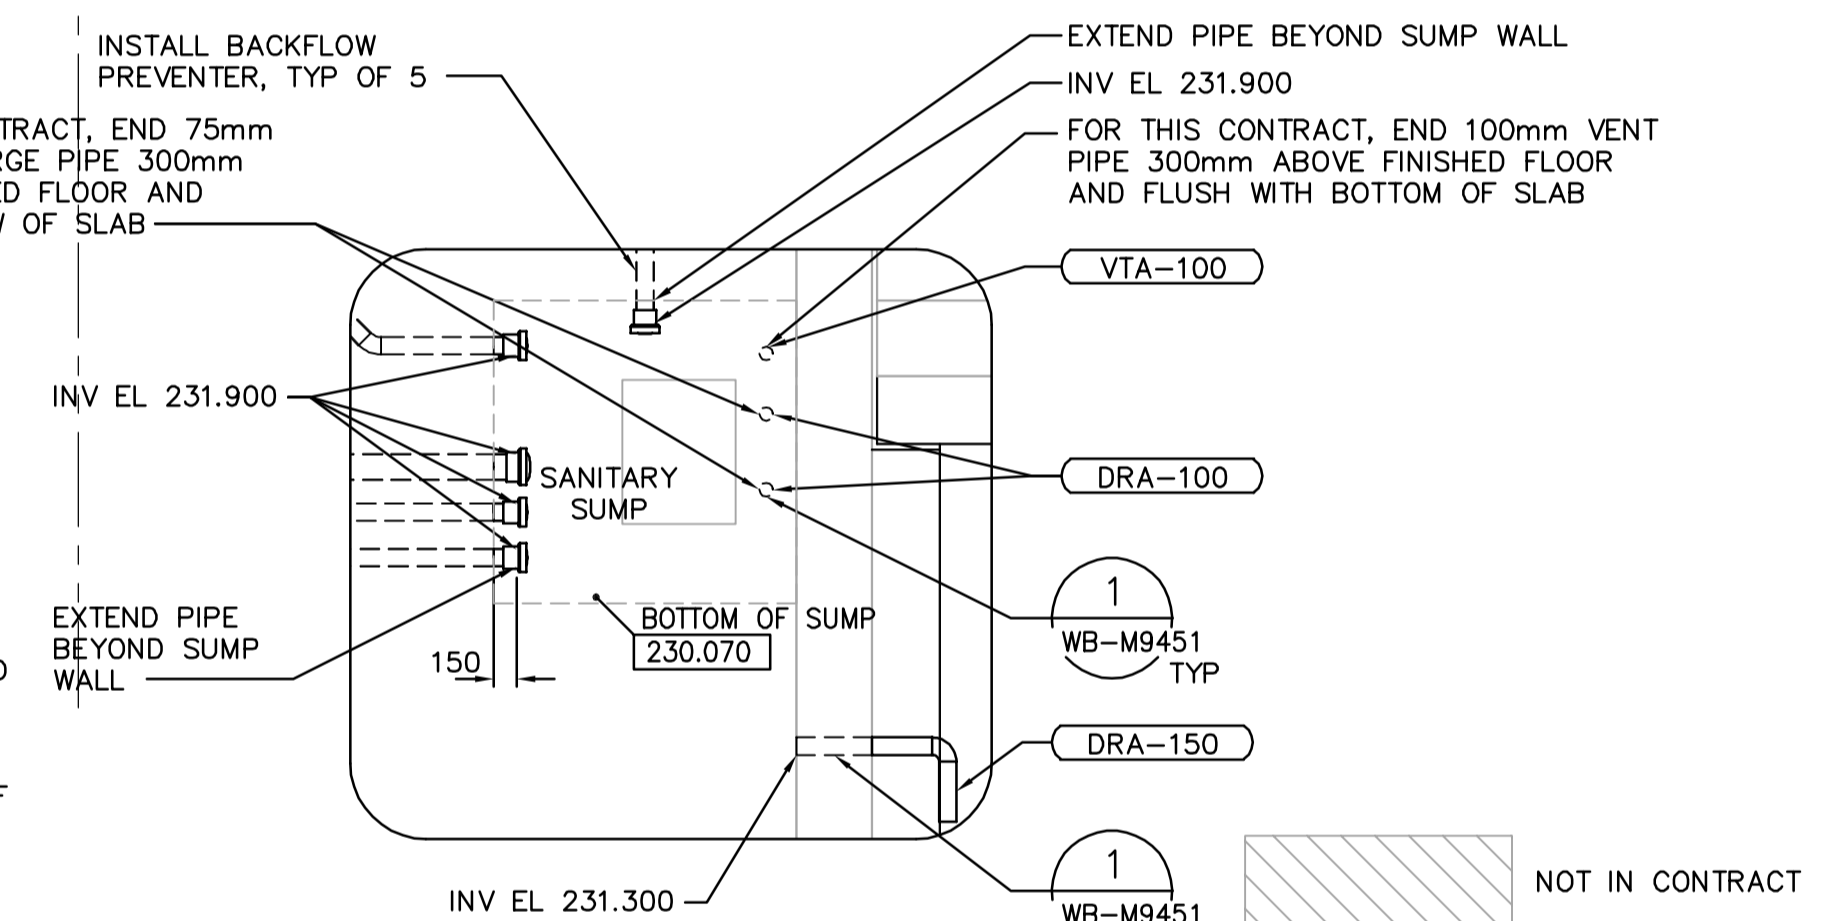


SOUTH SUMP DETAIL
1:50

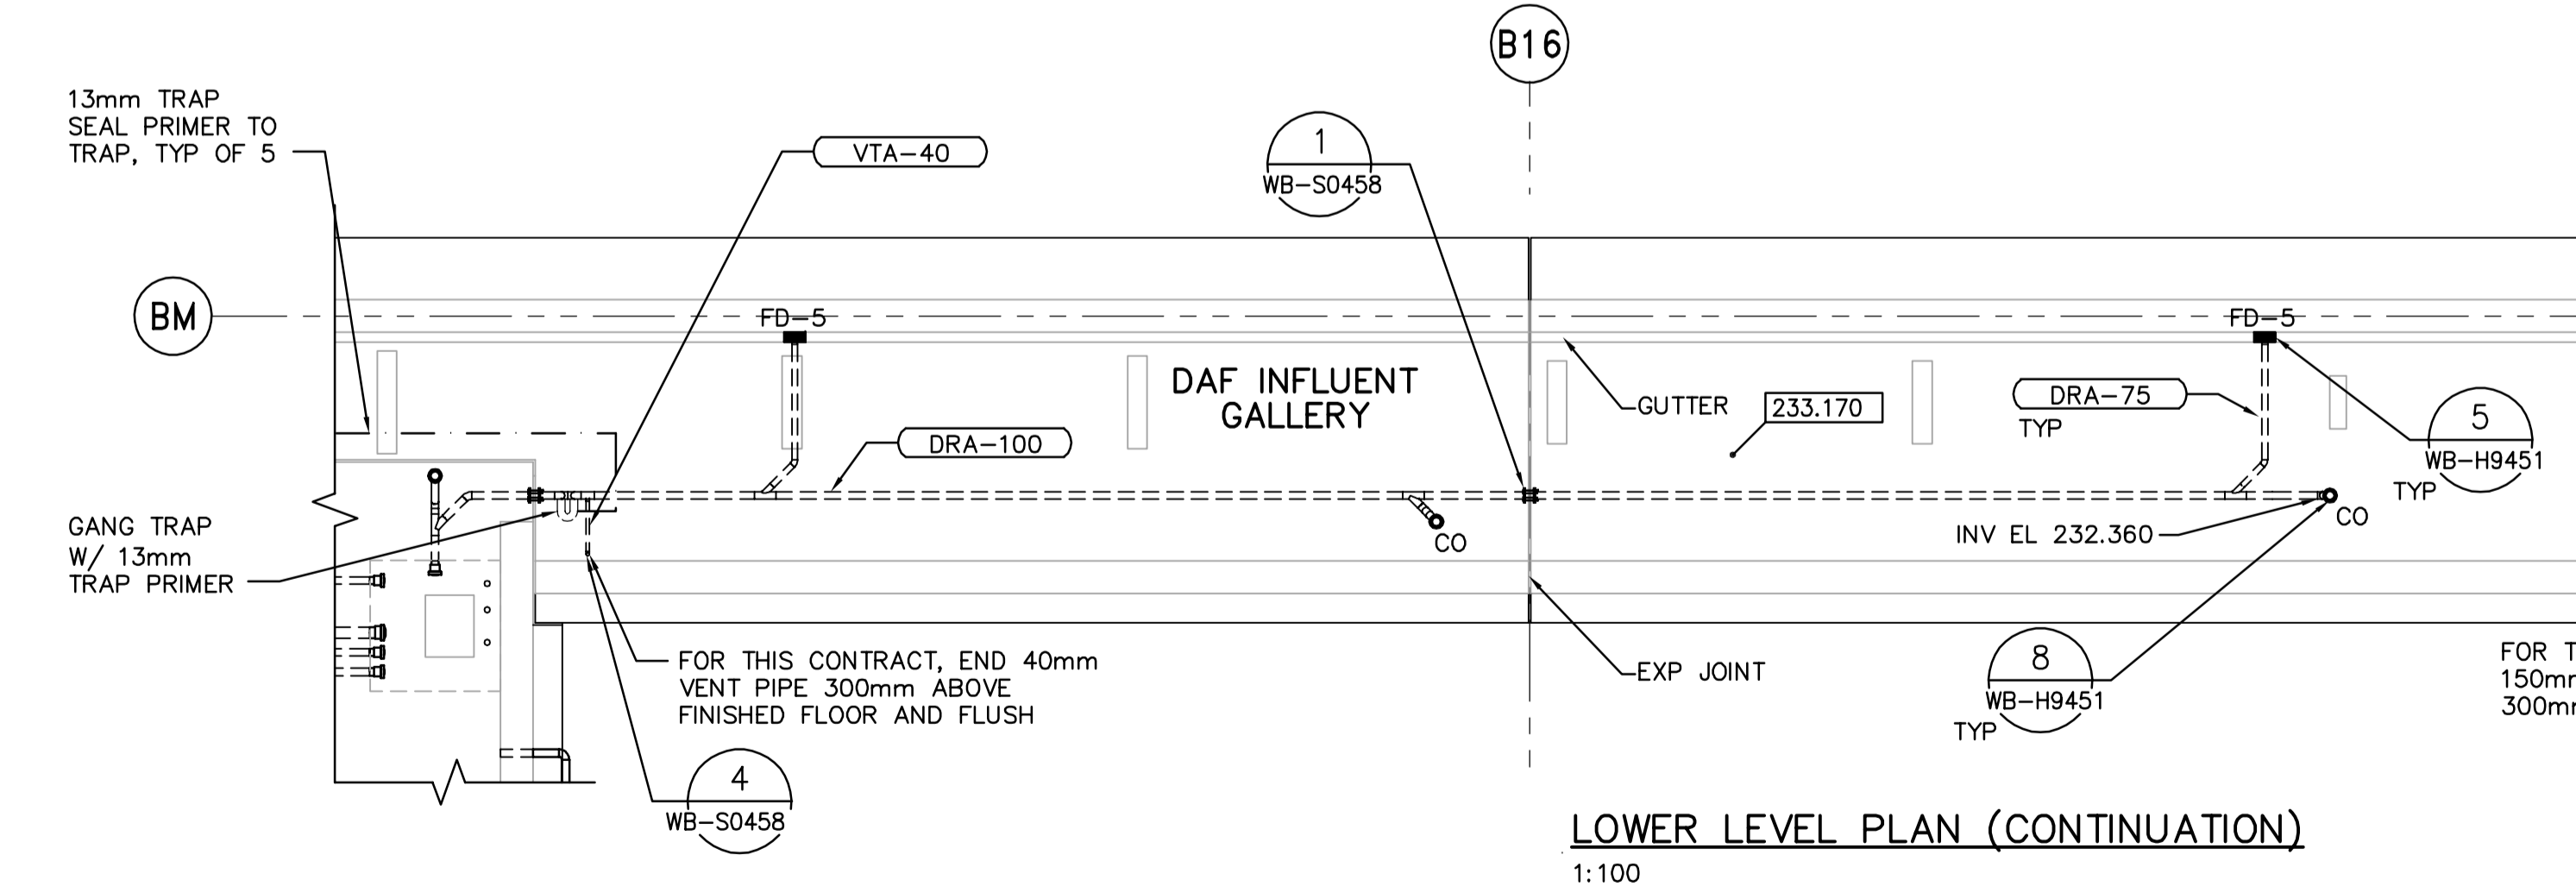


LOWER LEVEL PLAN (CONTINUATION)
1:100

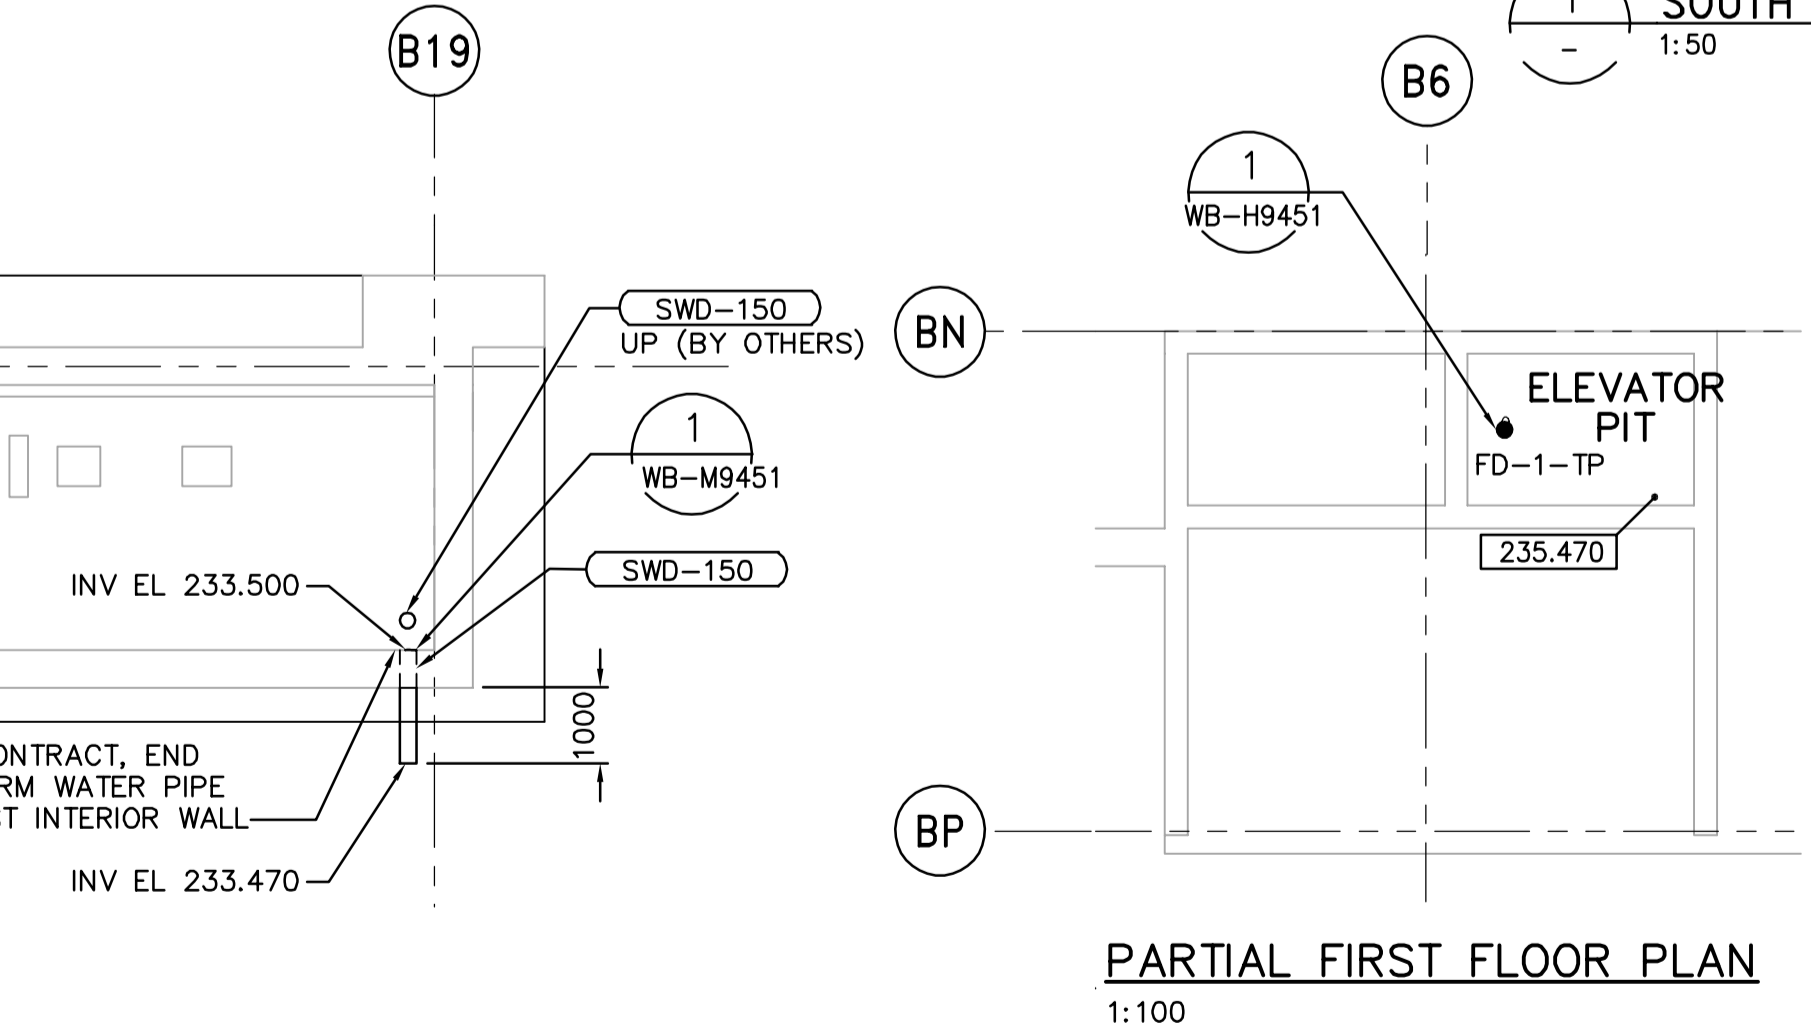

PARTIAL FIRST FLOOR PLAN
1:100

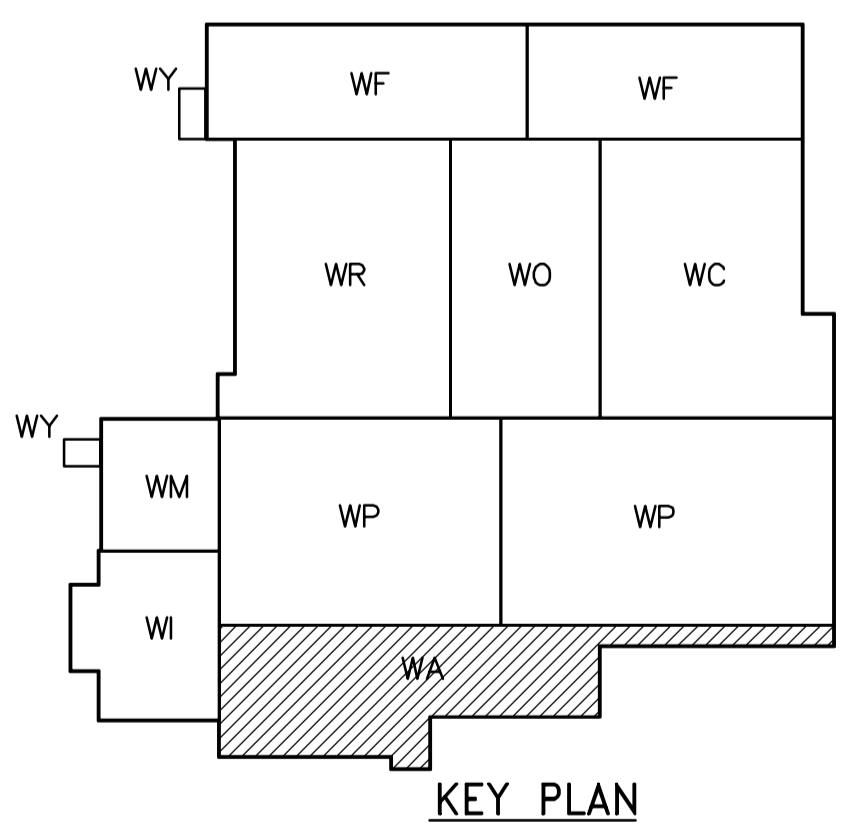

KEY PLAN

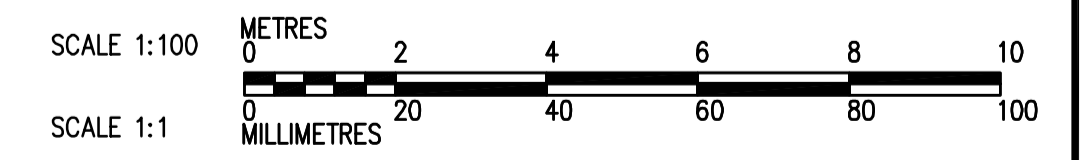

| | | | | | |
|----------------------------------------------------------------------------------------------------------|--------------------|---------------------------------------------|----------------------------------------------------------|--------------------------------------------------------------------------|--------------------------------------------------------------------------------------------|
| <p>Certificate of Authorization CH2M HILL Canada Ltd. No. 1441 Expiry: April 30, 2006</p> | B.M. ELEV. | <p>Frederickson Cooper ARCHITECTS</p> | <p>EarthTech A Veolia International Ltd. Company</p> | ENGINEER'S SEAL | <p>THE CITY OF WINNIPEG WATER AND WASTE DEPARTMENT ENGINEERING DIVISION</p> |
| | DESIGNED BY: JZ/SW | | | CHECKED BY: DL | |
| | DRAWN BY: JMcP | APPROVED BY: DJT | 2006/02/06 | WATER TREATMENT PLANT ADMINISTRATION FOUNDATIONS AND CONCRETE STRUCTURES | |
| | SCALE: 1:100 | RELEASED FOR CONSTRUCTION BY: R. SOROKOWSKI | CONSULTANT DRAWING NO. WA-H9102 | PLUMBING PIPE EMBEDS ADMINISTRATION AREA LOWER LEVEL PLAN | |
| 00 ISSUED FOR TENDER | 2006/02/03 SW | DATE: 2005/07/15 | DATE: 2006/02/08 | | CITY FILE NUMBER |
| NO. REVISIONS | DATE | BY | DATE | | SHEET OF |
| | | | | | CITY DRAWING NUMBER |
| | | | | | 1-0601A-A-H9102-001-00D |