

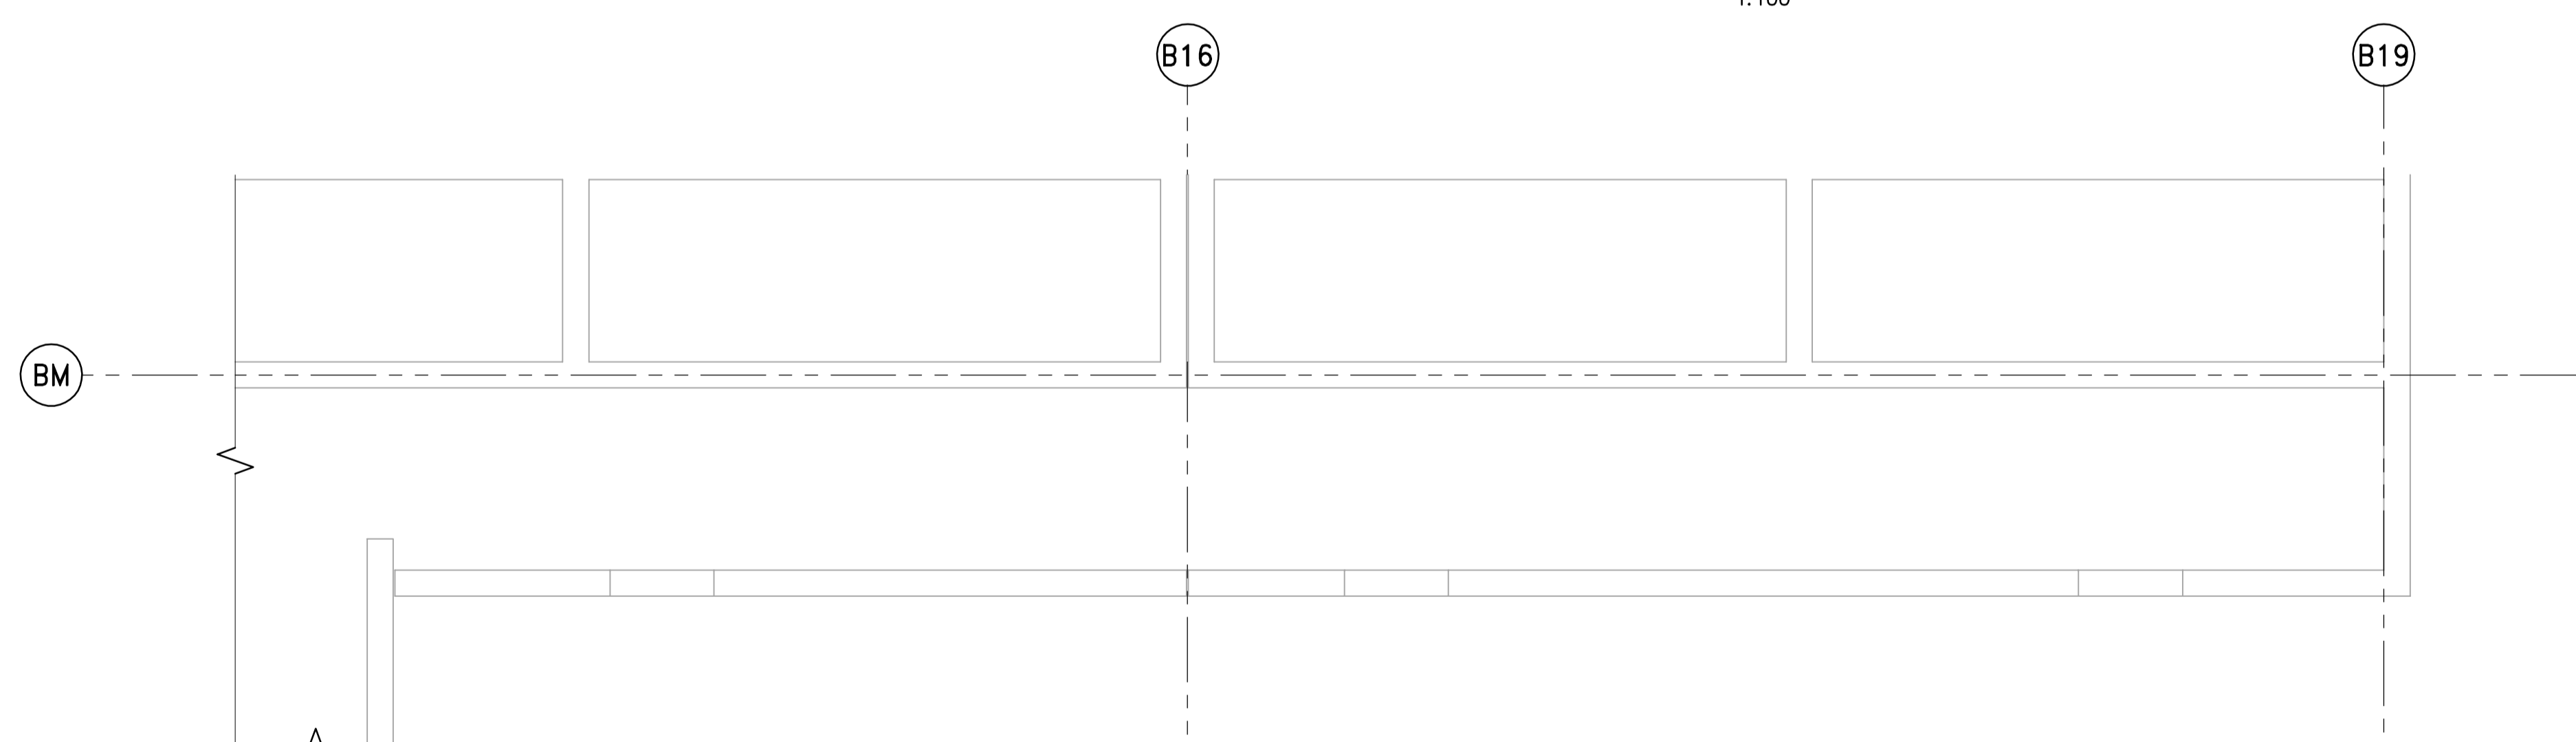


SECOND FLOOR PLAN
1:100

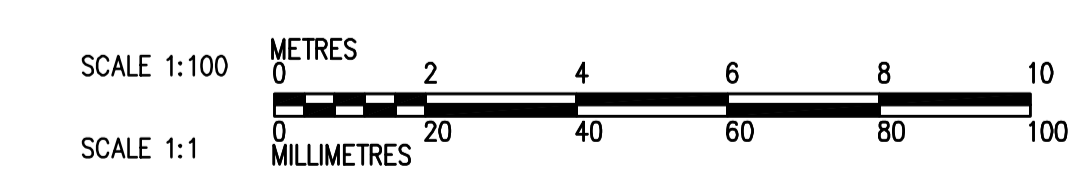

SECOND FLOOR PLAN (CONTINUATION)
1:100

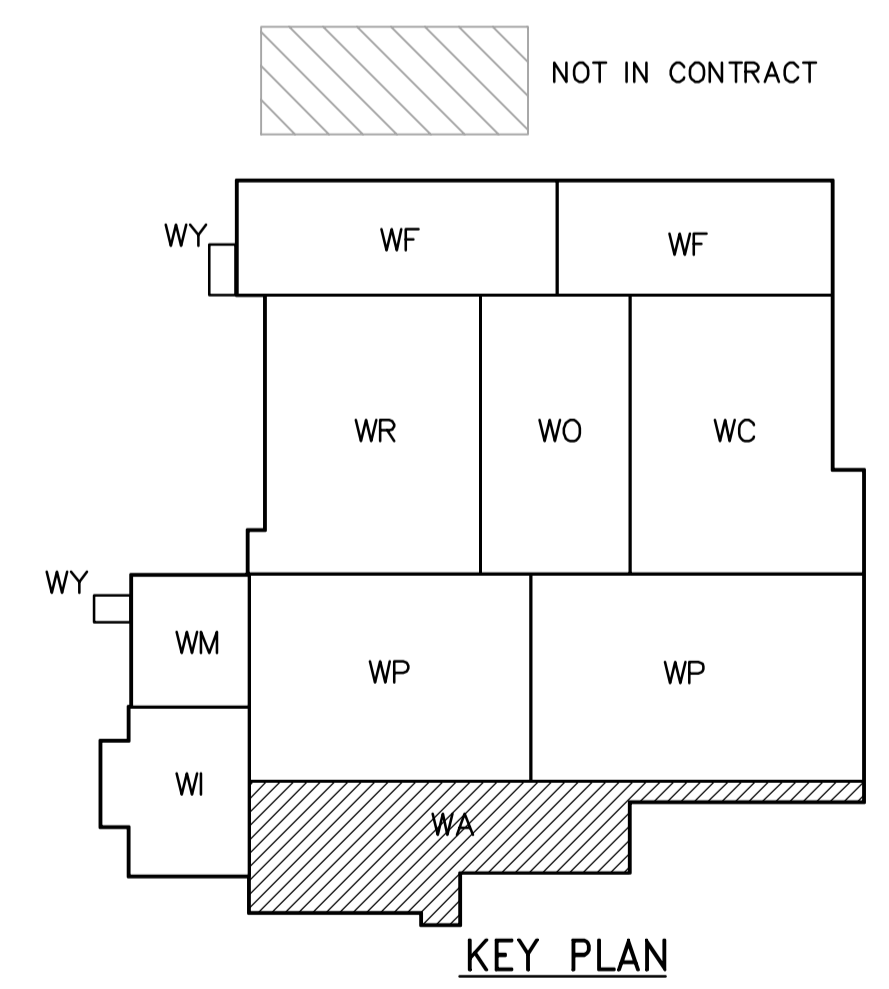

 Certificate of Authorization CH2M HILL Canada Ltd. No. 1441 Expiry: April 30, 2006	B.M. ELEV.	 Frederickson Cooper ARCHITECTS	 A Geo International Ltd. Company	ENGINEER'S SEAL ORIGINAL SIGNED BY D.K. CUDDINGTON 2006/02/06	 THE CITY OF WINNIPEG WATER AND WASTE DEPARTMENT ENGINEERING DIVISION
	DESIGNED BY: JZ/SW CHECKED BY: DL	CONSULTANT DRAWING NO. WA-H9122	WATER TREATMENT PLANT ADMINISTRATION FOUNDATIONS AND CONCRETE STRUCTURES		CITY FILE NUMBER SHEET OF
	DRAWN BY: JMcP APPROVED BY: DJT	RELEASED FOR CONSTRUCTION BY: R. SOROKOWSKI	PLUMBING PIPE EMBEDS ADMINISTRATION AREA SECOND FLOOR PLAN		CITY DRAWING NUMBER 1-0601A-A-H9122-001-00D
	SCALE: 1:100	NO. REVISIONS DATE BY	DATE: 2005/07/15	DATE: 2006/02/08	