

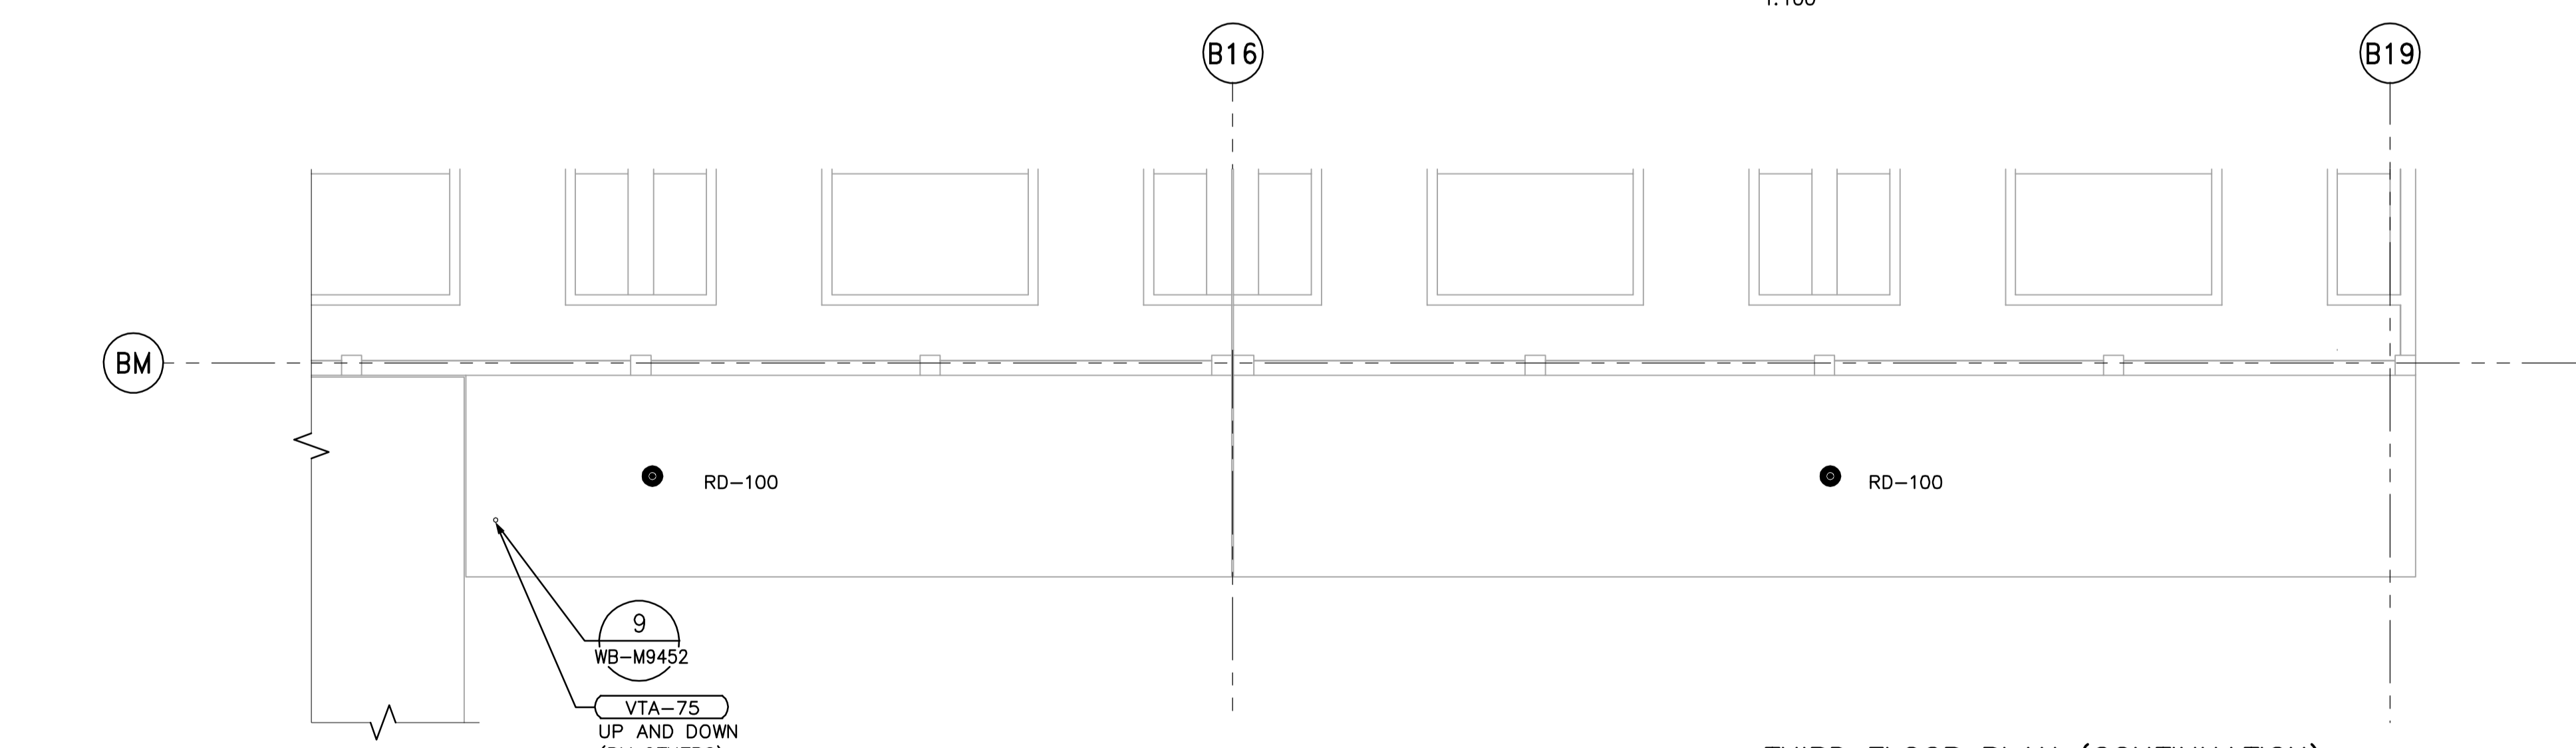


THIRD FLOOR PLAN  
1:100

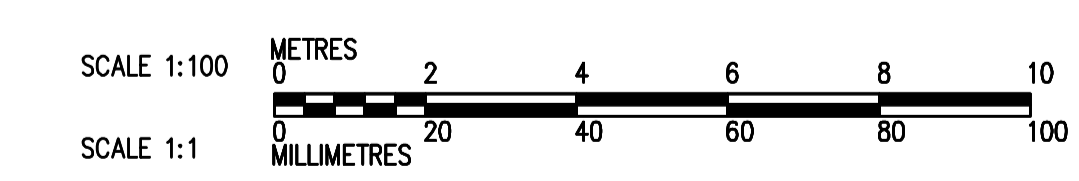

THIRD FLOOR PLAN (CONTINUATION)  
1:100

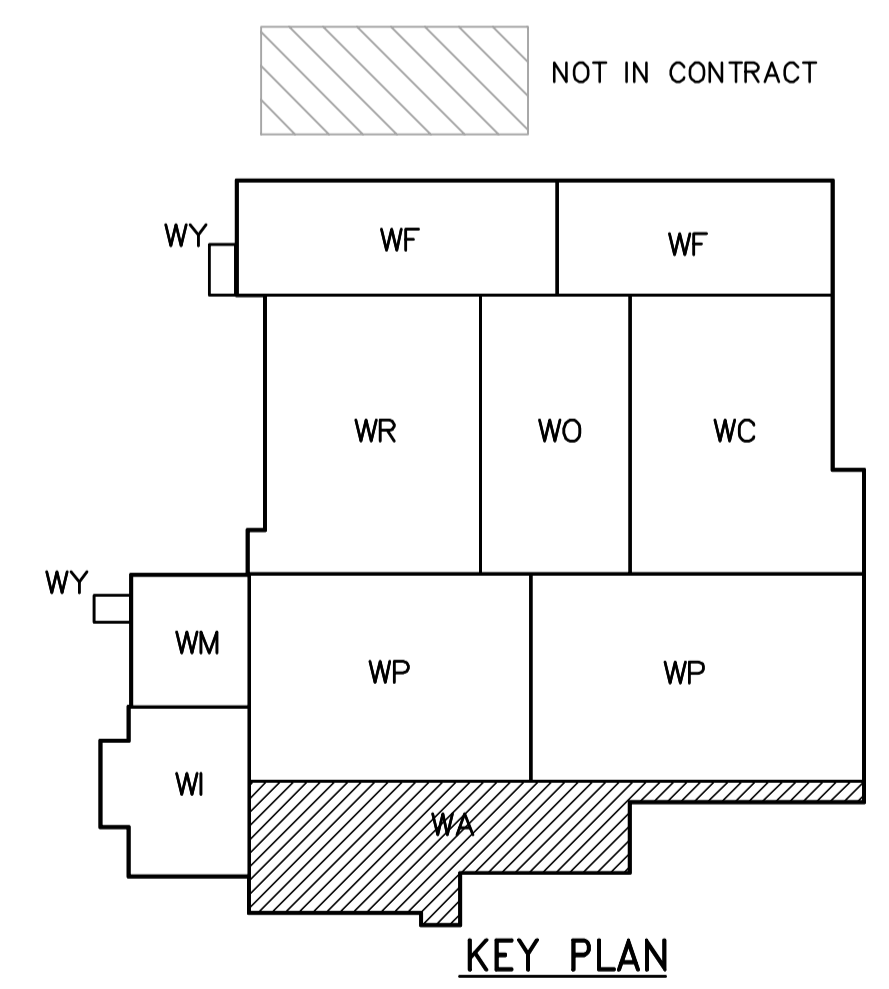

 <b>APEGN</b> Certificate of Authorization CH2M HILL Canada Ltd. No. 1441 Expiry: April 30, 2006	B.M. ELEV. <table border="1"> <tr><td> </td><td> </td><td> </td></tr> <tr><td> </td><td> </td><td> </td></tr> <tr><td> </td><td> </td><td> </td></tr> <tr><td> </td><td> </td><td> </td></tr> </table>													 Frederickson Cooper ARCHITECTS	 A Geo International Ltd. Company	ENGINEER'S SEAL	 <b>THE CITY OF WINNIPEG</b> WATER AND WASTE DEPARTMENT ENGINEERING DIVISION WATER TREATMENT PLANT ADMINISTRATION FOUNDATIONS AND CONCRETE STRUCTURES PLUMBING PIPE EMBEDS ADMINISTRATION AREA THIRD FLOOR PLAN	CITY FILE NUMBER
DESIGNED BY JZ	CHECKED BY DL	ORIGINAL SIGNED BY D.K. CUDDINGTON	SHEET OF															
DRAWN BY JMcP	APPROVED BY DJT	2006/02/06	CITY DRAWING NUMBER															
SCALE: 1:100	RELEASED FOR CONSTRUCTION BY: R. SOROKOWSKI	CONSULTANT DRAWING NO. WA-H9132	<b>1-0601A-A-H9132-001-00D</b>															
00 ISSUED FOR TENDER	2006/02/03 JZ	DATE 2005/07/15	DATE 2006/02/08															