


FOUNDATIONS AND CONCRETE STRUCTURES CONTRACT 583-2005

SECOND FLOOR PLAN  
1:100

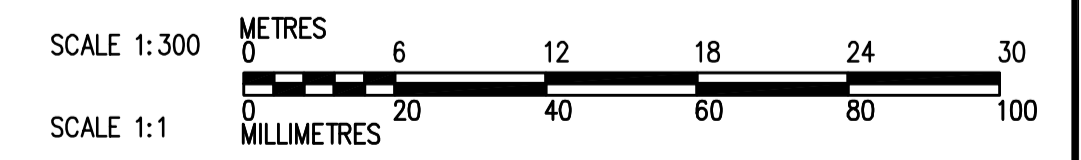

 Certificate of Authorization CH2M HILL Canada Ltd. No. 1441 Expiry: April 30, 2006	B.M. ELEV.	 Frederickson Cooper ARCHITECTS	 A Veolia International Ltd. Company	ENGINEER'S SEAL ORIGINAL SIGNED BY D.K. CUDDINGTON 2006/02/06	 THE CITY OF WINNIPEG WATER AND WASTE DEPARTMENT ENGINEERING DIVISION WATER TREATMENT PLANT MAIN BUILDING FOUNDATIONS AND CONCRETE STRUCTURES PLUMBING PIPE EMBEDS OVERALL SECOND FLOOR PLAN	CITY FILE NUMBER
	DESIGNED BY JZ/SW CHECKED BY DL	APPROVED BY DJT	CONSULTANT DRAWING NO. WB-H9121	SHEET OF		
	DRAWN BY JMcP SCALE: 1:300	RELEASED FOR CONSTRUCTION BY: R. SOROKOWSKI	CITY DRAWING NUMBER 1-060B-A-H9121-001-00D			
	NO. REVISIONS DATE BY	DATE 2005/07/15	DATE 2006/02/08			