


WP	NORTHING	EASTING
B1	5524106.095	647902.820
B2	5524055.454	647984.054
B3	5523969.679	647936.880
B4	5524020.193	647826.745

NOTE:  
FOR SURVEY DATA SEE DRAWING NO. WM-C0165.  
"FOR INFORMATION ONLY, NOT IN CONTRACT"

**SECOND FLOOR PLAN**  
1:300

FOUNDATIONS AND CONCRETE STRUCTURES CONTRACT 583-2005

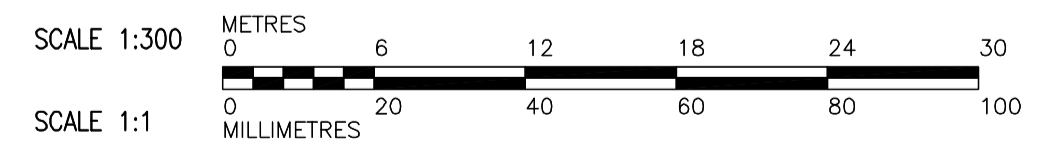

<p><b>APEGN</b> Certificate of Authorization CH2M HILL Canada Ltd. No. 1441 Expiry: April 30, 2006</p>	<p>Frederickson Cooper ARCHITECTS</p>	<p>A Neo International Ltd. Company</p>	ENGINEER'S SEAL	<p><b>THE CITY OF WINNIPEG</b> WATER AND WASTE DEPARTMENT ENGINEERING DIVISION</p>	
			DESIGNED BY: JC CHECKED BY: AP DRAWN BY: MS APPROVED BY: DJT SCALE: 1:300 RELEASED FOR CONSTRUCTION BY: R. SOROKOWSKI DATE: 2005/09/21		ORIGINAL SIGNED BY: D. KRUGER DATE: 2006/02/06 CONSULTANT DRAWING NO.: WB-S0120
B.M. ELEV.		NO. REVISIONS      DATE      BY		00 ISSUED FOR TENDER      2006/02/03      JC	