


WP	NORTHING	EASTING
B1	5524106.095	647902.820
B2	5524055.454	647984.054
B3	5523969.679	647936.880
B4	5524020.193	647826.745

NOTE:
FOR SURVEY DATA SEE DRAWING NO. WM-C0165.
"FOR INFORMATION ONLY, NOT IN CONTRACT"

ROOF PLAN
1:300

FOUNDATIONS AND CONCRETE STRUCTURES CONTRACT 583-2005

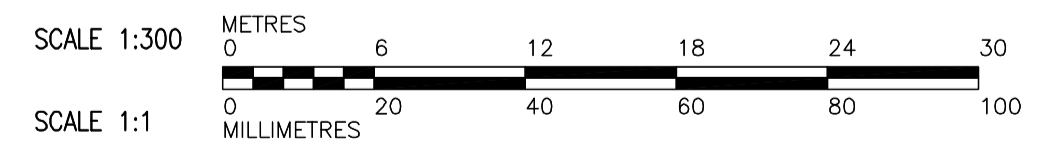

<p>Certificate of Authorization CH2M HILL Canada Ltd. No. 1441 Expiry: April 30, 2006</p>	<p>Frederickson Cooper ARCHITECTS</p>	<p>A Neo International Ltd. Company</p>	ENGINEER'S SEAL ORIGINAL SIGNED BY D. KRUGER 2006/02/06	<p>THE CITY OF WINNIPEG WATER AND WASTE DEPARTMENT ENGINEERING DIVISION</p> <p>WATER TREATMENT PLANT MAIN BUILDING FOUNDATIONS AND CONCRETE STRUCTURES</p> <p>STRUCTURAL ROOF KEY PLAN</p>	CITY FILE NUMBER SHEET OF
	DESIGNED BY JC CHECKED BY AP DRAWN BY RRL/PM APPROVED BY DJT	SCALE: 1:300 RELEASED FOR CONSTRUCTION BY: R. SOROKOWSKI	CONSULTANT DRAWING NO. WB-S0145		CITY DRAWING NUMBER 1-060B-A-50145-001-00D
	B.M. ELEV.	00 ISSUED FOR TENDER 2006/02/03 JC NO. REVISIONS DATE BY	DATE 2005/08/10 DATE 2006/02/08		