
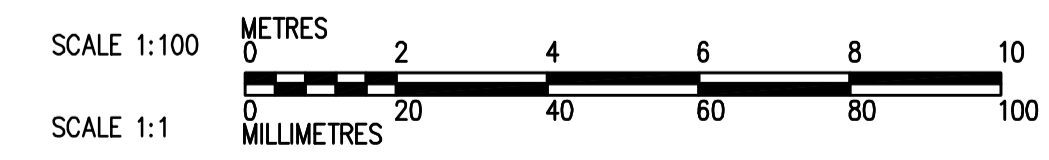


SECOND FLOOR PLAN
1:100

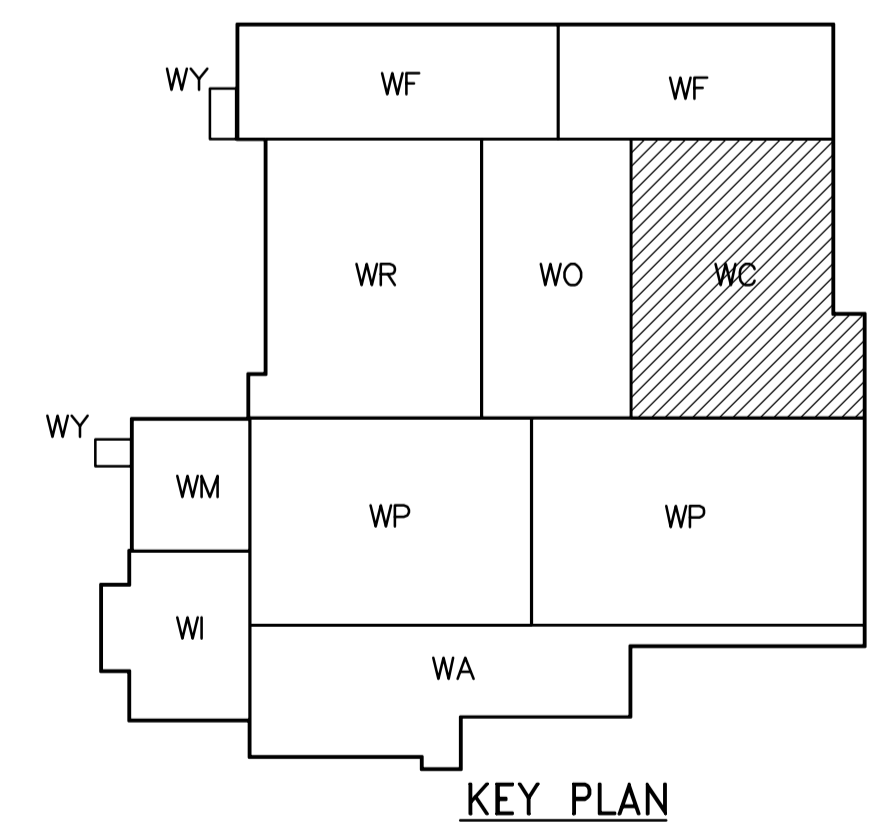

 APEGN Certificate of Authorization CH2M HILL Canada Ltd. No. 1441 Expiry: April 30, 2006	B.M. ELEV.	 Frederickson Cooper ARCHITECTS	 A Veolia International Ltd. Company	ENGINEER'S SEAL ORIGINAL SIGNED BY D.K. CUDDINGTON 2006/02/06	 THE CITY OF WINNIPEG WATER AND WASTE DEPARTMENT ENGINEERING DIVISION WATER TREATMENT PLANT CHEMICAL FEED SYSTEMS FOUNDATIONS AND CONCRETE STRUCTURES PLUMBING PIPE EMBEDS CHEMICAL AREA SECOND FLOOR PLAN	CITY FILE NUMBER
	00 ISSUED FOR TENDER 2006/02/03 SW	DESIGNED BY JZ/SW DRAWN BY JMcP SCALE: 1:100	CHECKED BY DL APPROVED BY DJT RELEASED FOR CONSTRUCTION BY: R. SOROKOWSKI	CONSULTANT DRAWING NO. WC-H9122		SHEET OF
NO. REVISIONS	DATE BY	DATE 2005/08/02	DATE 2006/02/08	CITY DRAWING NUMBER 1-0600C-A-H9122-001-00D		