
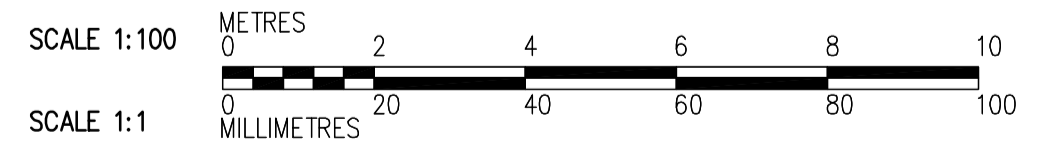


NOTES:
 1. DESIGN LIVE LOAD IS 14.4 kPa.
 2. FOR BEAM AND COLUMN SCHEDULE SEE DWG WC-S0515.

REBAR LEGEND:
 ——— TOP BARS
 - - - - - BOTTOM BARS

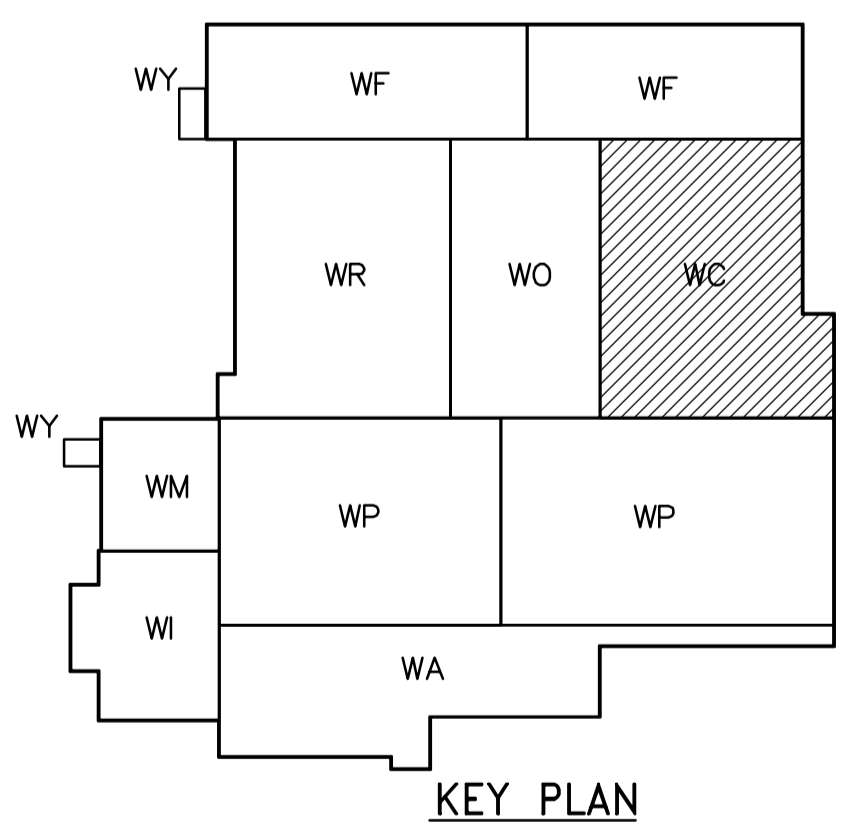

THIRD FLOOR PLAN
1:100

| | | | | | | |
|--|---|--|--|--|--|--|
| Certificate of Authorization CH2M HILL Canada Ltd. No. 1441 Expiry: April 30, 2006 | B.M. ELEV. | Frederickson Cooper ARCHITECTS | A Tyco International Ltd. Company | ENGINEER'S SEAL ORIGINAL SIGNED BY D. KRUGER 2006/02/06 | THE CITY OF WINNIPEG WATER AND WASTE DEPARTMENT ENGINEERING DIVISION WATER TREATMENT PLANT CHEMICAL FEED SYSTEMS FOUNDATIONS AND CONCRETE STRUCTURES STRUCTURAL ELECTRICAL AND MECHANICAL ROOM AREA THIRD FLOOR PLAN | CITY FILE NUMBER |
| | 00 ISSUED FOR TENDER 2006/02/03 EL | DESIGNED BY EL DRAWN BY RL/DJ SCALE: 1:100 | CHECKED BY AP APPROVED BY DJT RELEASED FOR CONSTRUCTION BY: R. SOROKOWSKI | CONSULTANT DRAWING NO. WC-S0131 | | SHEET OF |
| | NO. REVISIONS DATE BY DATE 2005/07/07 DATE 2006/02/08 | DATE 2005/07/07 DATE 2006/02/08 | CONSULTANT DRAWING NO. WC-S0131 | CITY DRAWING NUMBER 1-0601C-A-50131-001-000 | | CITY DRAWING NUMBER 1-0601C-A-50131-001-000 |
| | | | | | | CITY DRAWING NUMBER 1-0601C-A-50131-001-000 |