




LOWER LEVEL PLAN  
1:100

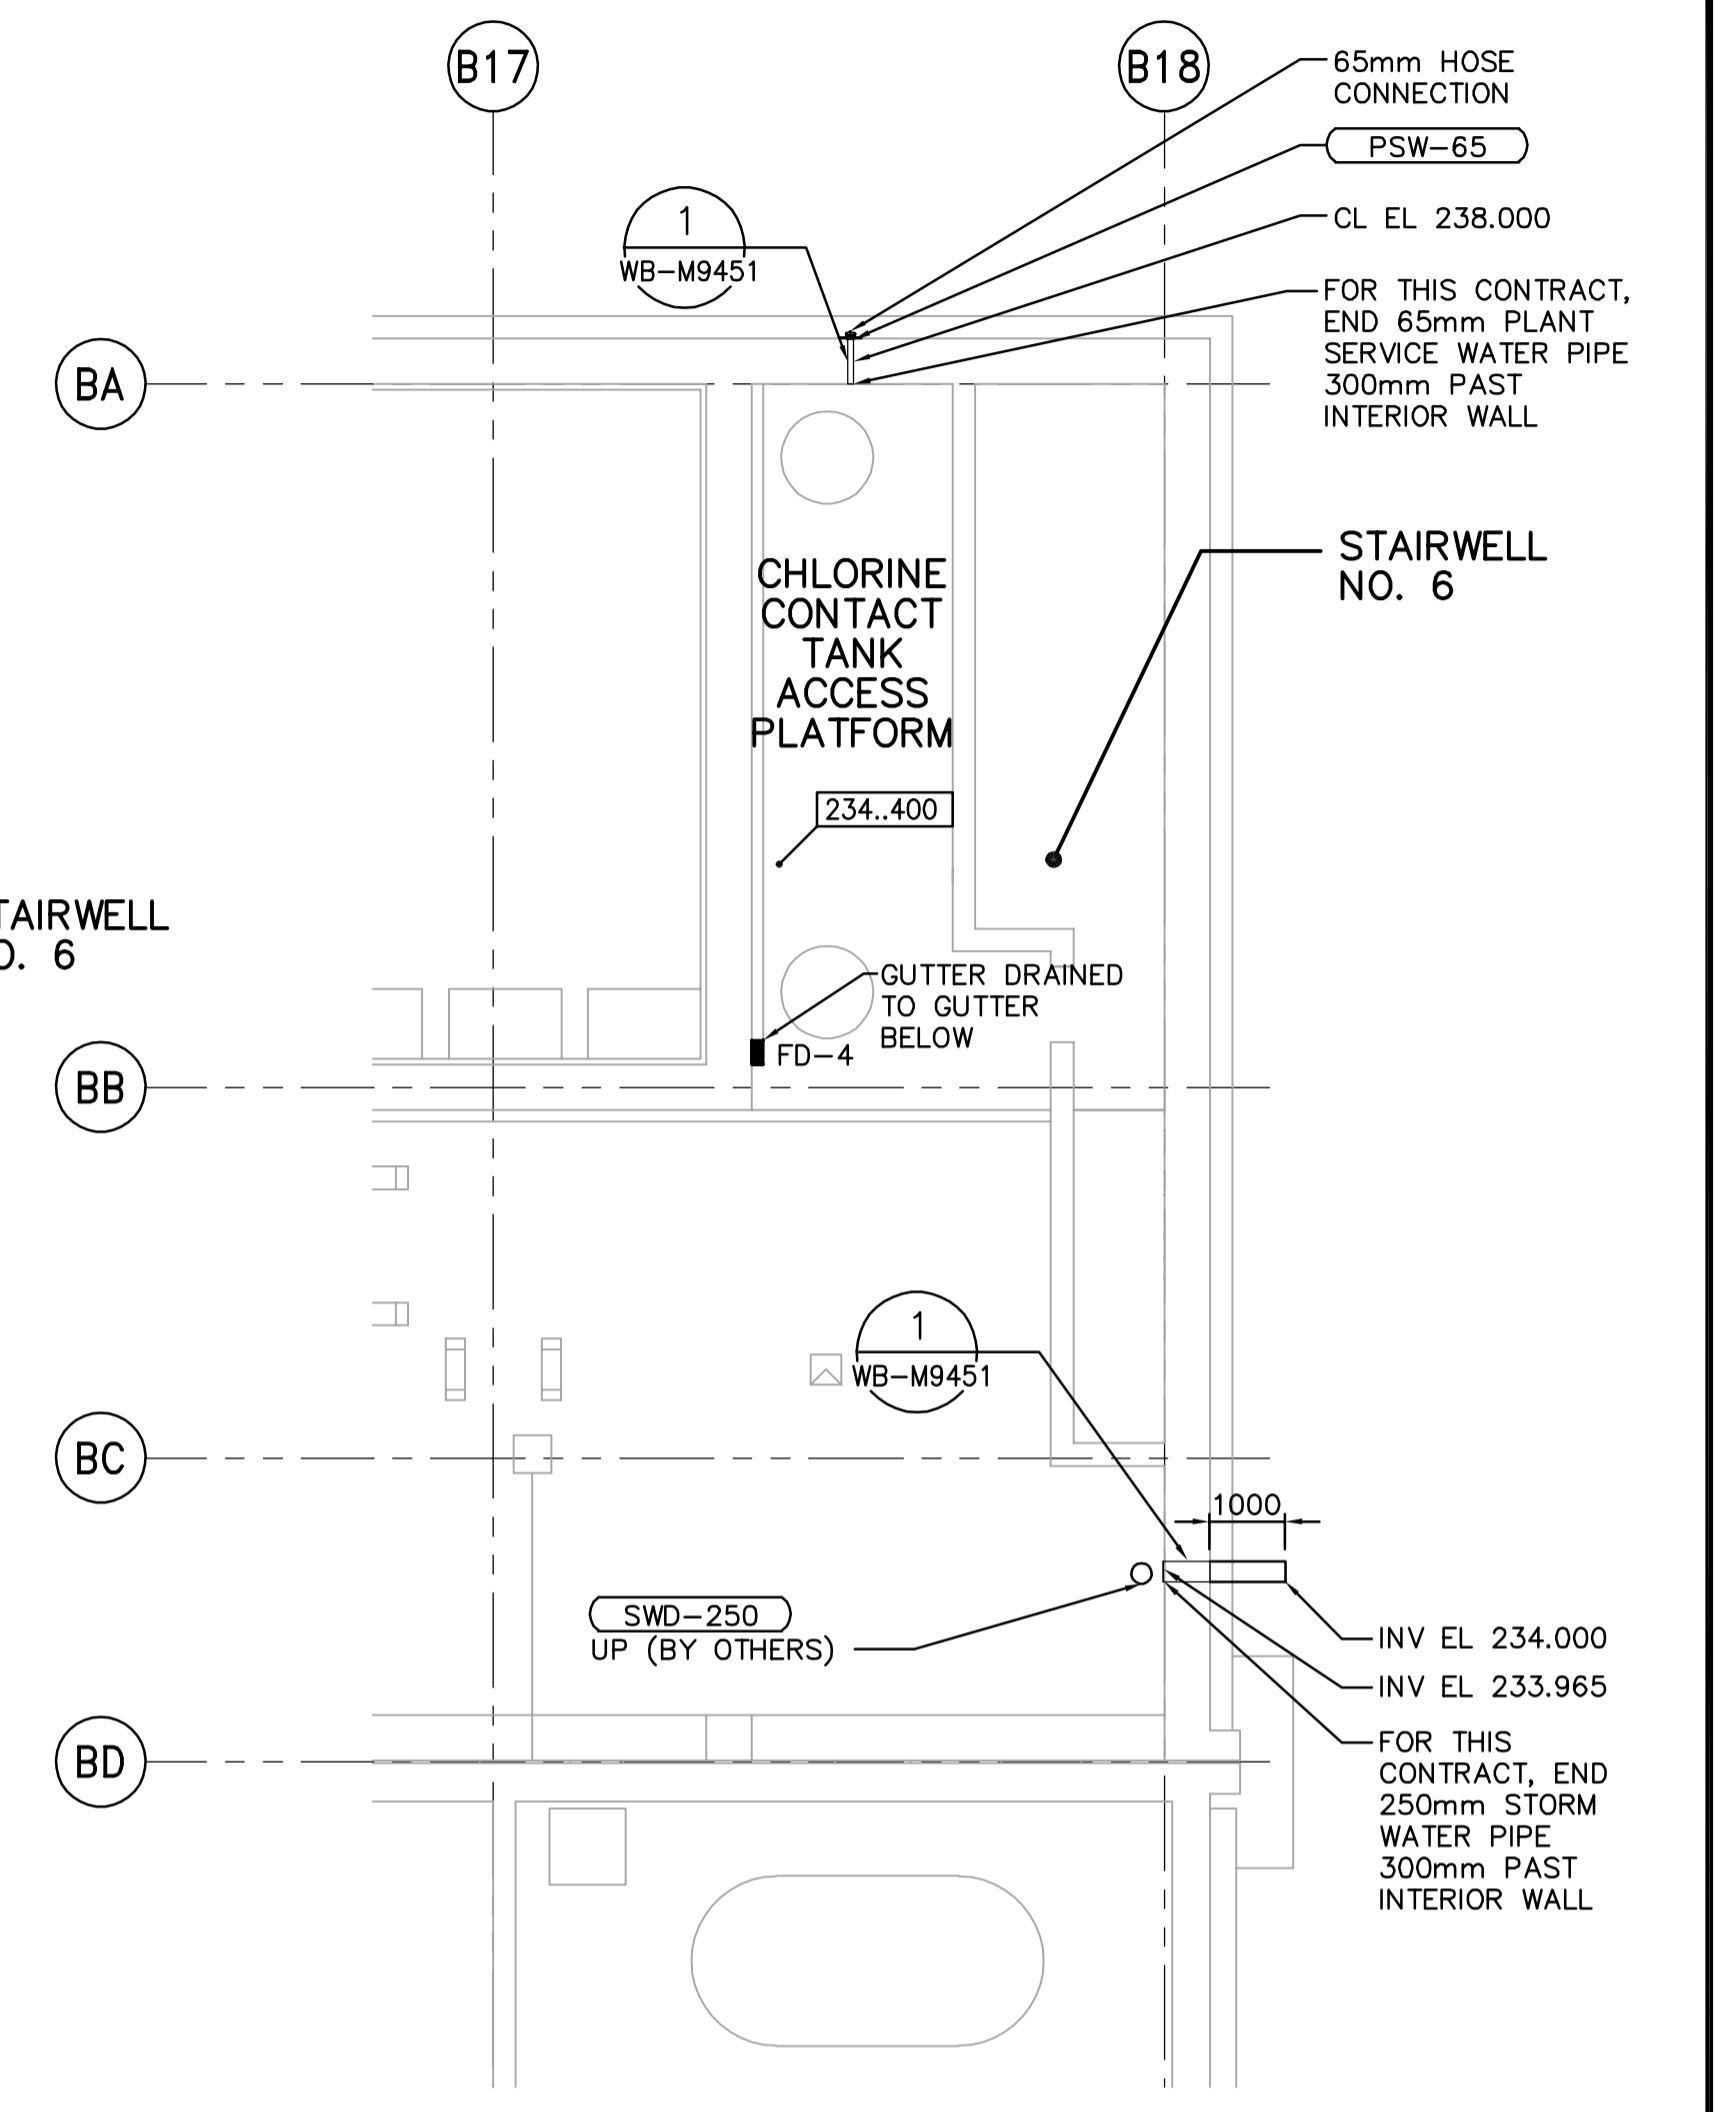


PARTIAL FIRST FLOOR PLAN  
1:100

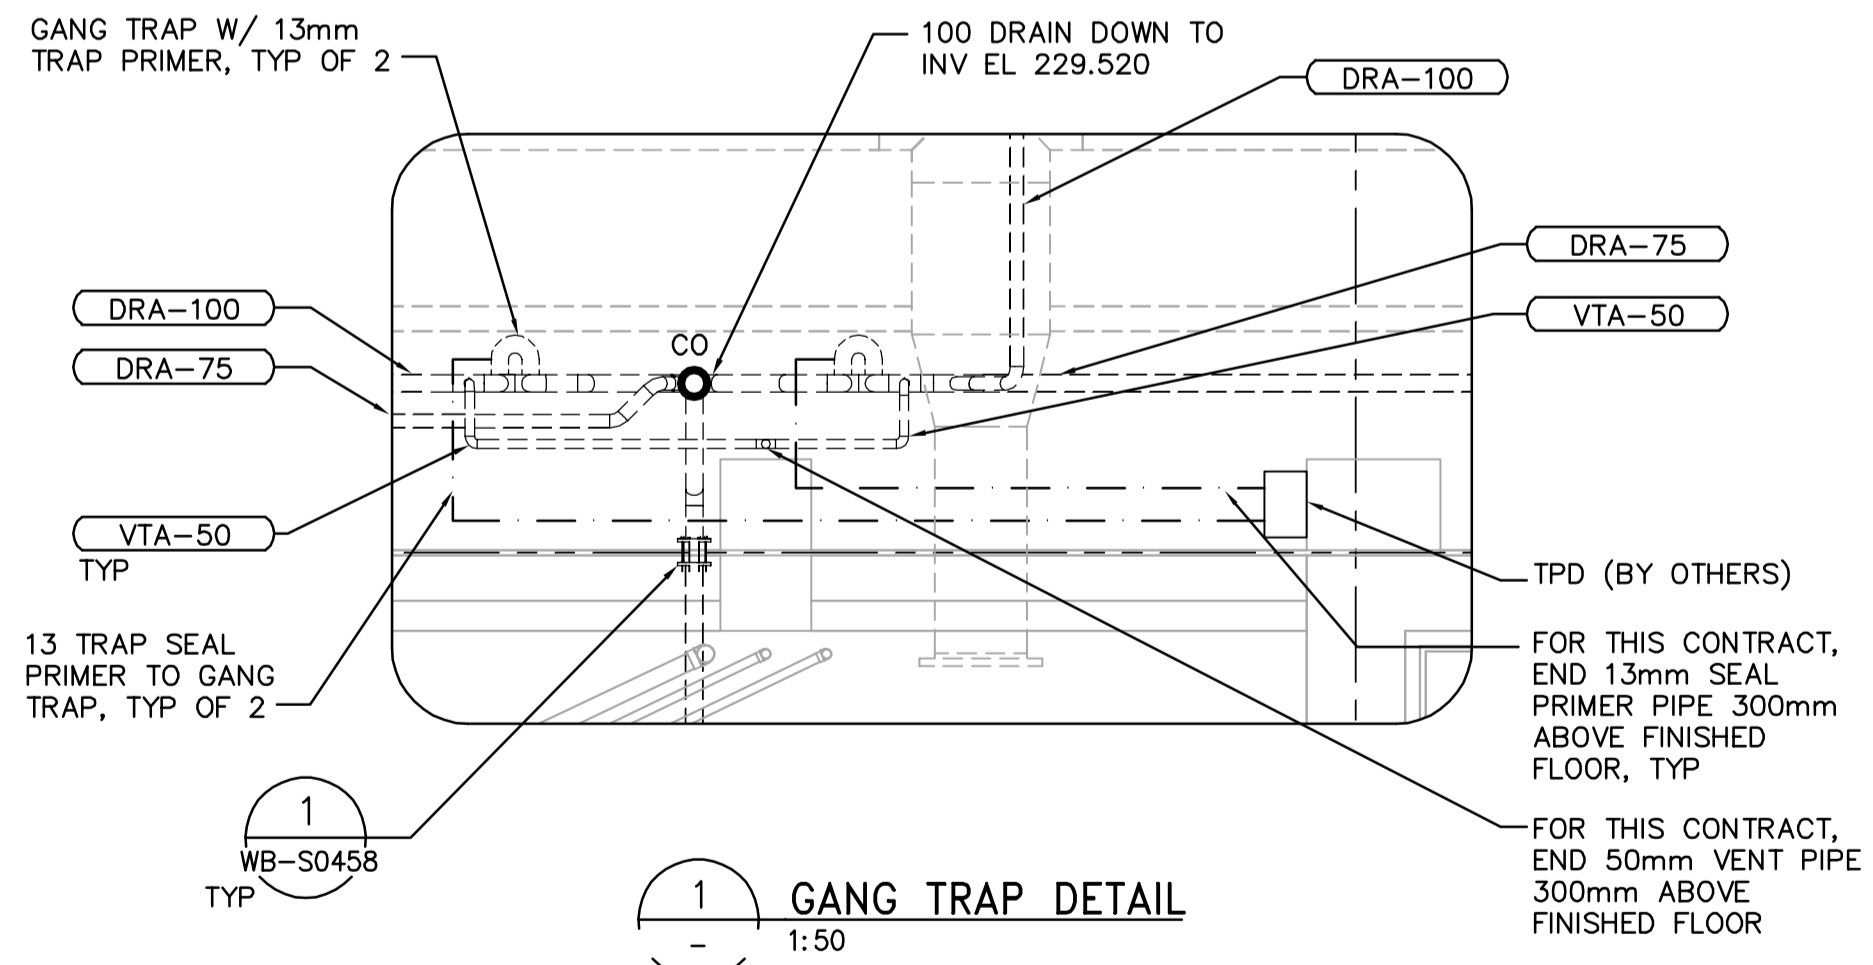

1 GANG TRAP DETAIL  
1:50

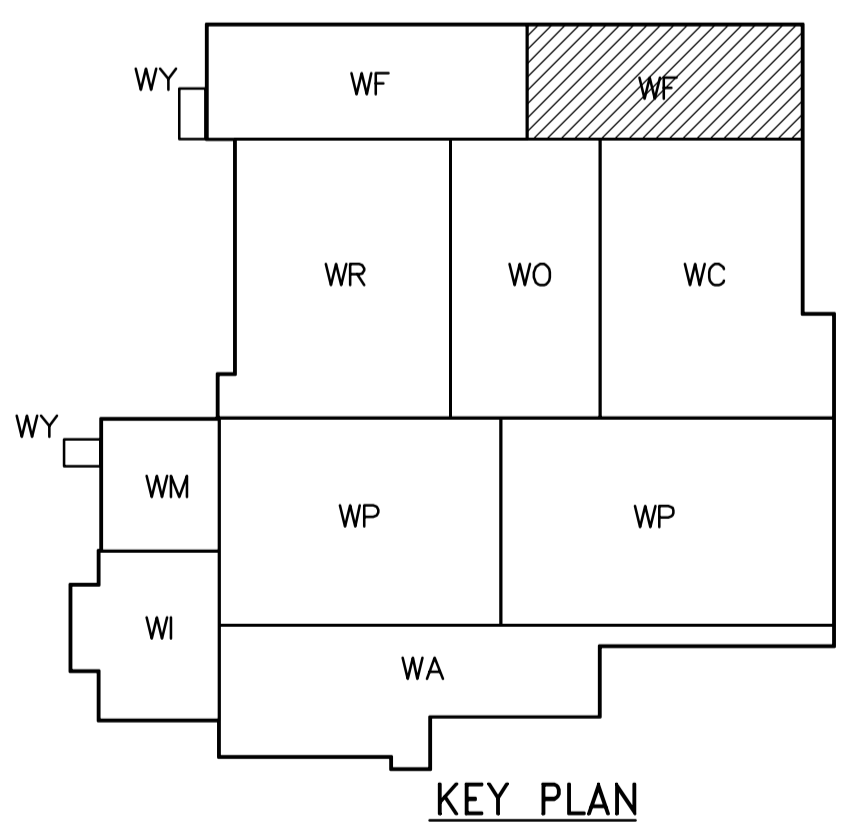

KEY PLAN

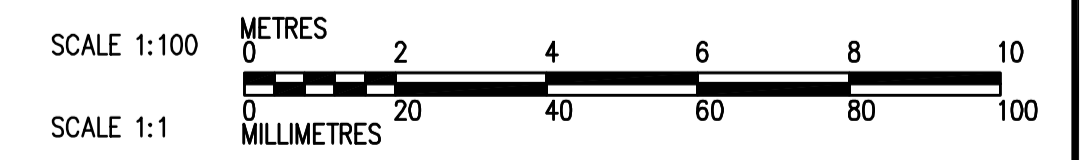

<p><b>Certificate of Authorization</b> CH2M HILL Canada Ltd. No. 1441 Expiry: April 30, 2006</p>	B.M. ELEV.	<p>Frederickson Cooper ARCHITECTS</p>	<p>A Veolia International Ltd. Company</p>	ENGINEER'S SEAL	<p><b>THE CITY OF WINNIPEG</b> WATER AND WASTE DEPARTMENT ENGINEERING DIVISION</p>		
				DESIGNED BY JZ/SW		CHECKED BY DL	ORIGINAL SIGNED BY D.K. CUDDINGTON
				DRAWN BY JMcP		APPROVED BY DJT	2006/02/06
				SCALE: 1:100		RELEASED FOR CONSTRUCTION BY: R. SOROKOWSKI	CONSULTANT DRAWING NO. WF-H9105
	00 ISSUED FOR TENDER 2006/02/03 SW	DATE 2005/08/02	DATE 2006/02/08		<p>WATER TREATMENT PLANT FILTRATION FOUNDATIONS AND CONCRETE STRUCTURES</p> <p>PLUMBING PIPE EMBEDS FILTRATION AREA 2 LOWER LEVEL PLAN</p>		
	NO. REVISIONS	DATE	BY		<p>CITY FILE NUMBER</p> <p>SHEET OF</p> <p>CITY DRAWING NUMBER</p> <p><b>1-060F-A-H9105-001-00D</b></p>		