
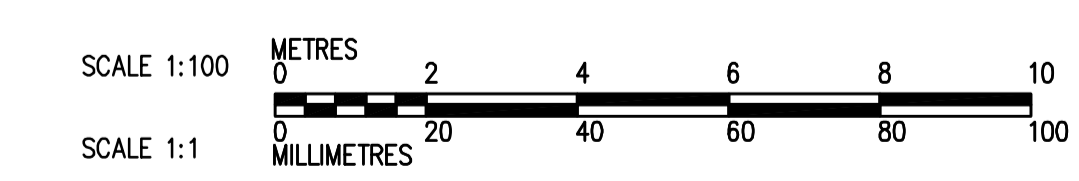


THIRD FLOOR PLAN
1:100

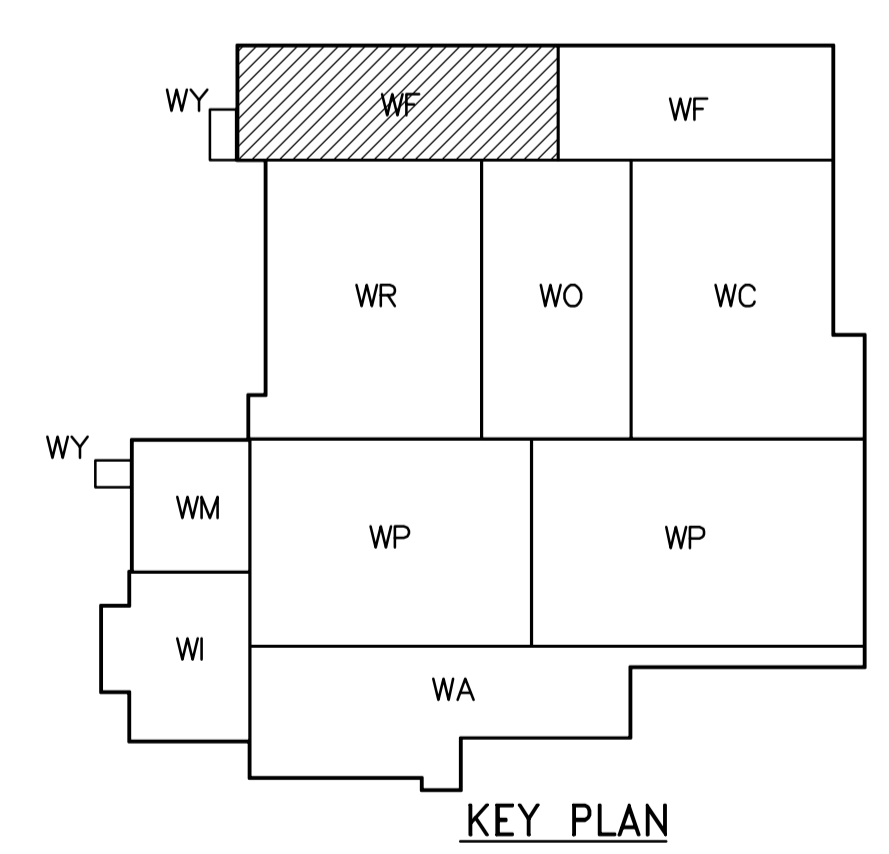

<p>APEGN Certificate of Authorization CH2M HILL Canada Ltd. No. 1441 Expiry: April 30, 2006</p>	<p>Frederickson Cooper ARCHITECTS</p>	<p>EarthTech A Veolia International Ltd. Company</p>	ENGINEER'S SEAL	<p>THE CITY OF WINNIPEG WATER AND WASTE DEPARTMENT ENGINEERING DIVISION</p>
			DESIGNED BY: JZ/SW CHECKED BY: DL DRAWN BY: JMcP APPROVED BY: DJT SCALE: 1:100 RELEASED FOR CONSTRUCTION BY: R. SOROKOWSKI	
B.M. ELEV.			WATER TREATMENT PLANT FILTRATION FOUNDATIONS AND CONCRETE STRUCTURES PLUMBING PIPE EMBEDS FILTRATION AREA 1 THIRD FLOOR PLAN	
00 ISSUED FOR TENDER 2006/02/03 SW NO. REVISIONS DATE BY DATE 2005/08/02 DATE 2006/02/08			CITY FILE NUMBER SHEET OF CITY DRAWING NUMBER 1-0607-A-H9133-001-00D	