
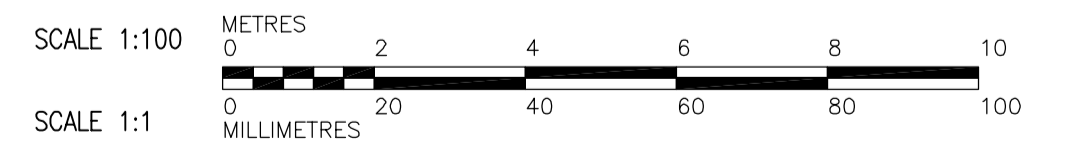


LIFTING EYE
 ⊕ TYPE "1" (900 kg)
 ⊗ TYPE "2" (1800 kg)

THIRD FLOOR PLAN AT EL. 245.000
 1:100

- NOTES:**
1. FOR BEAM AND COLUMN SCHEDULE SEE DWG. WF-S0515
 2. 5 PIECES ALUMINIUM GRATING (TYP.), HINGED TO THE CURB, TO NORTH SIDE IN EACH FILTER.
 3. CMU WALL (NIC) TO BE PROVIDED AT ALL EXTERIOR LOCATION FROM EL. 245.000 TO EL. 248.300 FOR DOWELS SEE DETAIL

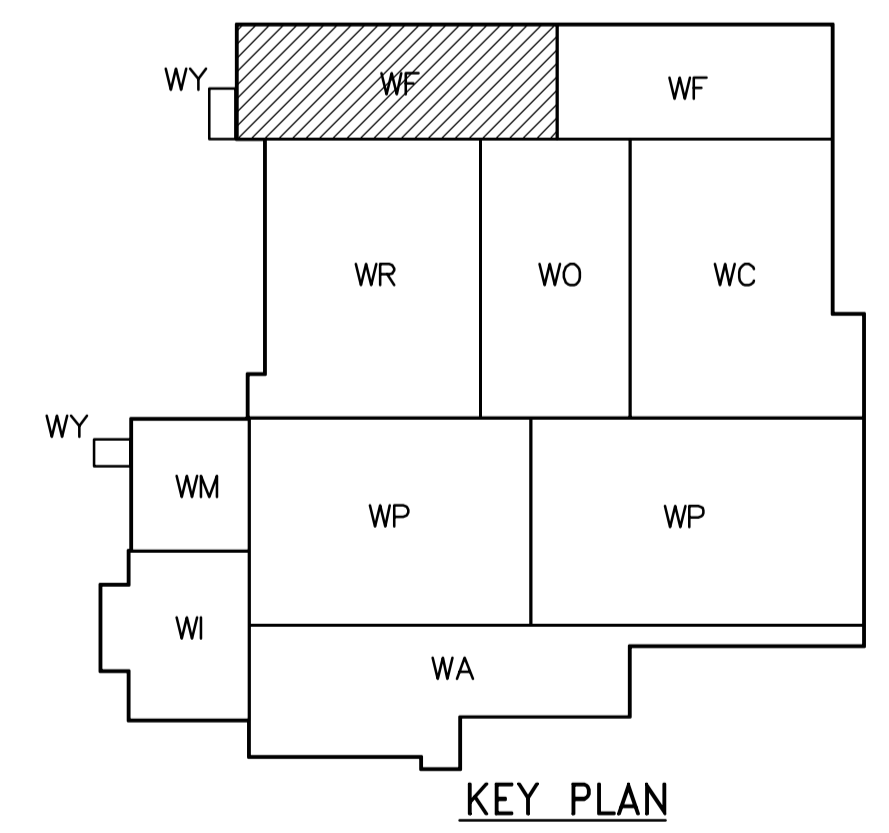

 Certificate of Authorization CH2M HILL Canada Ltd. No. 1441 Expiry: April 30, 2006	 Frederickson Cooper ARCHITECTS	 A Veolia International Ltd. Company	ENGINEER'S SEAL ORIGINAL SIGNED BY D. KRUGER 2006/02/06	 THE CITY OF WINNIPEG WATER AND WASTE DEPARTMENT ENGINEERING DIVISION WATER TREATMENT PLANT FILTRATION FOUNDATIONS AND CONCRETE STRUCTURES STRUCTURAL FILTRATION AREA 1 THIRD FLOOR PLAN	CITY FILE NUMBER SHEET OF
			CONSULTANT DRAWING NO. WF-S0131		CITY DRAWING NUMBER 1-0601F-A-80131-001-00D
B.M. ELEV. NO. REVISIONS DATE BY	DESIGNED BY KA DRAWN BY PM SCALE: 1:100 ISSUED FOR TENDER 2006/02/03 NO. REVISIONS DATE BY	CHECKED BY AP APPROVED BY DJT RELEASED FOR CONSTRUCTION BY: R. SOROKOWSKI 2005/08/10	DATE 2006/02/08	DATE 2006/02/08	DATE 2006/02/08