
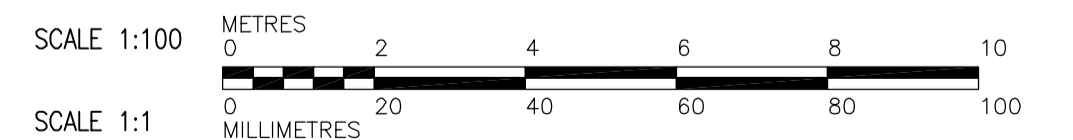


THIRD FLOOR PLAN AT EL 245.000
1:100

NOTES:
1. DESIGN LIVE LOAD IS 14.4 kPa

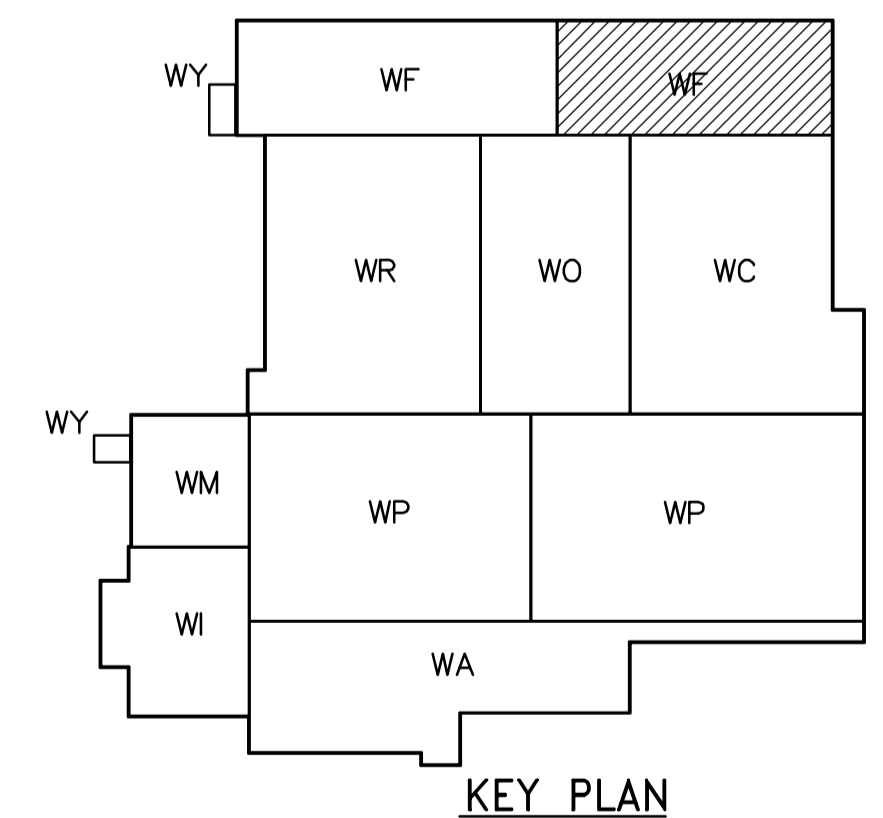

 Certificate of Authorization CH2M HILL Canada Ltd. No. 1441 Expiry: April 30, 2006	B.M. ELEV.	 Frederickson Cooper ARCHITECTS	 A Geo International Ltd. Company	ENGINEER'S SEAL ORIGINAL SIGNED BY D. KRUGER 2006/02/06	 THE CITY OF WINNIPEG WATER AND WASTE DEPARTMENT ENGINEERING DIVISION WATER TREATMENT PLANT FILTRATION FOUNDATIONS AND CONCRETE STRUCTURES STRUCTURAL FILTRATION AREA 2 THIRD FLOOR REINFORCING PLAN	CITY FILE NUMBER
	DESIGNED BY KA	CHECKED BY AP	APPROVED BY DJT	SHEET OF		
	DRAWN BY PM	SCALE: 1:100	RELEASED FOR CONSTRUCTION BY: R. SOROKOWSKI	CITY DRAWING NUMBER 1-060F-A-50136-001-00D		
	00 ISSUED FOR TENDER NO. REVISIONS	2006/02/03 DATE BY	2005/08/10 DATE	2006/02/08 DATE		CONSULTANT DRAWING NO. WF-S0136