
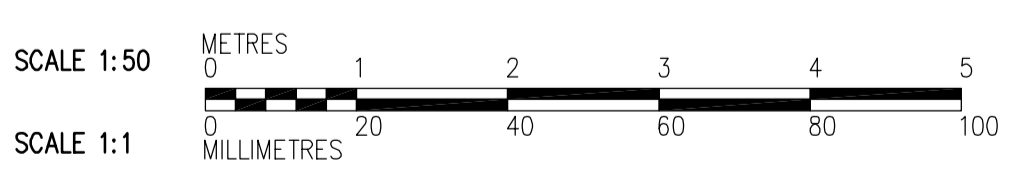






- NOTES:
- SEE DWGS WM-S0111 TO WM-S0146 FOR SLAB REINFORCING, UNO.
 - SEE DWG WM-S0515 FOR BEAM AND COLUMN SCHEDULES.
 - FOR TYPICAL WALL CORNER REINF SEE  WB-S0452

G SECTION
 WM-F0105 1:50
 WM-S0111
 WM-S0141
 WM-S0146



 Certificate of Authorization CH2M HILL Canada Ltd. No. 1441 Expiry: April 30, 2006	B.M. ELEV. <table border="1"> <tr><td> </td><td> </td><td> </td></tr> <tr><td> </td><td> </td><td> </td></tr> <tr><td> </td><td> </td><td> </td></tr> <tr><td> </td><td> </td><td> </td></tr> </table>													 Frederickson Cooper ARCHITECTS	 A Geo International Ltd. Company	ENGINEER'S SEAL	 THE CITY OF WINNIPEG WATER AND WASTE DEPARTMENT ENGINEERING DIVISION	WATER TREATMENT PLANT GENERAL PLANT SERVICES/MISCELLANEOUS FOUNDATIONS AND CONCRETE STRUCTURES	CITY FILE NUMBER
DESIGNED BY EL CHECKED BY AP DRAWN BY RL APPROVED BY DJT SCALE: 1:50 RELEASED FOR CONSTRUCTION BY: R. SOROKOWSKI	ORIGINAL SIGNED BY D. KRUGER 2006/02/06	SHEET OF																	
00 ISSUED FOR TENDER 2006/02/03 EL NO. REVISIONS DATE BY	DATE 2005/12/29 DATE 2006/02/08	CONSULTANT DRAWING NO. WM-S0205	STRUCTURAL ELECTRICAL ROOM SECTION CITY DRAWING NUMBER 1-060M-A-S0205-001-00D																