


FIRST FLOOR PLAN
1:100

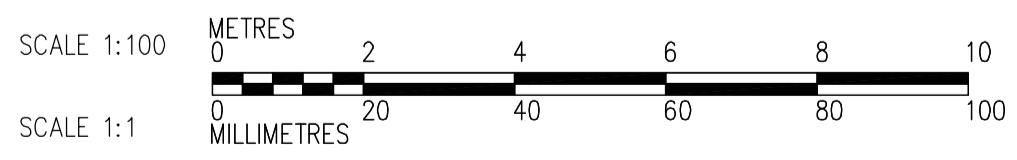

 Certificate of Authorization CH2M HILL Canada Ltd. No. 1441 Expiry: April 30, 2006	B.M. ELEV.	 Frederickson Cooper ARCHITECTS	 A Veolia International Ltd. Company	ENGINEER'S SEAL ORIGINAL SIGNED BY D.K. CUDDINGTON 2006/02/06	 THE CITY OF WINNIPEG WATER AND WASTE DEPARTMENT ENGINEERING DIVISION WATER TREATMENT PLANT FLOCCULATION AND DAF FOUNDATIONS AND CONCRETE STRUCTURES PLUMBING PIPE EMBEDS FLOC/DAF AREA 1 FIRST FLOOR PLAN	CITY FILE NUMBER
	00 ISSUED FOR TENDER 2006/02/03 SW	DESIGNED BY JZ/SW CHECKED BY DL DRAWN BY JMcP APPROVED BY DJT SCALE: 1:100 RELEASED FOR CONSTRUCTION BY: R. SOROKOWSKI	CONSULTANT DRAWING NO. WP-H9113	SHEET OF CITY DRAWING NUMBER 1-060P-A-H913-001-00D		
	NO. REVISIONS DATE BY DATE 2005/07/15 DATE 2006/02/08					