
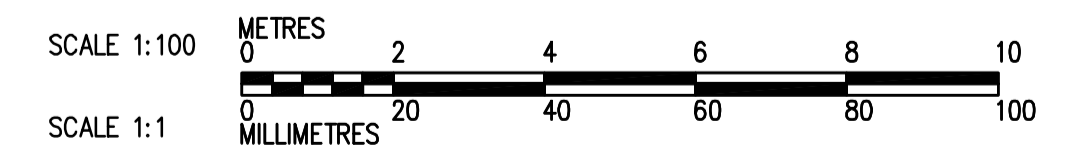


FIRST FLOOR PLAN  
1:100

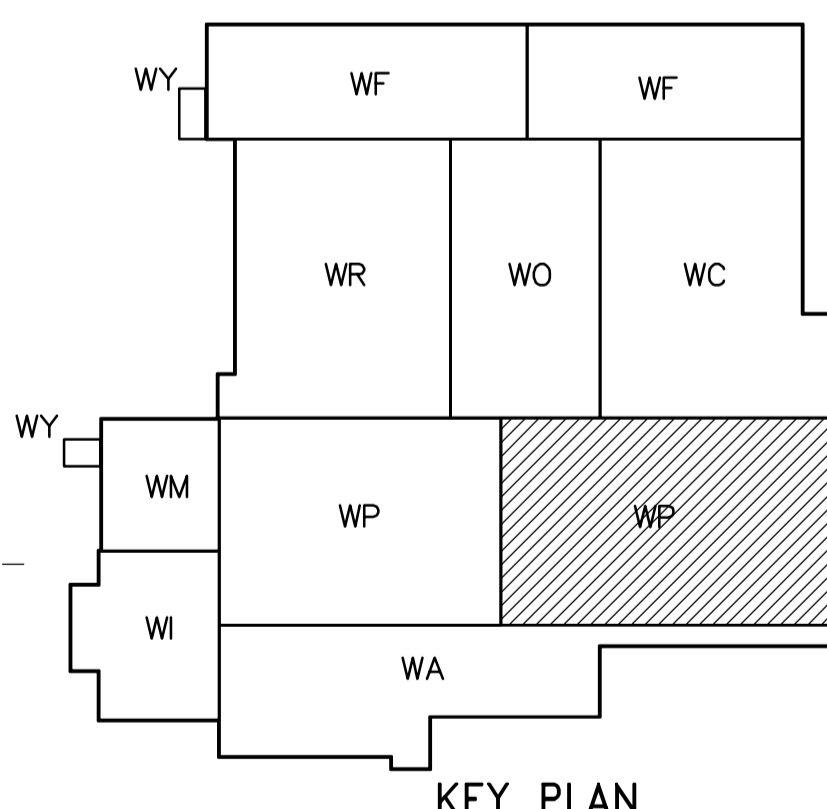

 <b>Certificate of Authorization</b> CH2M HILL Canada Ltd. No. 1441 Expiry: April 30, 2006	B.M. ELEV.	 Frederickson Cooper ARCHITECTS	 A Veolia International Ltd. Company	ENGINEER'S SEAL ORIGINAL SIGNED BY D.K. CUDDINGTON 2006/02/06	 <b>THE CITY OF WINNIPEG</b> WATER AND WASTE DEPARTMENT ENGINEERING DIVISION WATER TREATMENT PLANT FLOCCULATION AND DAF FOUNDATIONS AND CONCRETE STRUCTURES PLUMBING PIPE EMBEDS FLOC/DAF AREA 2 FIRST FLOOR PLAN	CITY FILE NUMBER													
	<table border="1"> <tr> <td>00</td> <td>ISSUED FOR TENDER</td> <td>2006/02/03</td> <td>SW</td> <td>DATE</td> <td>2005/07/15</td> <td>DATE</td> <td>2006/02/08</td> </tr> <tr> <td>NO.</td> <td>REVISIONS</td> <td>DATE</td> <td>BY</td> <td>DATE</td> <td>2005/07/15</td> <td>DATE</td> <td>2006/02/08</td> </tr> </table>	00	ISSUED FOR TENDER	2006/02/03		SW	DATE	2005/07/15	DATE	2006/02/08	NO.	REVISIONS	DATE	BY	DATE	2005/07/15	DATE	2006/02/08	DESIGNED BY JZ/SW CHECKED BY DL DRAWN BY JMcP APPROVED BY DJT SCALE: 1:100 RELEASED FOR CONSTRUCTION BY: R. SOROKOWSKI
00	ISSUED FOR TENDER	2006/02/03	SW	DATE	2005/07/15	DATE	2006/02/08												
NO.	REVISIONS	DATE	BY	DATE	2005/07/15	DATE	2006/02/08												