


THIRD FLOOR PLAN  
1:100

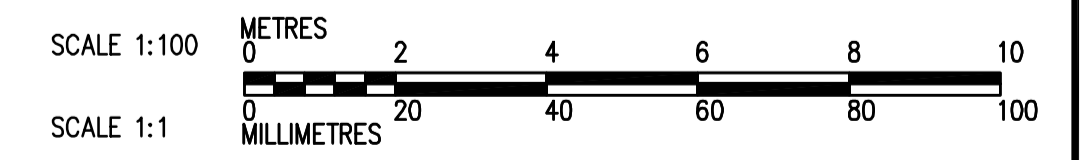

<p>Certificate of Authorization CH2M HILL Canada Ltd. No. 1441 Expiry: April 30, 2006</p>	<p>Frederickson Cooper ARCHITECTS</p>	<p>A Veolia International Ltd. Company</p>	ENGINEER'S SEAL ORIGINAL SIGNED BY D.K. CUDDINGTON 2006/02/06	<p>THE CITY OF WINNIPEG WATER AND WASTE DEPARTMENT ENGINEERING DIVISION</p>	
			CONSULTANT DRAWING NO. WP-H9134		WATER TREATMENT PLANT FLOCCULATION AND DAF FOUNDATIONS AND CONCRETE STRUCTURES
DESIGNED BY JZ/SW CHECKED BY DL DRAWN BY JMcP APPROVED BY DJT		SCALE: 1:100 RELEASED FOR CONSTRUCTION BY: R. SOROKOWSKI		PLUMBING PIPE EMBEDS FLOC/DAF AREA 2 THIRD FLOOR PLAN	
00 ISSUED FOR TENDER 2006/02/03 SW NO. REVISIONS DATE BY		DATE 2005/07/15 DATE 2006/02/08			